



CG
drawn by _____
MA
checked by _____
date JULY 2024
revisions _____






MOORE
PUBLIC SCHOOLS

EARLYWINE
ELEMENTARY SCHOOL
MEDIA CENTER

Sheet No.:

A104

OWNERSHIP USE OF DOCUMENTS:
AGP EXPRESSLY RESERVES ITS
COPYRIGHT AND OTHER PROPERTY
RIGHTS OF ALL PLANS AND DRAWINGS
DESIGNED AND/OR PRODUCED. PLANS
AND DRAWINGS ARE NOT TO BE
REPRODUCED IN ANY FORM OR MANNER
WITHOUT THE EXPRESS WRITTEN
CONSENT OF AGP.

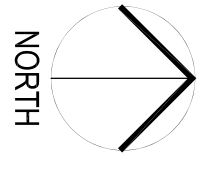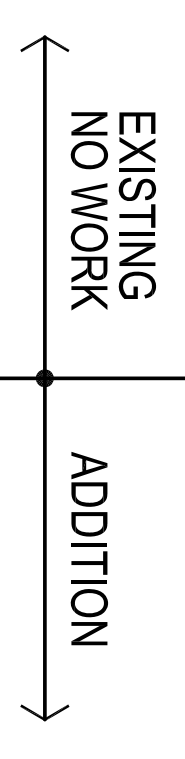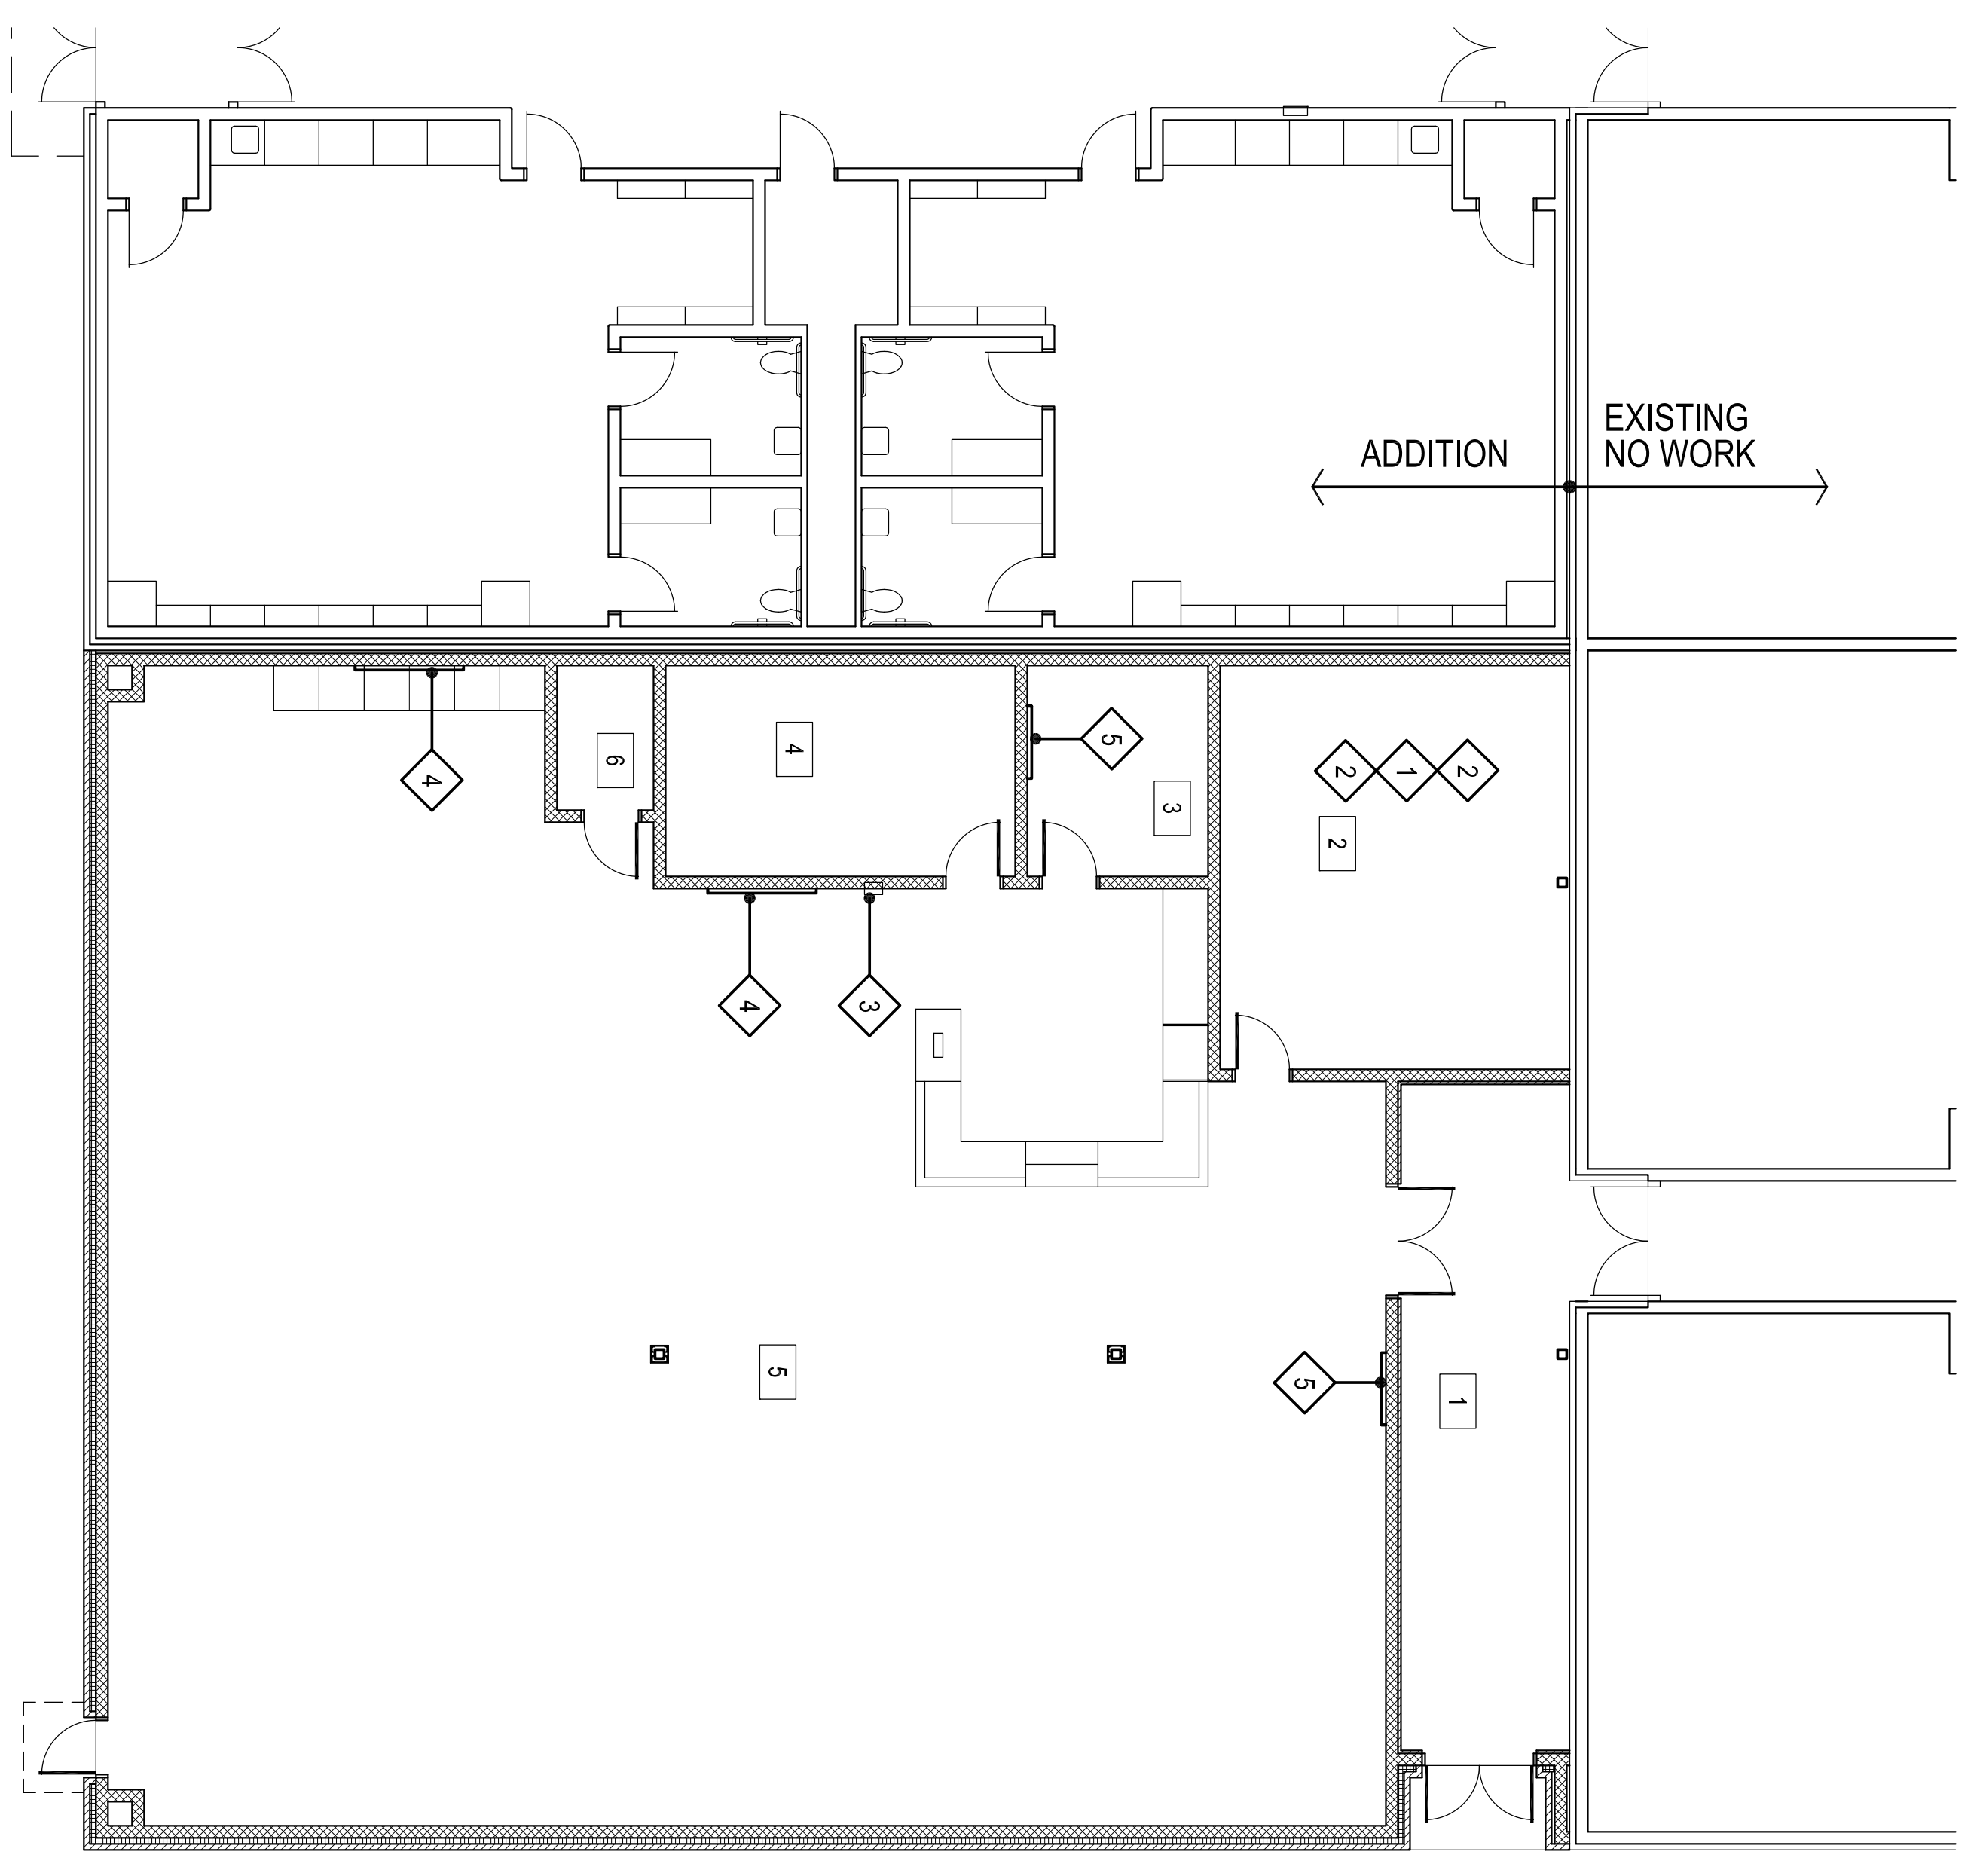

1
FLOOR PLAN
1/8" = 1'-0"

ITEM NO.	CFI	OF / CI	DESCRIPTION	MANUFACTURER		REMARKS
				NAME	MODEL NO.	
1	●		DISPLAY	BEST-RITE CHALKBOARD CO.	RE: SPECS	RE: TECHNOLOGY PLANS
2	●		MARKERBOARD - 4'-0"	JL INDUSTRIES	RE: SPECS	W/ CHALK RAIL
3	●		FIRE EXTINGUISHER & CABINET	BEST-RITE CHALKBOARD CO.	RE: SPECS	
4	●		TACKBOARD - 8'-0"	BEST-RITE CHALKBOARD CO.	RE: SPECS	
5	●		TACKBOARD - 4'-0"	BEST-RITE CHALKBOARD CO.	RE: SPECS	

2 EQUIPMENT SCHEDULE

NOTE:
ALL CHALKBOARDS & TACKBOARDS MOUNTED
@ EXTERIOR WALLS SHALL HAVE "STAND-OFF"
MOUNTING BRACKETS TO PREVENT CONDENSATION
BEHIND BOARDS.

