



DW  
drawn by  
TVO  
checked by  
SEPTEMBER 2021  
date

revisions


MOORE PUBLIC SCHOOLS  
BOARD OF EDUCATION  
MOORE, OKLAHOMA



CLASSROOM ADDITION  
HIGHLAND EAST  
JUNIOR HIGH SCHOOL

sheet no:

**E401**

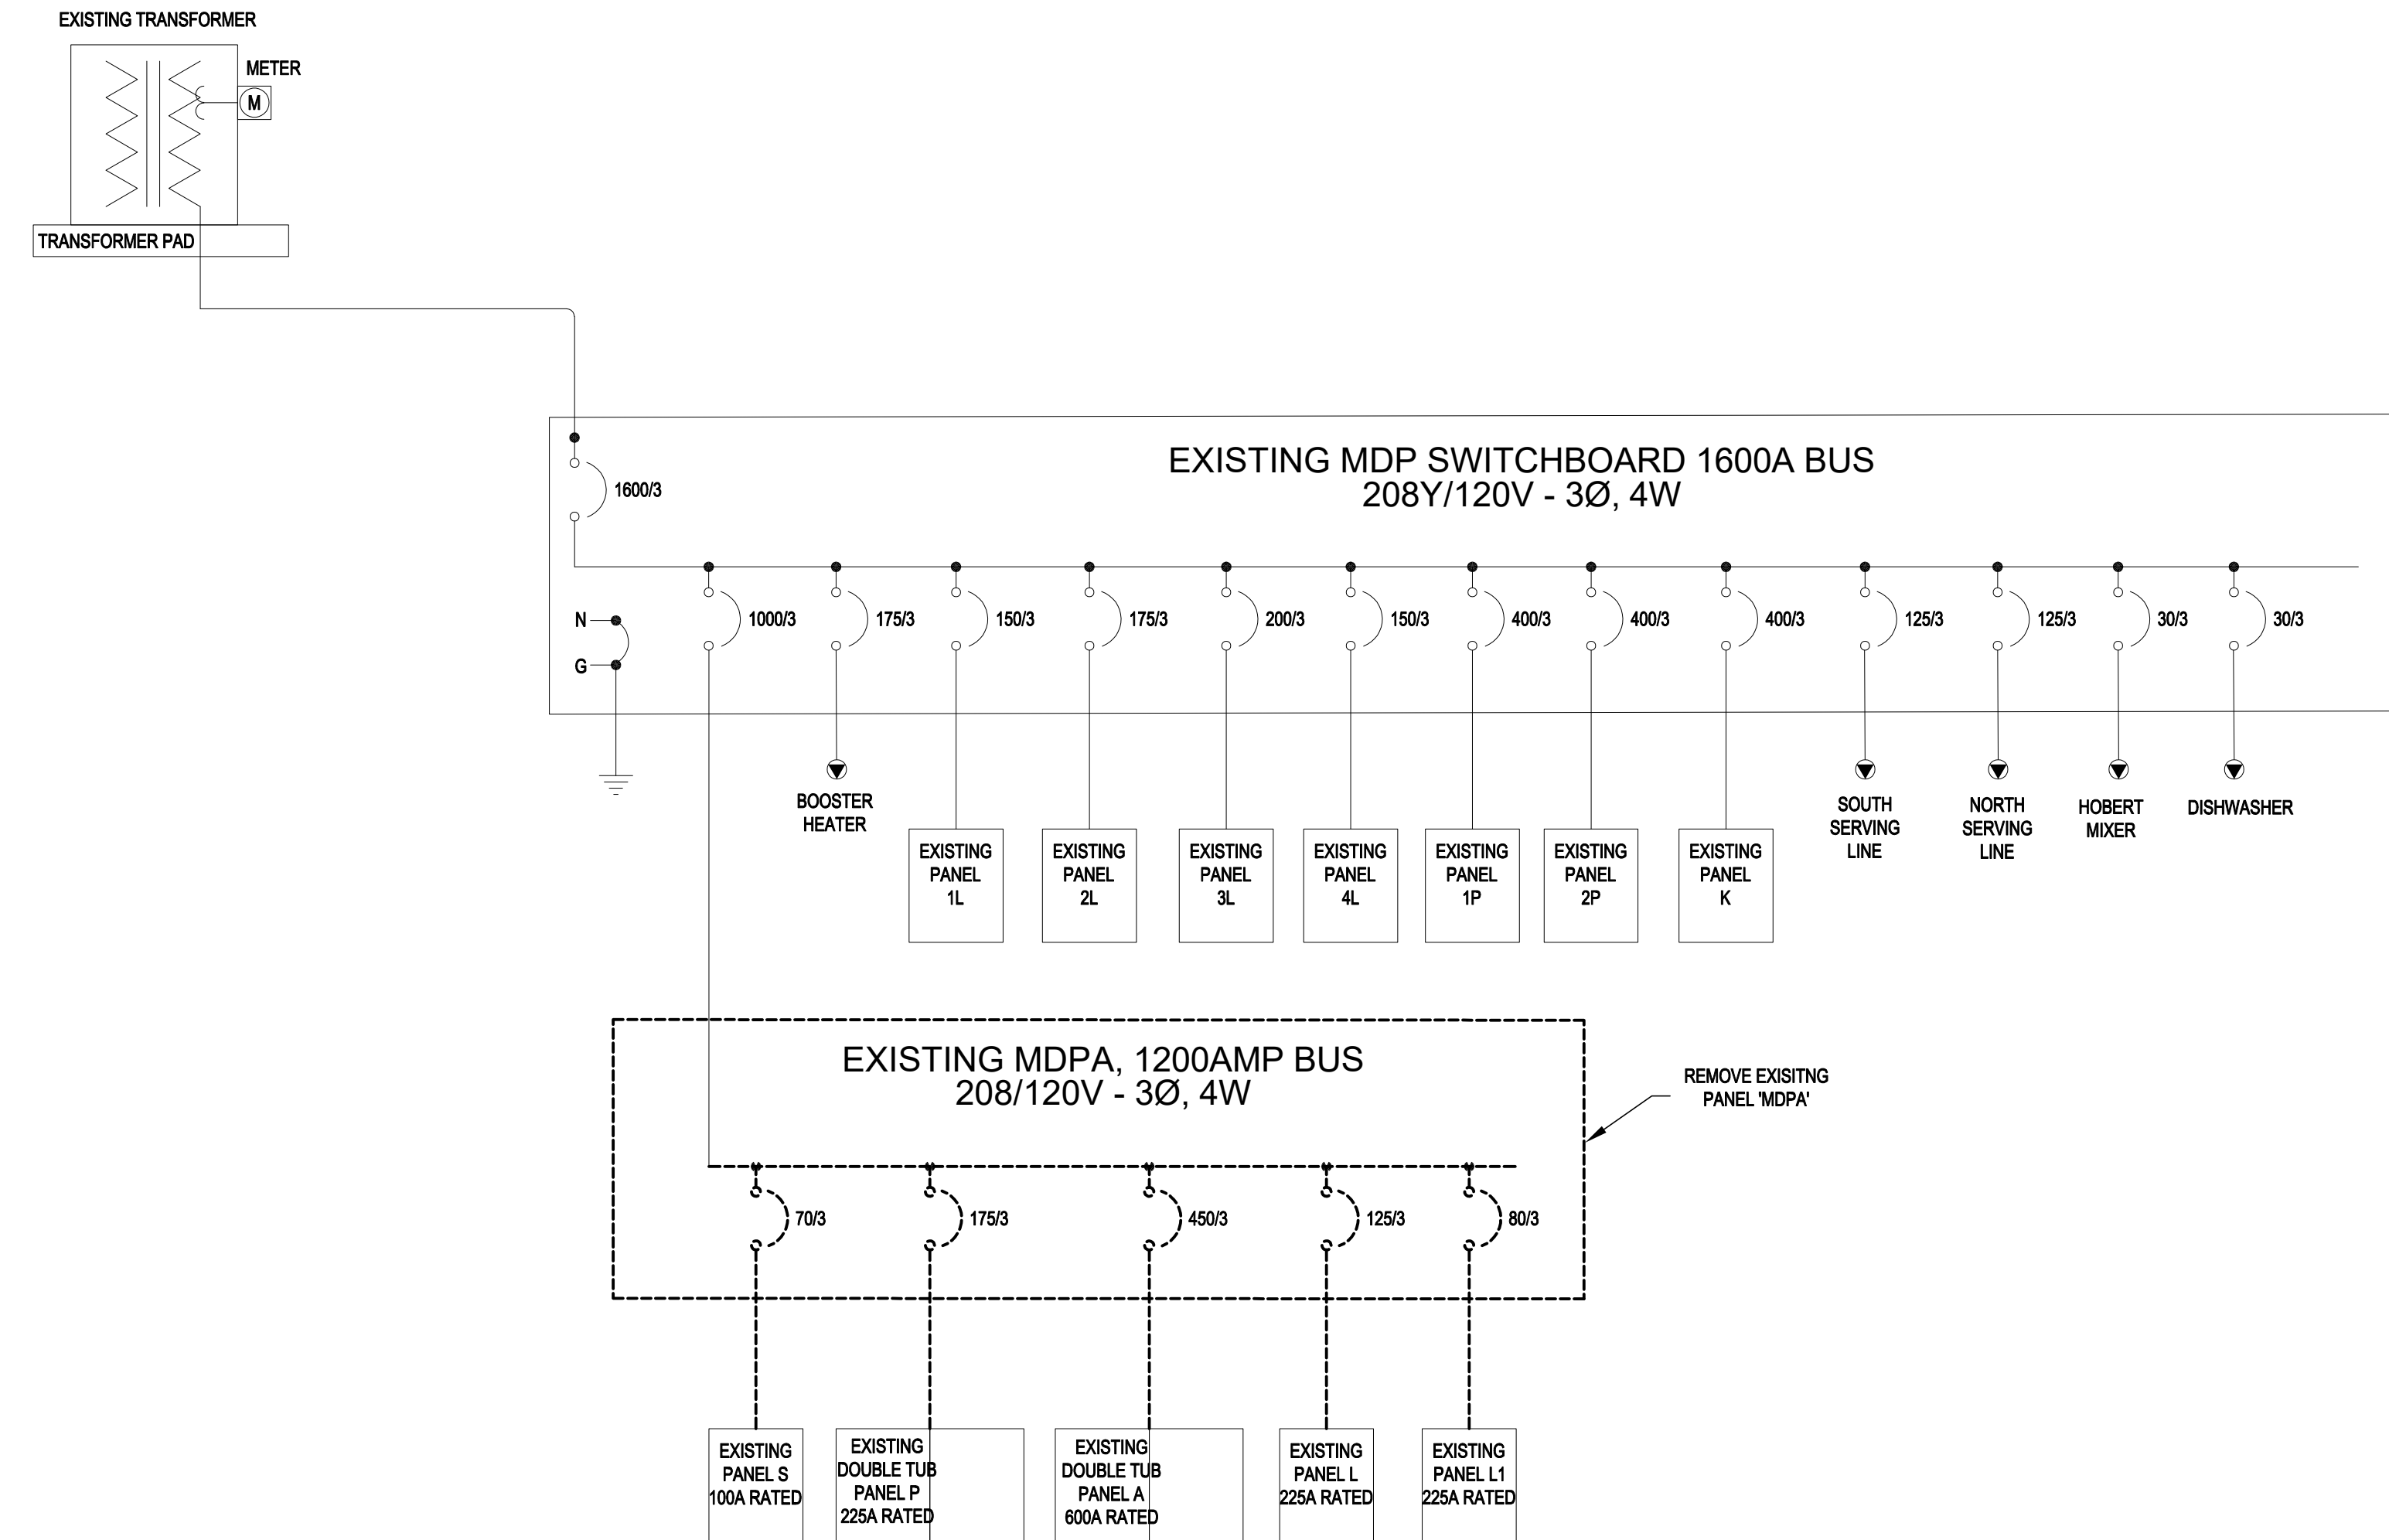

**1 ELECTRICAL ONE-LINE DIAGRAM - DEMOLITION**  
NO SCALE



**3 EXISTING ELECTRICAL ROOM**  
NO SCALE



**2 EXISTING MDPA**  
NO SCALE