


1

REFLECTED CEILING PLAN - AREA "B"  
1/8" = 1'-0"

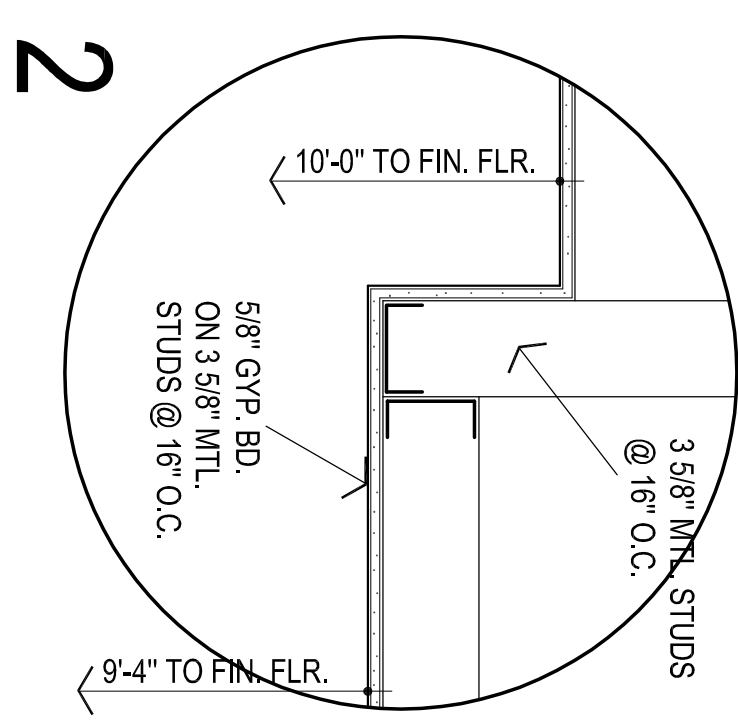


**LEGEND:**

- MECHANICAL OPENINGS
- ELECTRICAL FIXTURES
- CEILING MOUNTED SMOKE DETECTOR, RE-ELEC

**NOTES:**

1. REEFER MECHANICAL & ELECTRICAL FOR ANY ADDITIONAL CEILING MOUNTED FIXTURES
2. REFER TO SHEET A100 FOR LOCATIONS OF FIRE-RATED WALLS

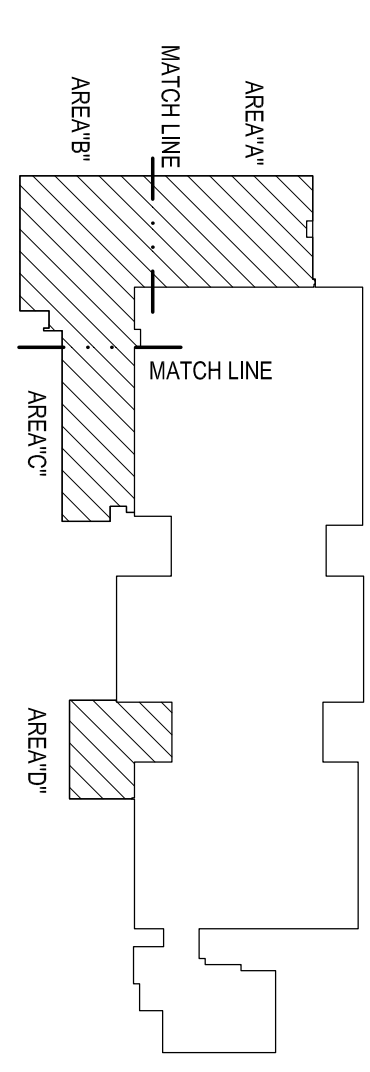

**KEY PLAN**


**AGP**  
the Abia Griffin  
Partnership L.L.C.  
201 N. BROADWAY  
SUITE 210  
MOORE, OK. 73160  
405.735.3477  
AGP@theAGP.net  
www.theAGP.net

CEDAR CREEK  
CIVIL  
KFC ENGINEERING  
STRUCTURAL  
SALAS ORBEN  
MECHANICAL/ELECTRICAL



CC  
drawn by  
MA  
checked by  
JULY 2023  
date  
revisions

MOORE PUBLIC SCHOOLS  
BOARD OF EDUCATION  
MOORE, OKLAHOMA

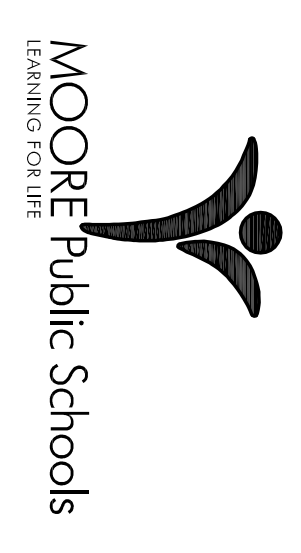

CLASSROOM ADDITION  
HIGHLAND WEST  
JUNIOR HIGH SCHOOL

Sheet No.

**A111**

OVERALL FLOOR PLAN  
OWNERSHIP USE OF DOCUMENTS:

AGP EXPRESSLY RESERVES ITS  
COPYRIGHT AND OTHER PROPERTY  
RIGHTS OF ALL PLANS AND DRAWINGS  
DESIGNED AND/OR PRODUCED BY  
AGP. ANY REPRODUCTION OF ANY  
PART OF THESE PLANS OR DRAWINGS  
WITHOUT THE EXPRESSED WRITTEN  
CONSENT OF AGP.