



GT  
drawn by  
TVO  
checked by  
JULY 2023  
date  
revisions

MOORE PUBLIC SCHOOLS  
BOARD OF EDUCATION  
MOORE, OKLAHOMA



CLASSROOM ADDITION  
HIGHLAND WEST  
JUNIOR HIGH SCHOOL

sheet no:

**E001**


OWNERSHIP USE OF DOCUMENTS:  
AGP EXPRESSLY RESERVES ITS  
COPYRIGHT AND OTHER PROPERTY  
RIGHTS OF ALL PLANS AND DRAWINGS  
DESIGNED AND/OR PRODUCED. PLANS  
AND DRAWINGS ARE NOT TO BE  
REPRODUCED IN ANY FORM OR MANNER  
WITHOUT THE EXPRESSED WRITTEN  
CONSENT OF AGP.

**GENERAL NOTES**



1. EC SHALL FIELD VERIFY EXISTING CONDITIONS PRIOR TO ALL WORK.
2. CONDUIT ROUTE SHOWN IS ONLY TO CONVEY DESIGN INTENT. EC SHALL DETERMINE FINAL ROUTING OF NEW CONDUIT AFTER FIELD VERIFYING EXISTING CONDITIONS.
3. EC SHALL PROVIDE PERMANENT LABELING OF SERVICE ENTRANCE LOCATIONS AT BOTH EXISTING AND NEW MDP.

**KEYED NOTES**

- ① APPROXIMATE ROUTING FOR UNDERGROUND FEED SERVING NEW PANEL 'L3' FROM NEW PANEL 'MDP'. COORDINATE FINAL ROUTING WITH ARCHITECT, CIVIL, AND OTHER TRADES PRIOR TO BEGINNING WORK. REFER TO SHEET 'E401' FOR ADDITIONAL INFORMATION.
- ② PROPOSED LOCATION OF NEW UTILITY TRANSFORMER FEEDING ADDITION. COORDINATE FINAL LOCATION WITH ARCHITECT, CIVIL, AND UTILITY PRIOR TO BEGINNING WORK.
- ③ APPROXIMATE LOCATION OF EXISTING UTILITY TRANSFORMER SERVING SCHOOL. SHOWN FOR REFERENCE ONLY.

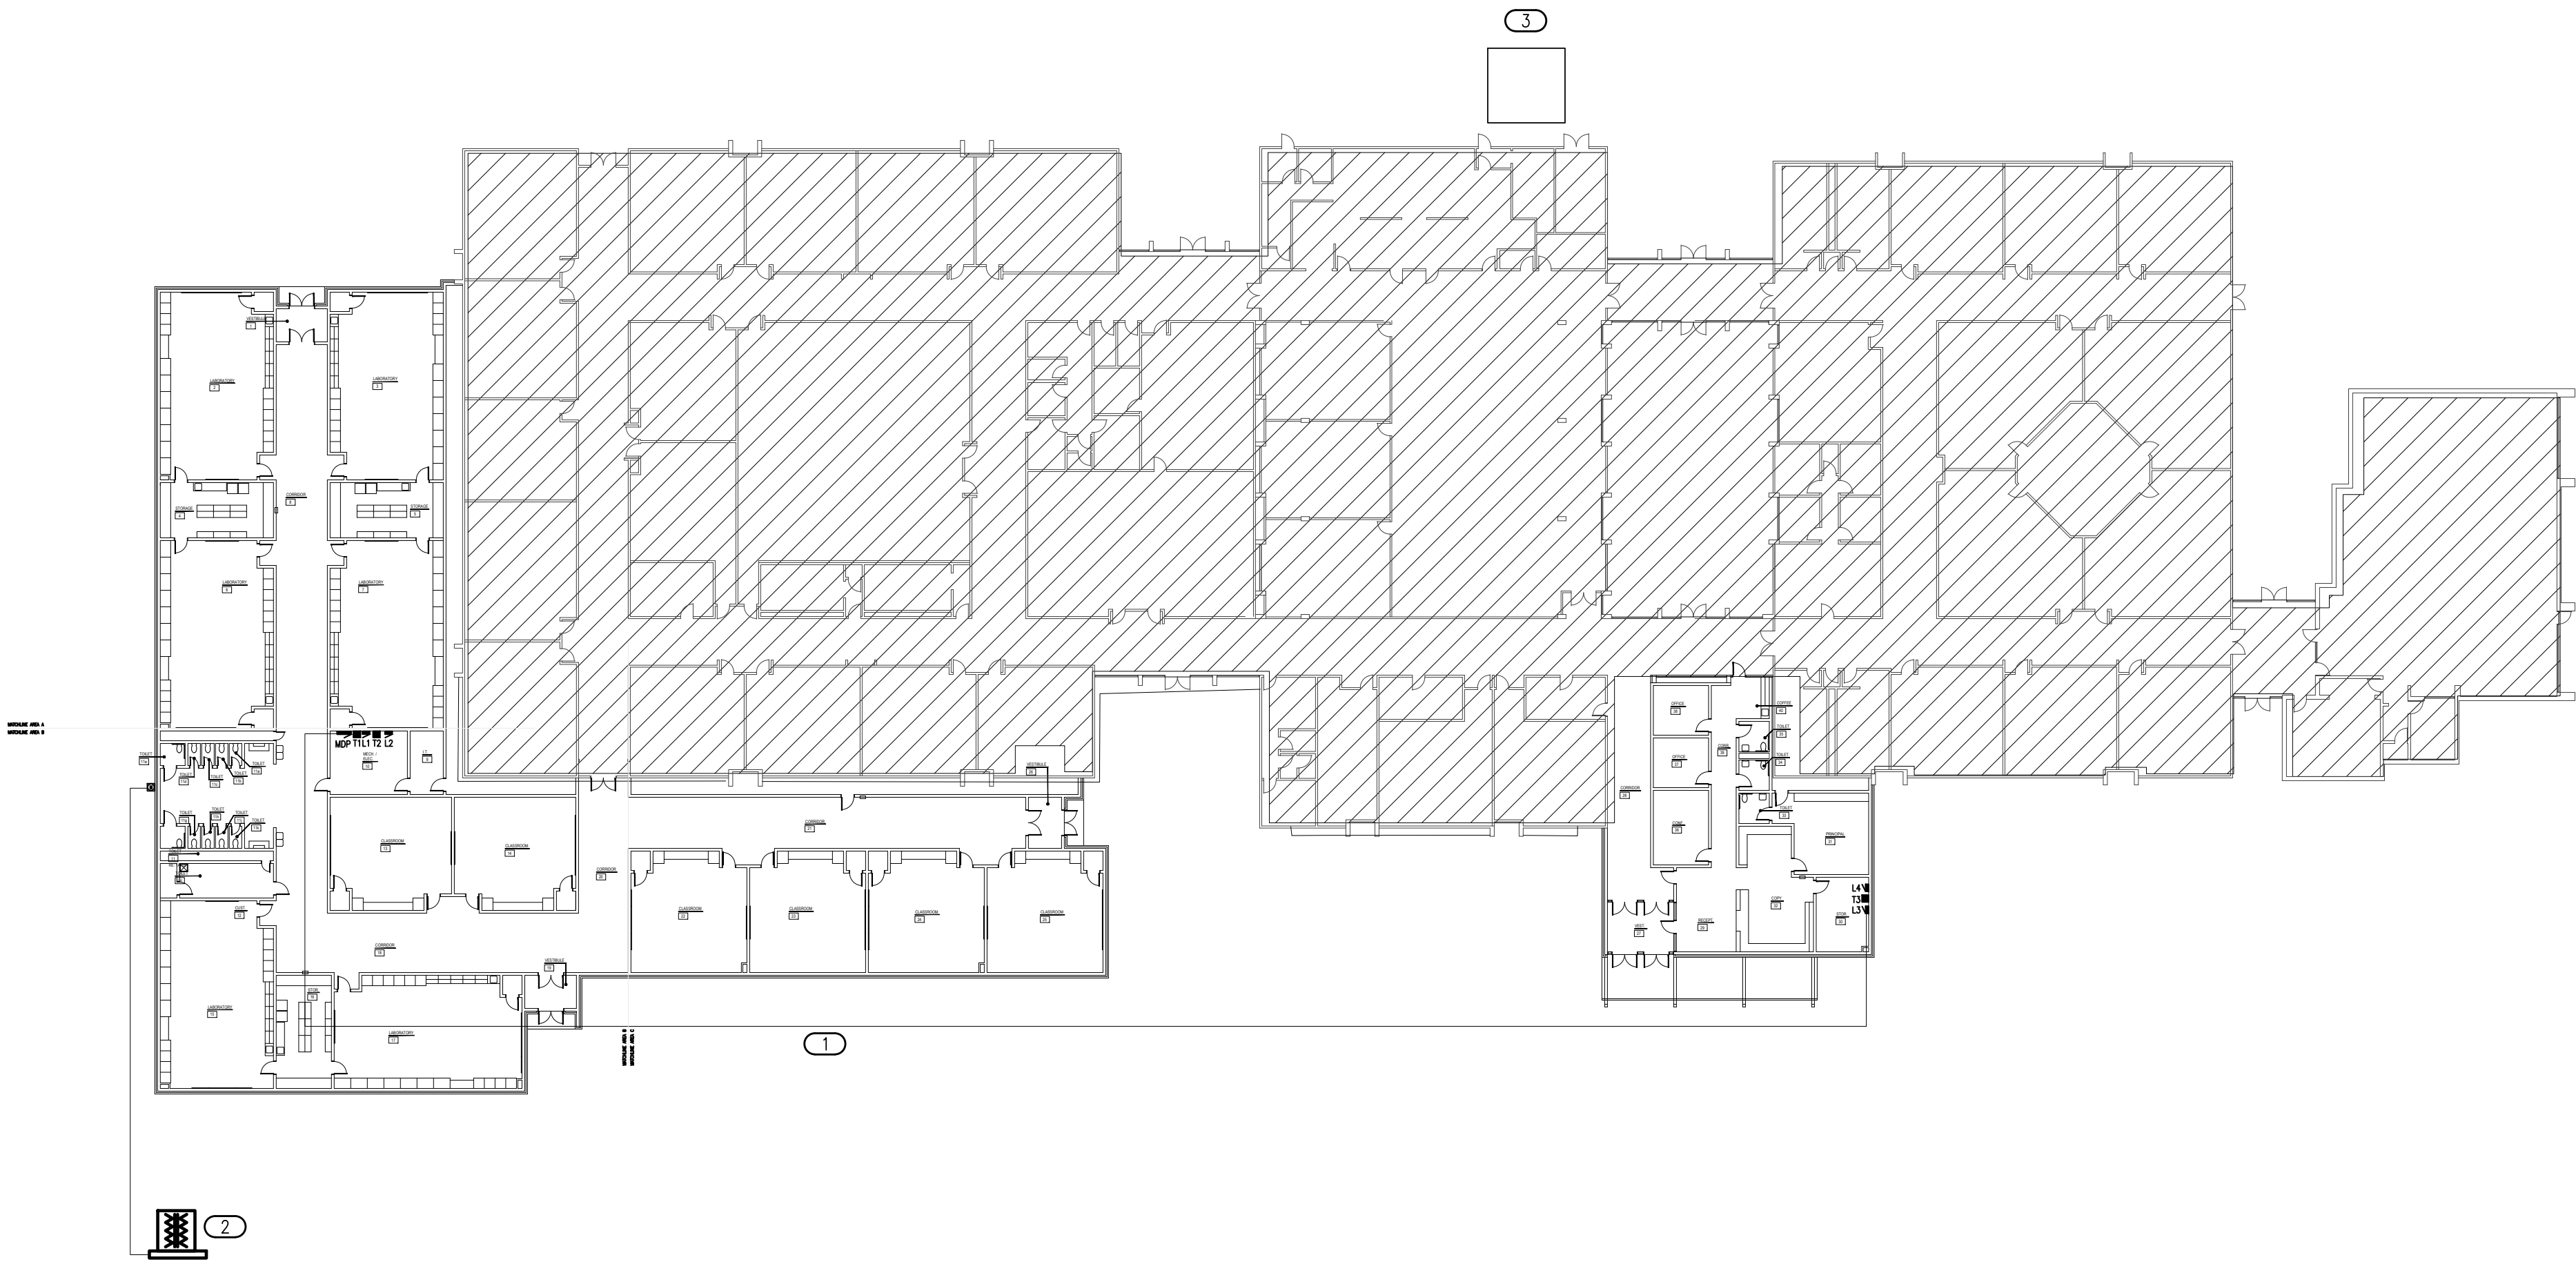

**1 ELECTRICAL SITE PLAN**  
SCALE: 1/32" = 1'-0"

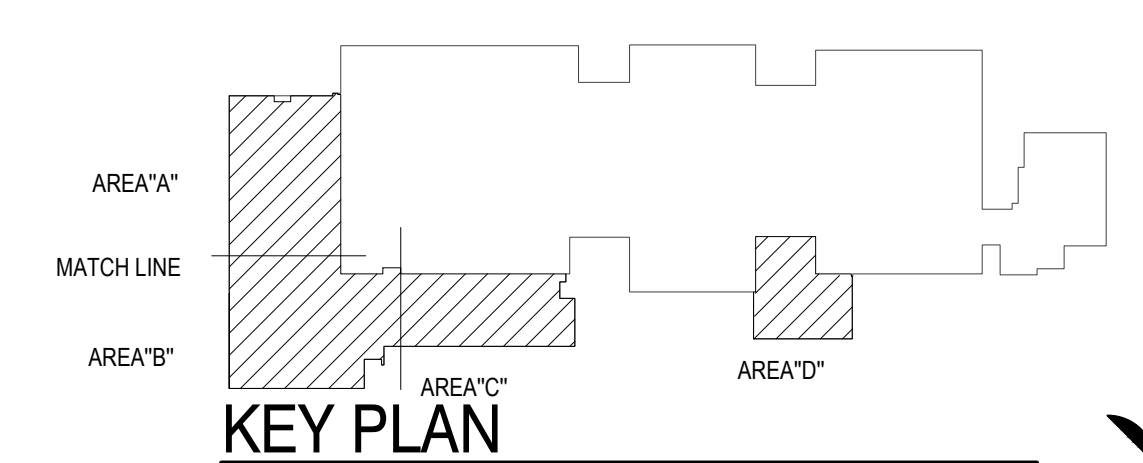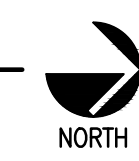

**Salas O'Brien**  
2600 Van Buren St., Suite 2635  
Norman, OK 73072  
Salas O'Brien Registration: CA# 7058  
Expiration Date: 6/30/2025  
Salas O'Brien Project Number: 2023-02792-00