



KP

drawn by

KP

checked by

JULY 2023

date

revisions

MOORE PUBLIC SCHOOLS  
BOARD OF EDUCATION  
MOORE, OKLAHOMA



CLASSROOM ADDITION  
HIGHLAND WEST  
JUNIOR HIGH SCHOOL

sheet no:


**F101**

**GENERAL NOTES**


1. COORDINATE WORK WITH ALL OTHER TRADES ON SITE.
2. FIELD VERIFY EXISTING CONDITIONS PRIOR TO COMMENCING WORK.
3. FIRE SEAL ALL PENETRATIONS THRU RATED STRUCTURES TO MAINTAIN FIRE RATINGS.
4. REFER TO NOTES ON SHEET F000.
5. COORDINATE INSPECTORS TEST DRAIN LOCATION WITH ALL TRADES ON SITE.

**KEYED NOTES**

- ① LIGHT HAZARD NEW ADDITION AREA. REFER TO ARCHITECTURAL PLANS FOR CEILING TYPE.
- ② ORDINARY HAZARD GROUP 1 - REFER TO ARCHITECTURAL PLANS FOR CEILING TYPE.
- ③ LIGHT HAZARD - IT ROOM - PROVIDE INTERMEDIATE TEMPERATURE TYPE HEADS. COORDINATE HEAD LOCATION WITH IT DEPARTMENT.

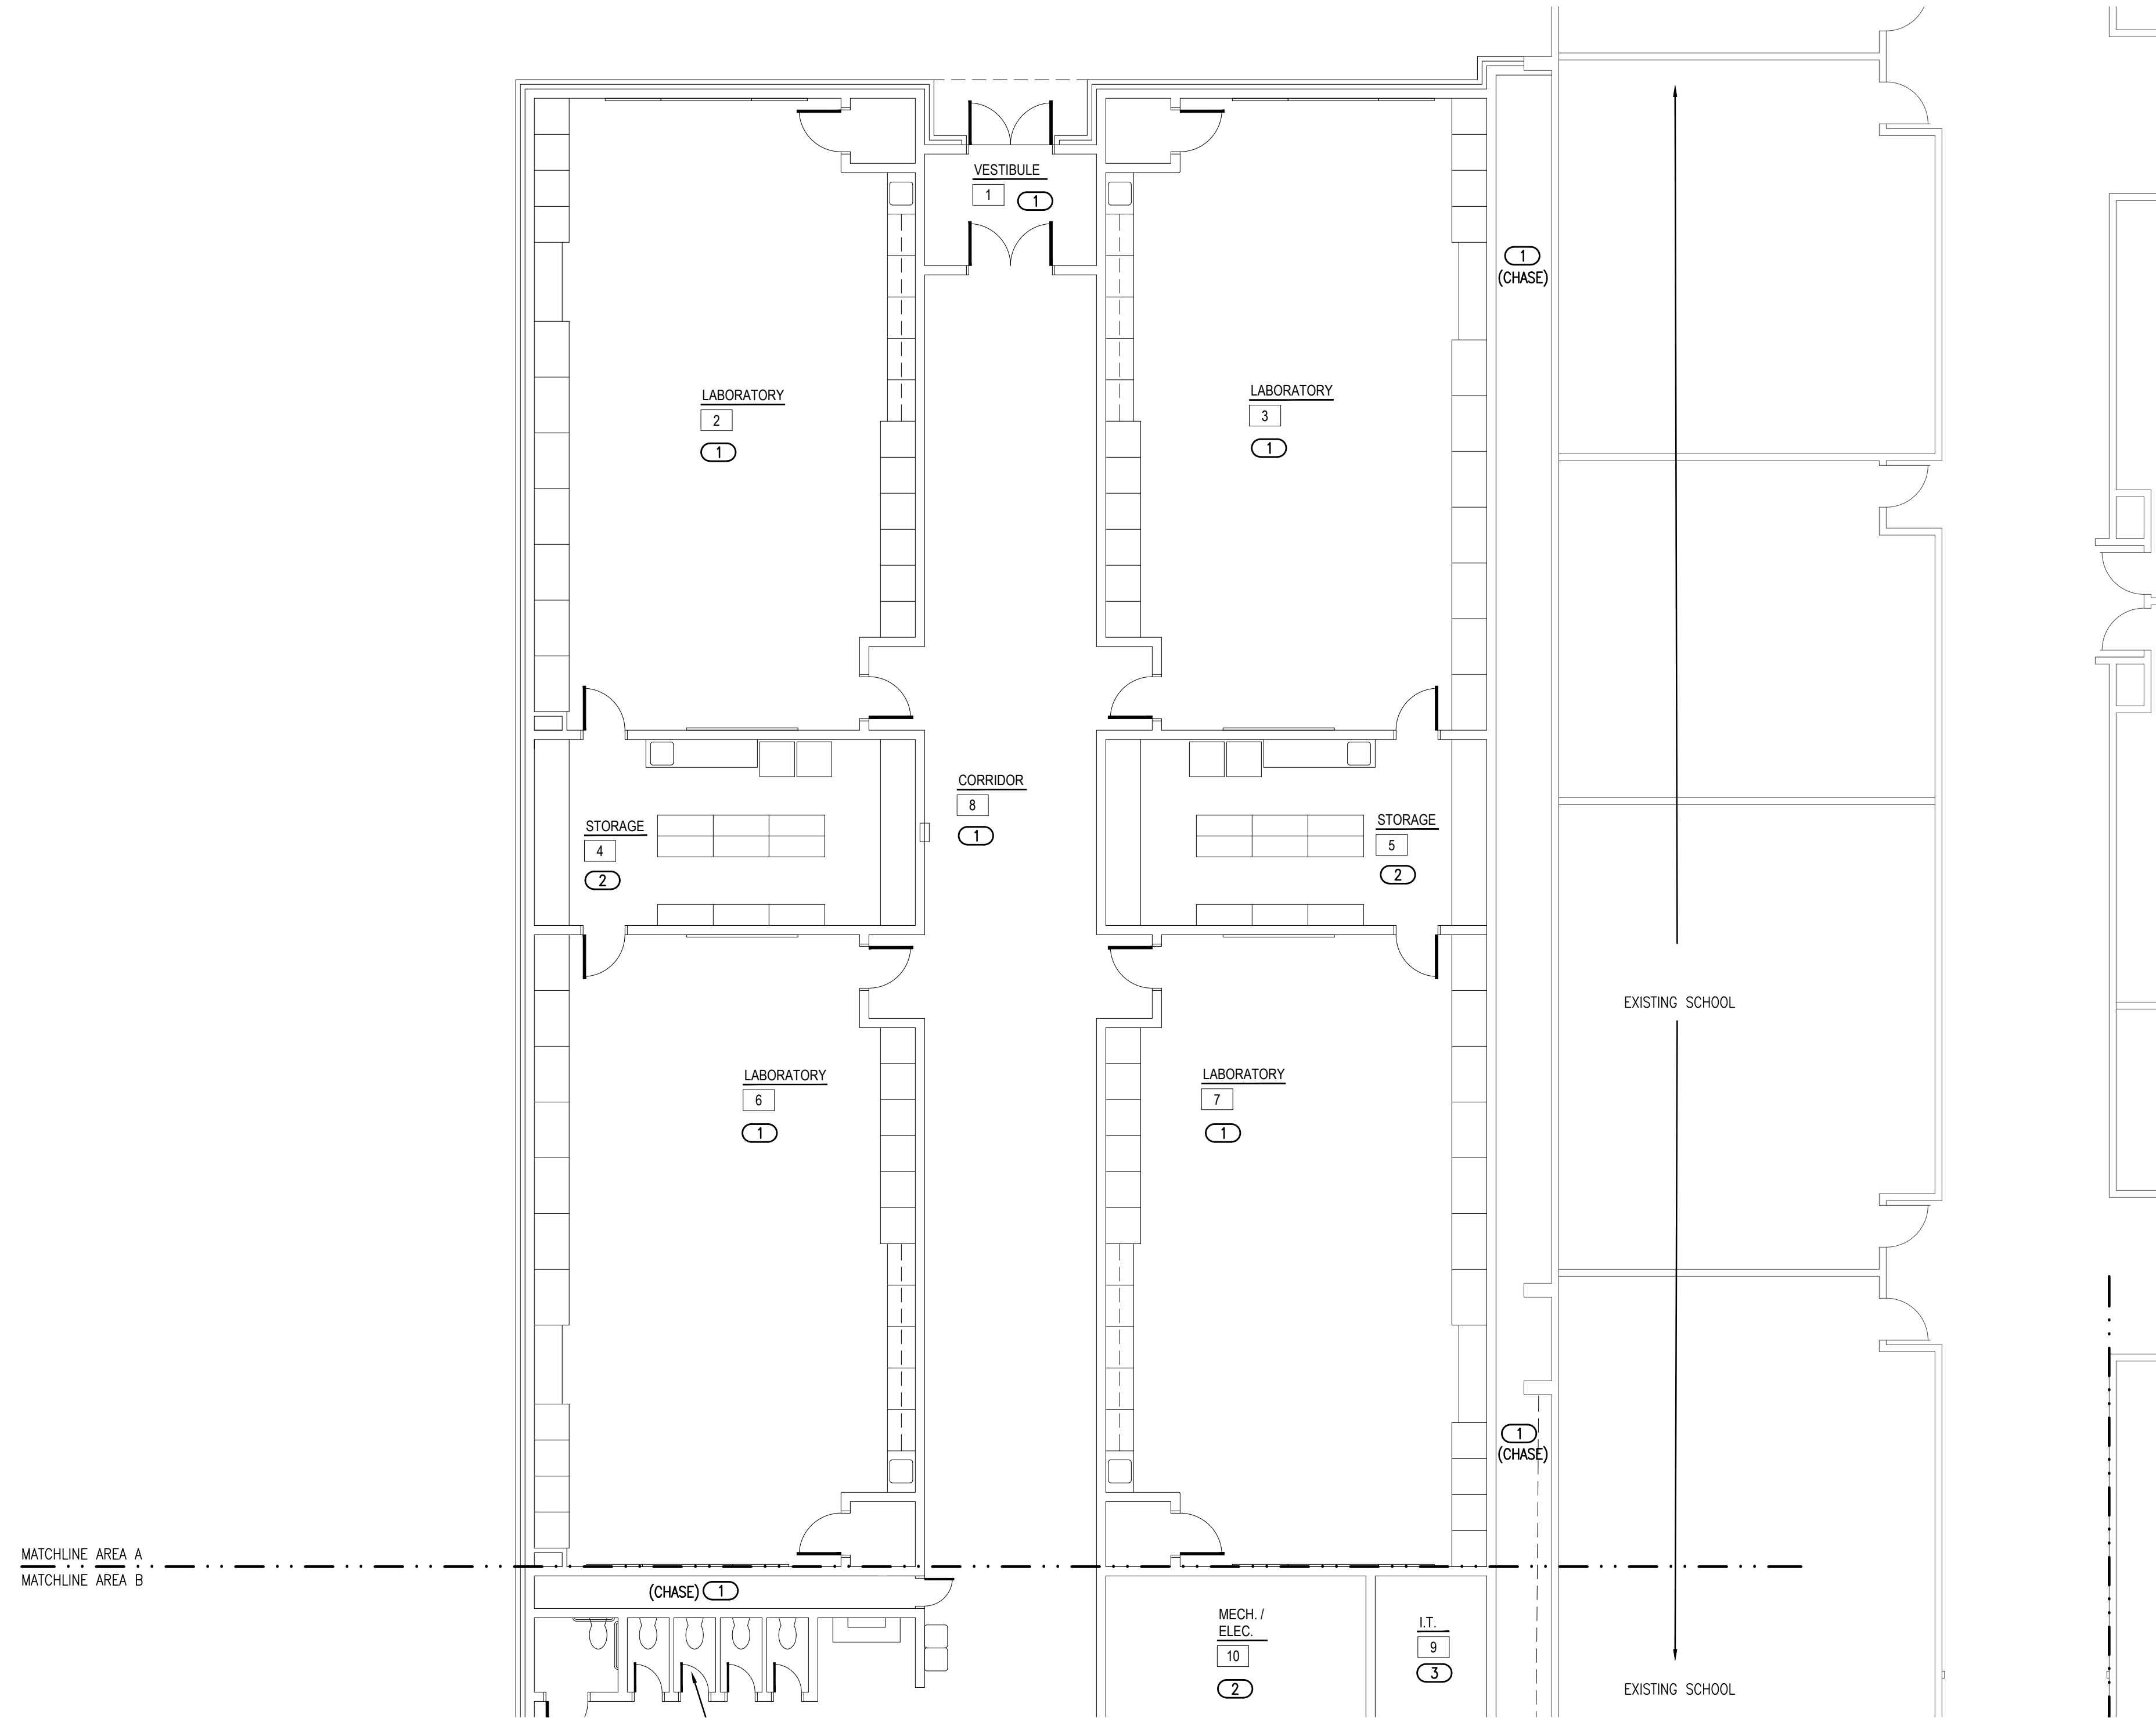

**1 FIRE PROTECTION PLAN - AREA A**  
SCALE: 1/8" = 1'-0"

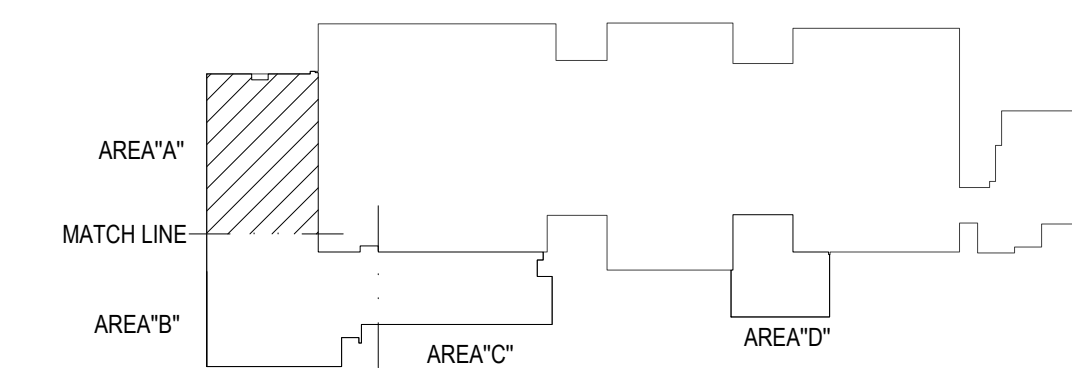

**KEY PLAN**

