

CEDAR CREEK

CIVIL

KFC ENGINEERING

STRUCTURAL

SALAS O'BRIEN

MECHANICAL / ELECTRICAL



KP

drawn by

KP

checked by

JULY 2023

date

revisions

MOORE PUBLIC SCHOOLS  
BOARD OF EDUCATION  
MOORE, OKLAHOMA



CLASSROOM ADDITION  
HIGHLAND WEST  
JUNIOR HIGH SCHOOL

sheet no:



# F102

### GENERAL NOTES

- COORDINATE WORK WITH ALL OTHER TRADES ON SITE.
- FIELD VERIFY EXISTING CONDITIONS PRIOR TO COMMENCING WORK.
- FIRE SEAL ALL PENETRATIONS THRU RATED STRUCTURES TO MAINTAIN FIRE RATING.
- REFER TO NOTES ON SHEET F000.
- COORDINATE INSPECTORS TEST DRAIN LOCATION WITH ALL TRADES ON SITE.

### KEYED NOTES

- LIGHT HAZARD NEW ADDITION AREA. REFER TO ARCHITECTURAL PLANS FOR CEILING TYPE.
- ORDINARY HAZARD GROUP 1 - REFER TO ARCHITECTURAL PLANS FOR CEILING TYPE.
- LIGHT HAZARD - IT ROOM - PROVIDE INTERMEDIATE TEMPERATURE TYPE HEADS. COORDINATE HEAD LOCATION WITH IT DEPARTMENT.
- NEW FIRE SPRINKLER RISER SEE DETAIL 1/F000. COORDINATE FIRE LINE INSTALLATION WITH PC OR SITE CONTRACTOR. FIELD VERIFY LOCATION.
- WALL MOUNTED SPRINKLER SYSTEM ALARM/STROBE. COORDINATE LOCATION WITH FIRE MARSHAL AND ALL OTHER TRADES.
- ROUTE 4" FIRE LINE TO WALL MOUNTED FDC. COORDINATE WITH GC FOR PIPE CHASE FOR FIRE LINE INSTALLATION. COORDINATE FDC LOCATION WITH FIRE MARSHAL.

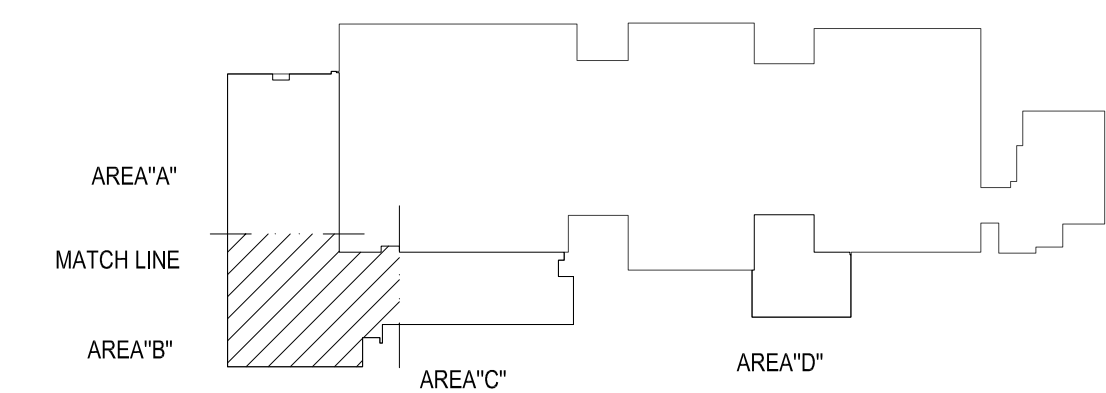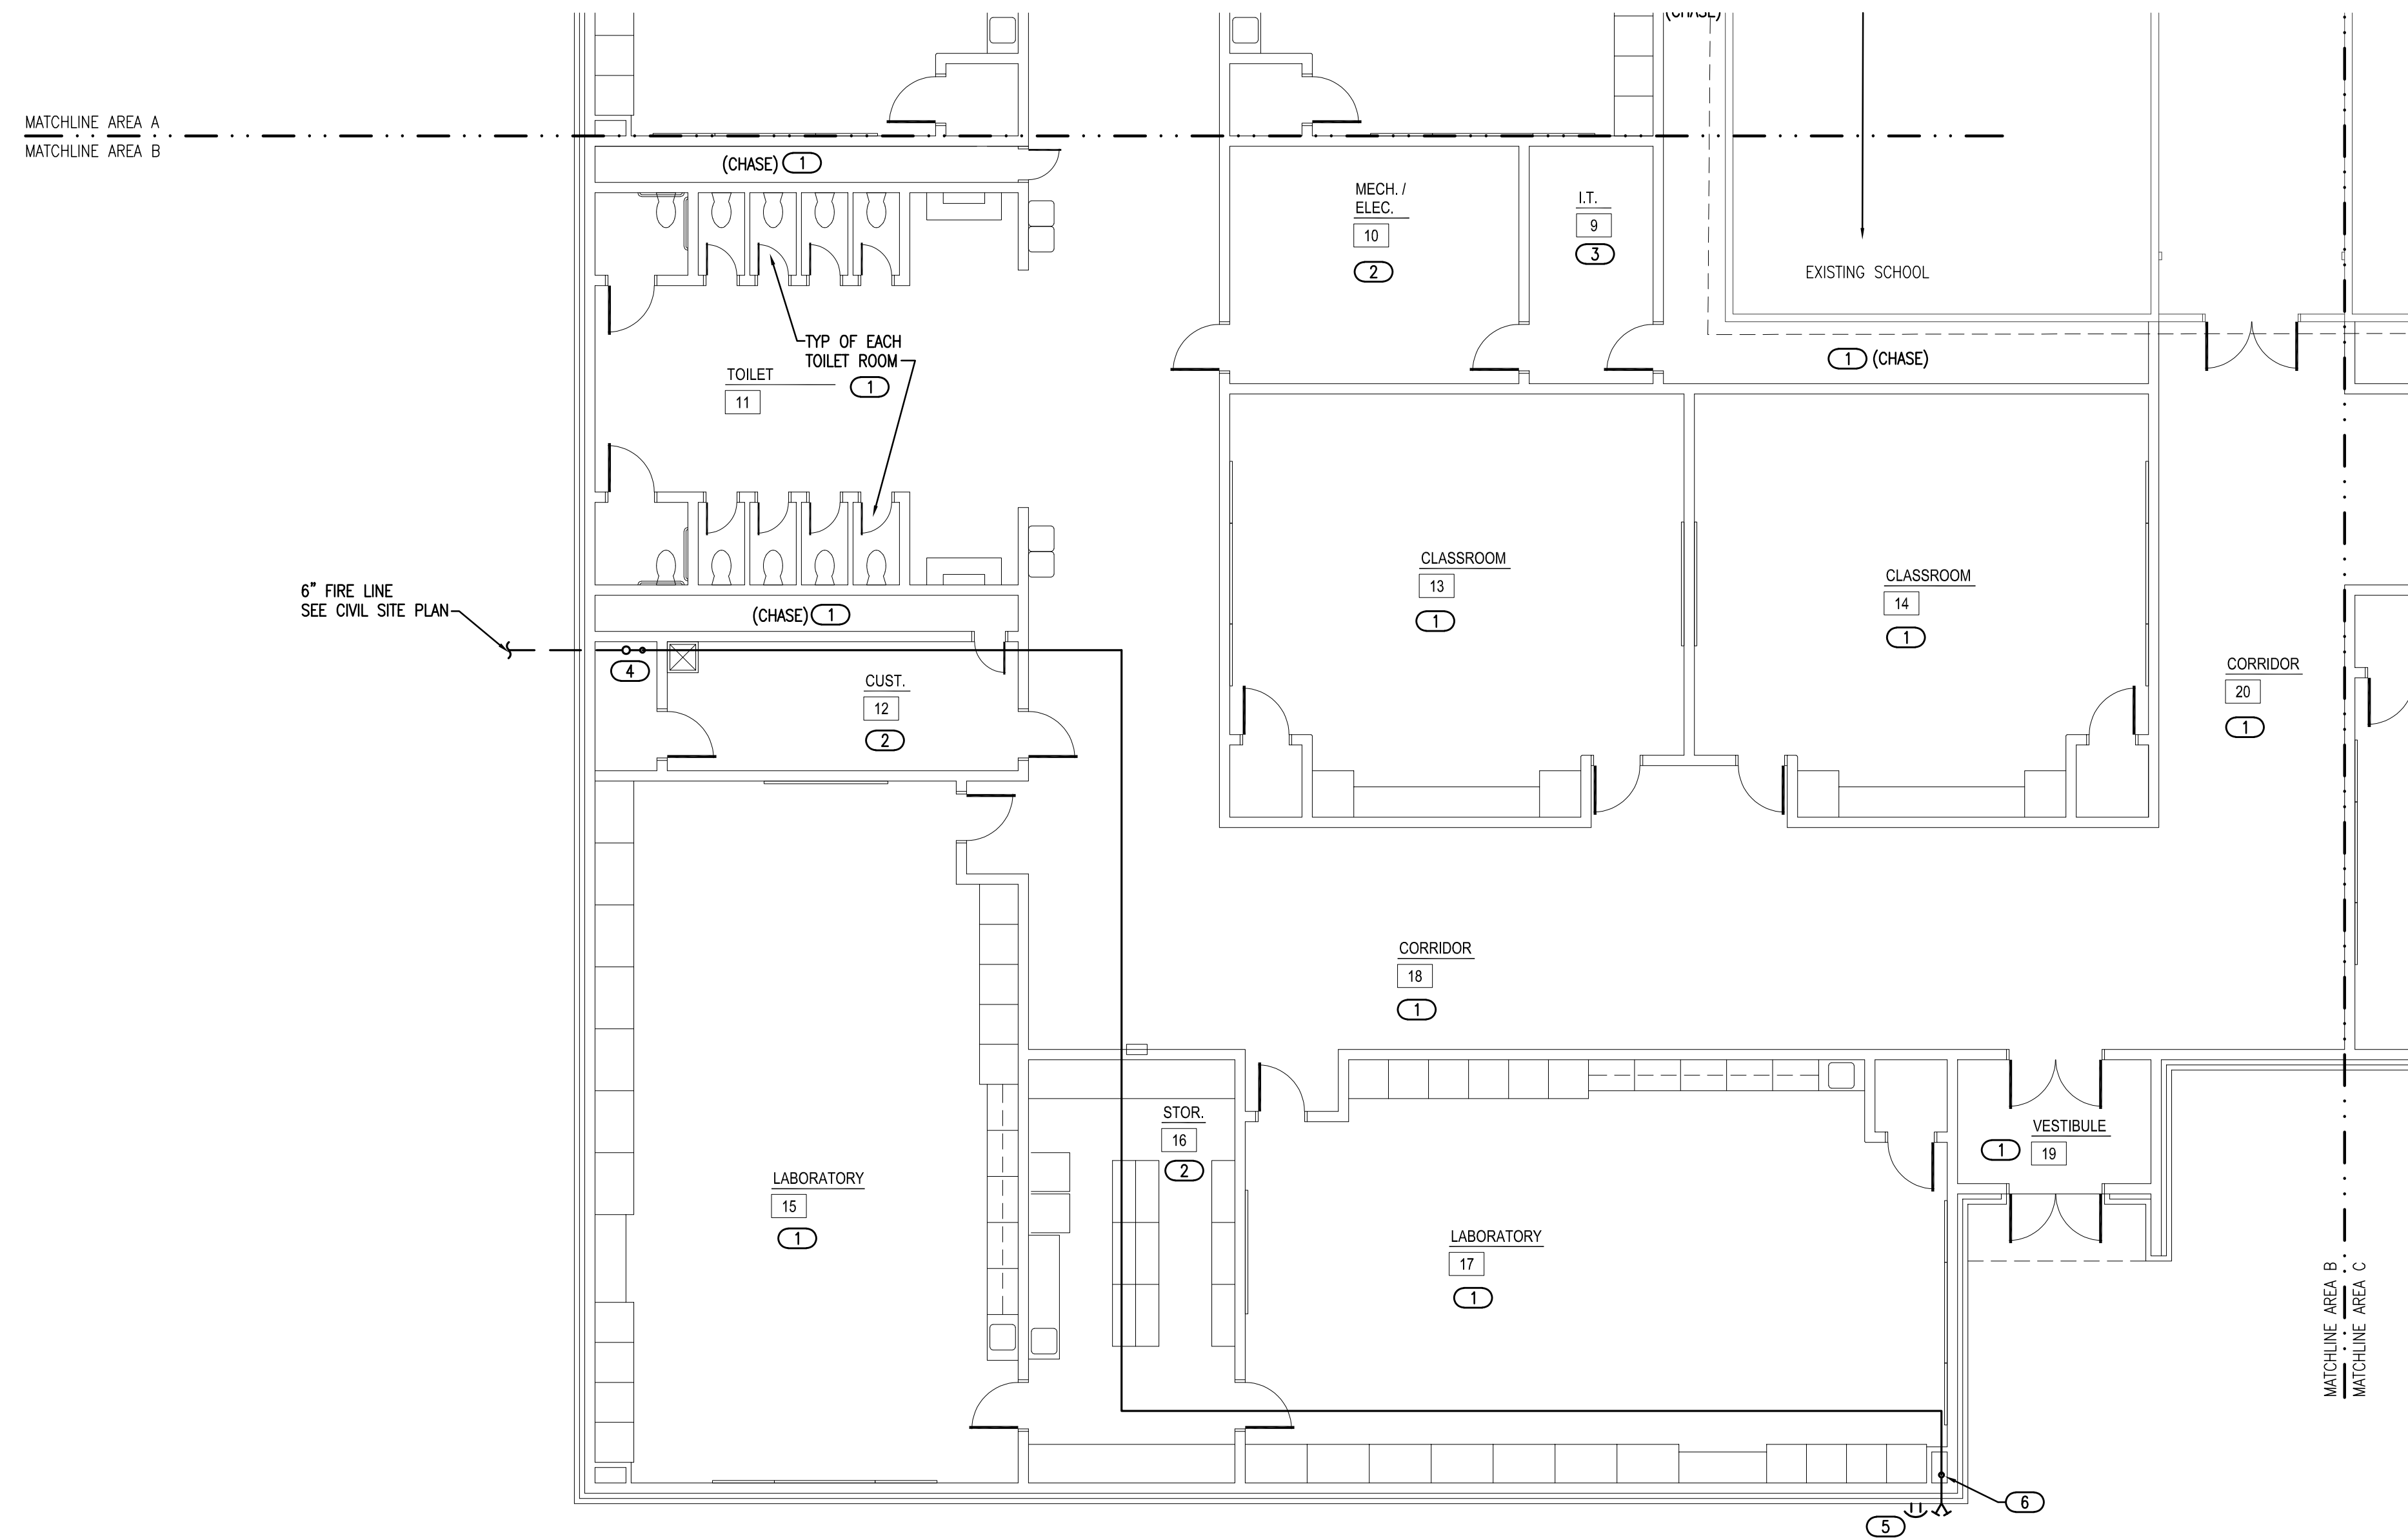

## 1 FIRE PROTECTION PLAN - AREA B

SCALE: 1/8" = 1'-0"



## KEY PLAN



OWNERSHIP USE OF DOCUMENTS:

AGP EXPRESSLY RESERVES ITS COPYRIGHT AND OTHER PROPERTY RIGHTS OF ALL PLANS AND DRAWINGS DESIGNED AND/OR PRODUCED. PLANS AND DRAWINGS ARE NOT TO BE REPRODUCED IN ANY FORM OR MANNER WITHOUT THE EXPRESSED WRITTEN CONSENT OF AGP.