



KP

drawn by

KP

checked by

JULY 2023

date

revisions


MOORE PUBLIC SCHOOLS  
BOARD OF EDUCATION  
MOORE, OKLAHOMA



CLASSROOM ADDITION  
HIGHLAND WEST  
JUNIOR HIGH SCHOOL


sheet no:

## F104

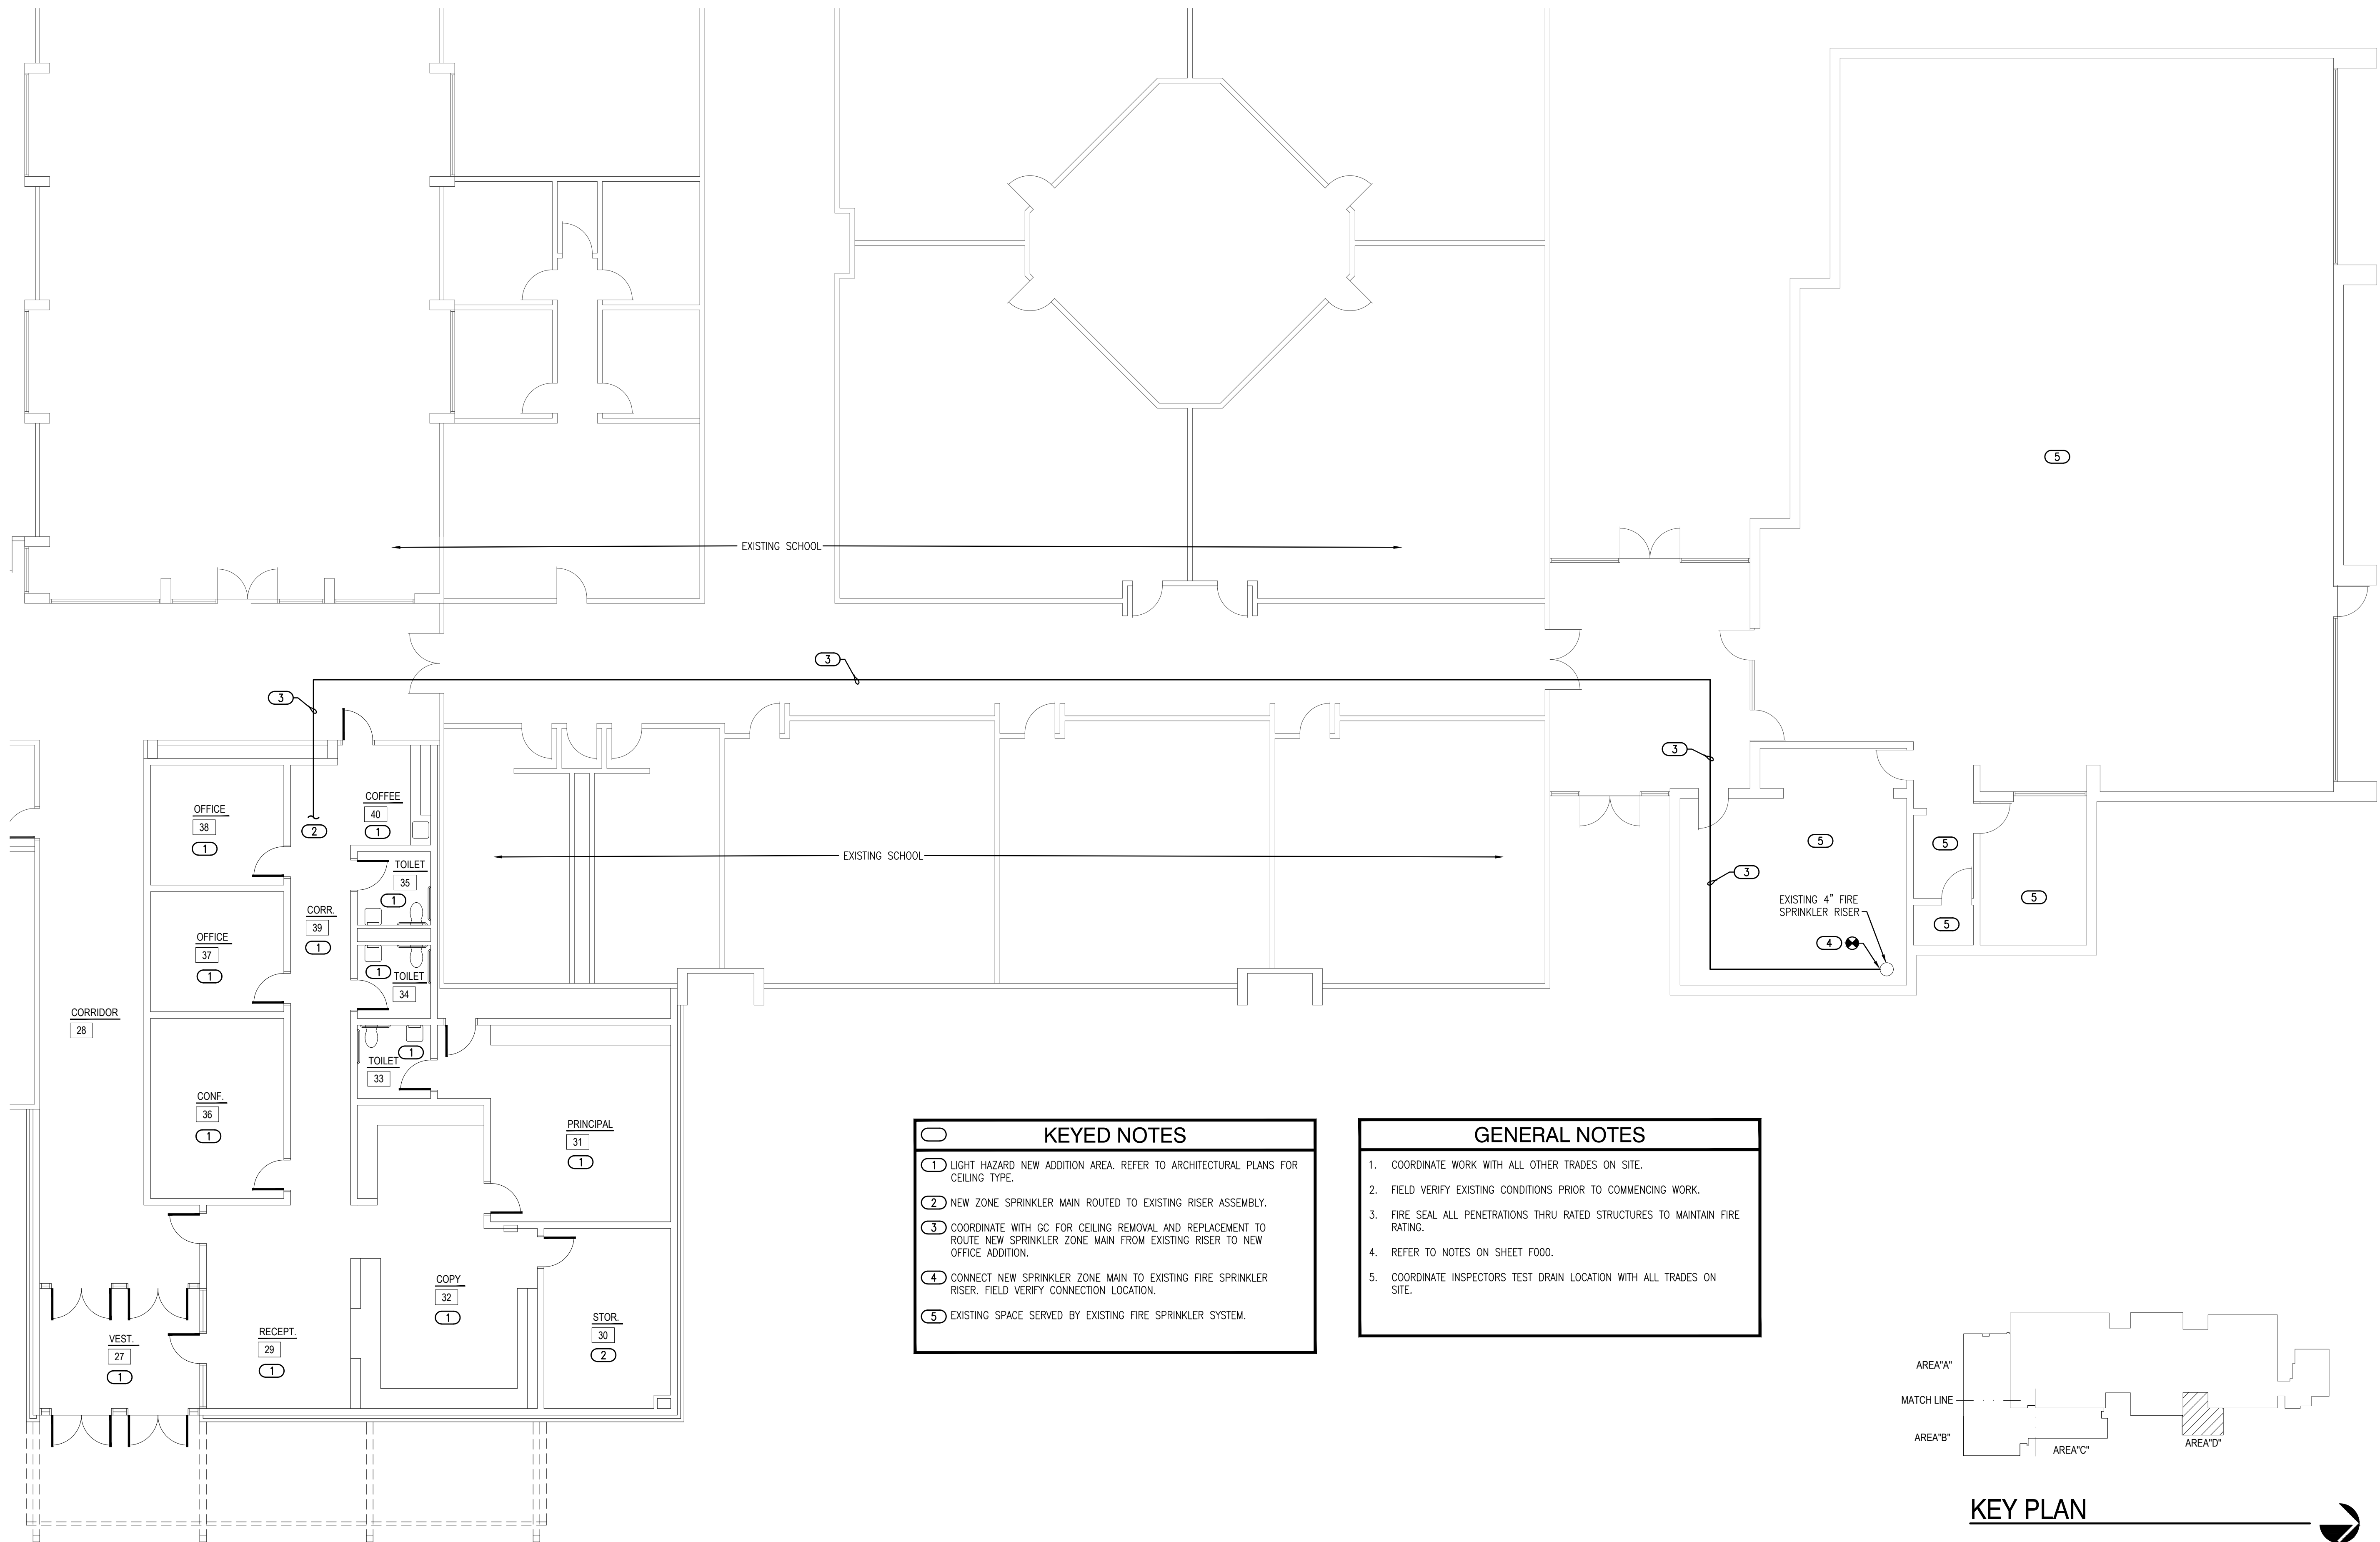

KEYED NOTES	
1	LIGHT HAZARD NEW ADDITION AREA. REFER TO ARCHITECTURAL PLANS FOR CEILING TYPE.
2	NEW ZONE SPRINKLER MAIN ROUTED TO EXISTING RISER ASSEMBLY.
3	COORDINATE WITH GC FOR CEILING REMOVAL AND REPLACEMENT TO ROUTE NEW SPRINKLER ZONE MAIN FROM EXISTING RISER TO NEW OFFICE ADDITION.
4	CONNECT NEW SPRINKLER ZONE MAIN TO EXISTING FIRE SPRINKLER RISER. FIELD VERIFY CONNECTION LOCATION.
5	EXISTING SPACE SERVED BY EXISTING FIRE SPRINKLER SYSTEM.

GENERAL NOTES	
1.	COORDINATE WORK WITH ALL OTHER TRADES ON SITE.
2.	FIELD VERIFY EXISTING CONDITIONS PRIOR TO COMMENCING WORK.
3.	FIRE SEAL ALL PENETRATIONS THRU RATED STRUCTURES TO MAINTAIN FIRE RATING.
4.	REFER TO NOTES ON SHEET F000.
5.	COORDINATE INSPECTORS TEST DRAIN LOCATION WITH ALL TRADES ON SITE.

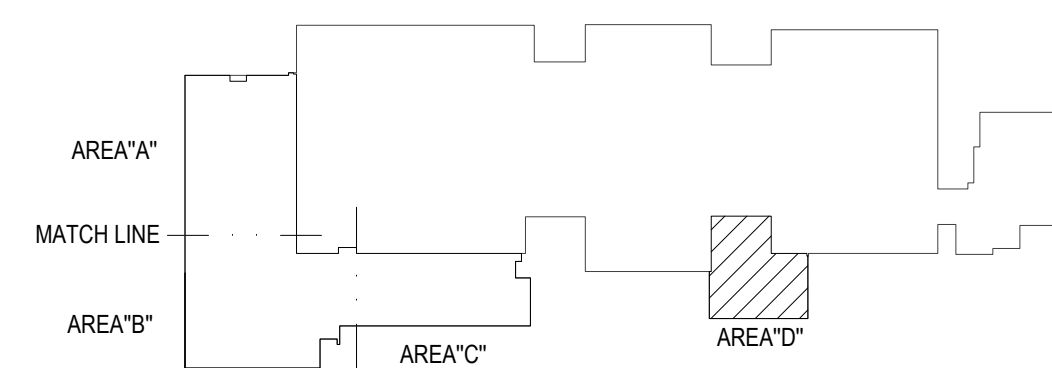

KEY PLAN

