

NY

drawn by

NY

checked by

JULY 2023

date

revisions

MOORE PUBLIC SCHOOLS
BOARD OF EDUCATION
MOORE, OKLAHOMA



CLASSROOM ADDITION
HIGHLAND WEST
JUNIOR HIGH SCHOOL

sheet no:

T101

OWNERSHIP USE OF DOCUMENTS:

AGP EXPRESSLY RESERVES ITS COPYRIGHT AND OTHER PROPERTY RIGHTS OF ALL PLANS AND DRAWINGS DESIGNED AND/OR PRODUCED. PLANS AND DRAWINGS ARE NOT TO BE REPRODUCED IN ANY FORM OR MANNER WITHOUT THE EXPRESSED WRITTEN CONSENT OF AGP.

SECURITY GENERAL NOTES

A. REPLACE EXISTING OLD GYM DSC 4020 SECURITY ALARM MAIN CONTROL WITH A DSC 4204 POWER SUPPLY & DSC 4116 ZONE EXPANDER AND CONNECT TO THE MAIN BUILDING DSC 4020 SECURITY ALARM MAIN CONTROL PANEL VIA (2) 4 CONDUCTOR 16 GAUGE NON-SHIELDED CABLES. USE EXISTING EMPTY 2 INCH CONDUITS BETWEEN THE OLD GYM & MAIN BUILDING. PROGRAM SECURITY SYSTEM AS NEEDED TO MAKE ONE WORKING SECURITY ALARM SYSTEM FOR THE ENTIRE CAMPUS. PROGRAM A SEPARATE PARTITION FOR THE OLD GYM.

FIRE GENERAL NOTES

A. REPLACE EXISTING OLD GYM & FIELDHOUSE SILENT KNIGHT 5820XL FIRE ALARM MAIN CONTROL WITH A SILENT KNIGHT 5895XL POWER SUPPLY AND CONNECT TO THE MAIN BUILDING FIRE ALARM MAIN CONTROL PANEL VIA (2) 4 CONDUCTOR 16 GAUGE NON-SHIELDED CABLES. USE EXISTING EMPTY 2 INCH CONDUITS BETWEEN THE OLD GYM & MAIN BUILDING. PROGRAM FIRE SYSTEM AS NEEDED TO MAKE ONE WORKING FIRE ALARM SYSTEM FOR THE ENTIRE CAMPUS. CONTRACTOR TO PROVIDE AND INSTALL ADDITIONAL SMOKE DETECTORS IN OLD GYMNASIUM BASKETBALL COURT

B. PROJECT SCOPE INCLUDES A FULL FIRE ALARM SYSTEM REPLACEMENT AND UPGRADE FOR THE JUNIOR HIGH SCHOOL MAIN CAMPUS. REFERENCE SHEET SPECIFICATION ON SHEET T603 FOR ADDITIONAL INFORMATION.


FIRE ALARM UPGRADE NOTES

JUNIOR HIGH SCHOOL FIRE ALARM SYSTEM, FACP, DEVICES AND WIRING IS TO BE REPLACED AND UPGRADED IN ACCORDANCE WITH SHEET SPECIFICATIONS.

FIRE ALARM CONTRACTOR TO PROVIDE AND INSTALL ADDITIONAL STROBE DEVICES IN ALL CLASSROOMS.

KEYED NOTES

- ① EXISTING LOCATION OF INTERCOM HEAD END UNIT.
- ② EXISTING LOCATION OF FIRE ALARM MAIN CONTROL PANEL.
- ③ EXISTING SECURITY ALARM MAIN PANEL.
- ④ EXISTING LOCATION OF MDF.

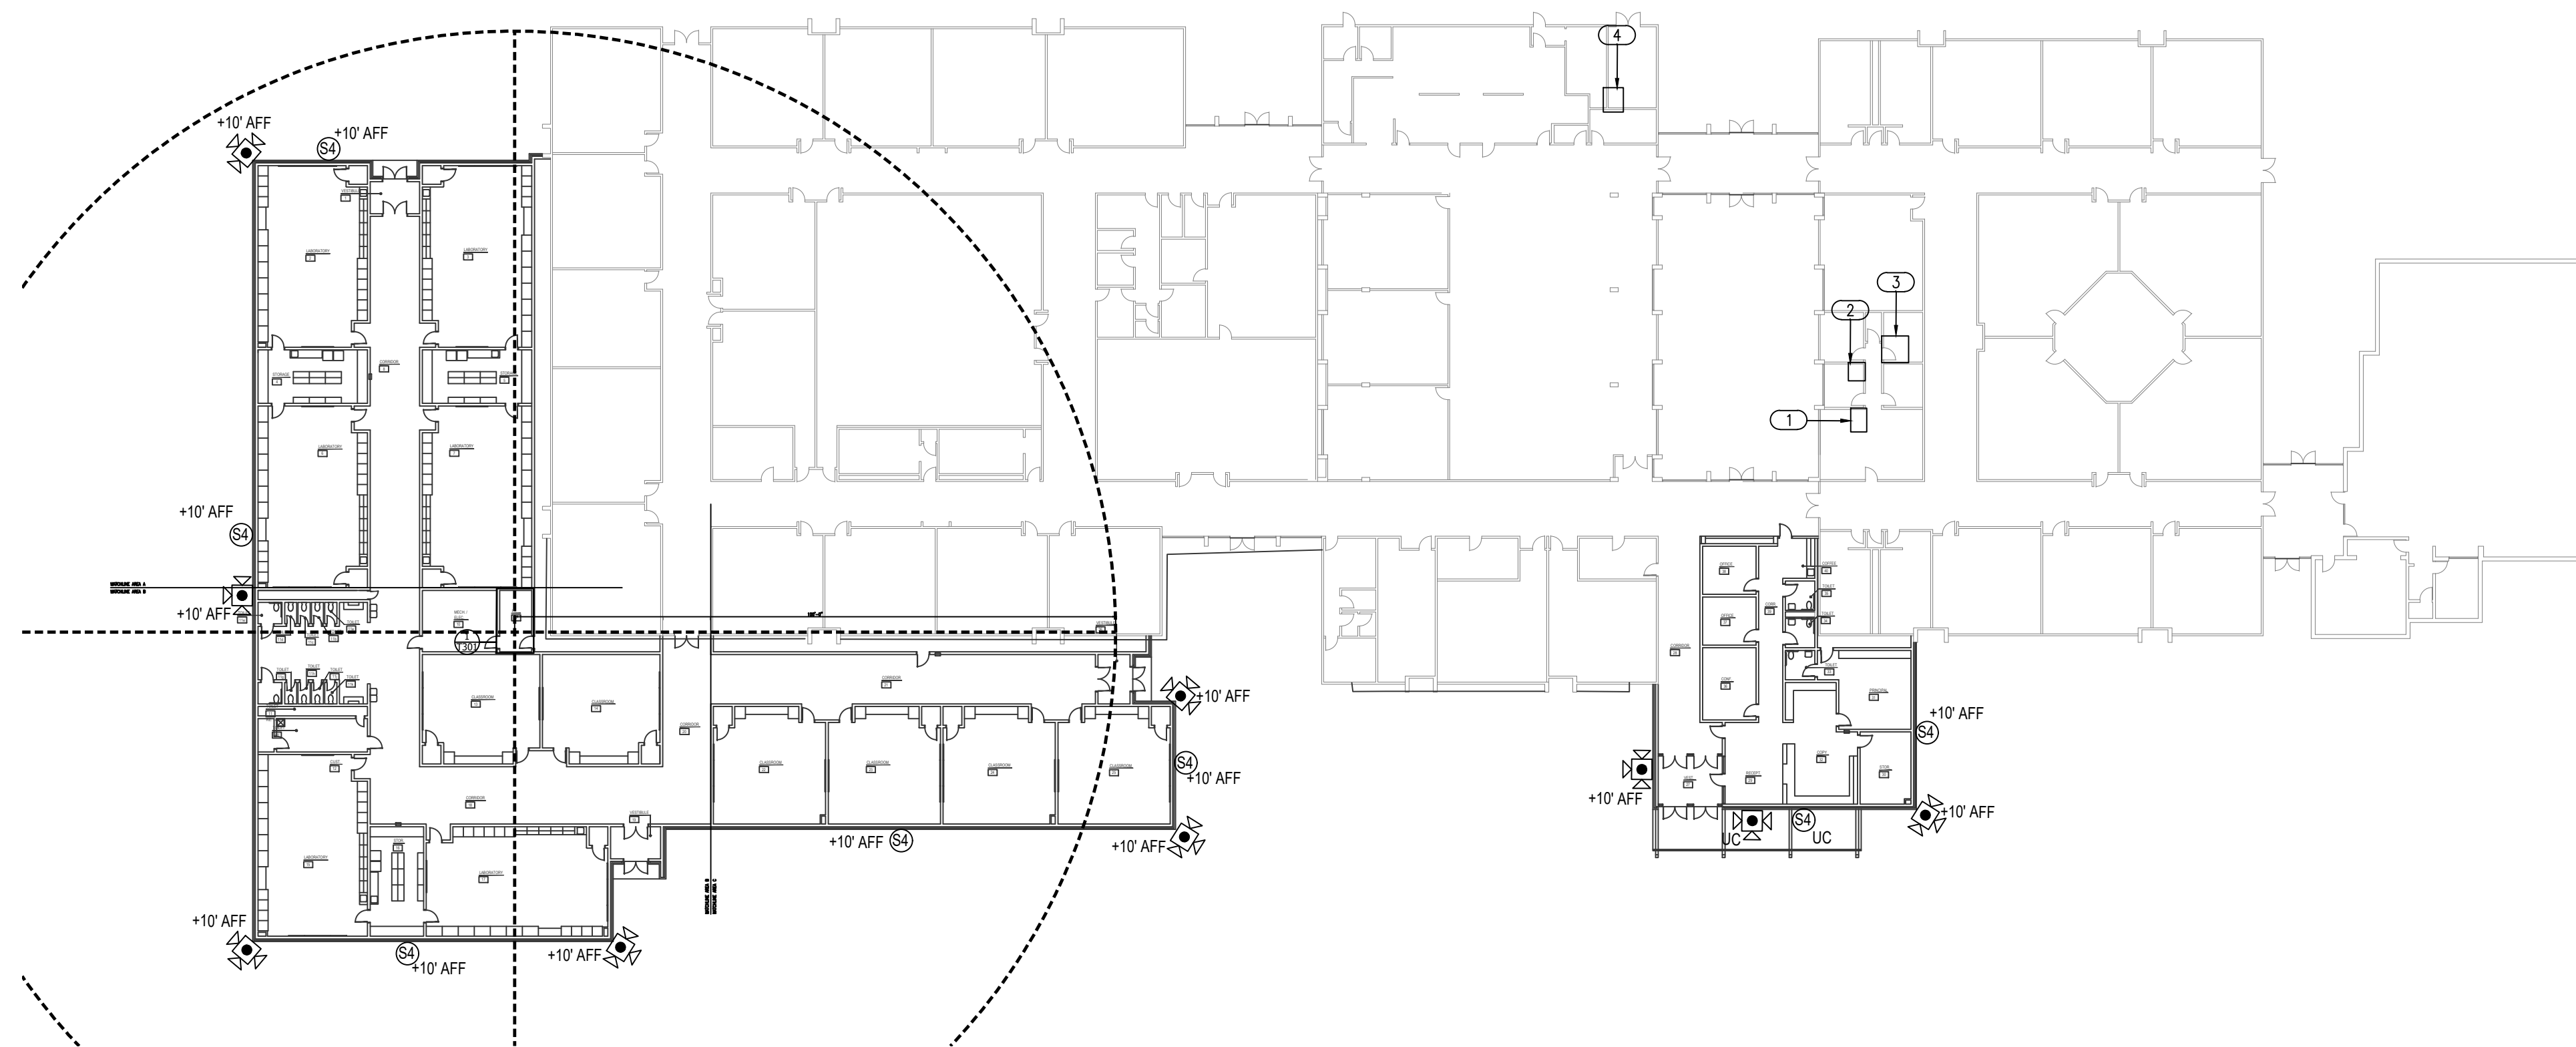


1 TECHNOLOGY SITE PLAN - ENLARGED

SCALE: 1/32" = 1'-0"



NORTH

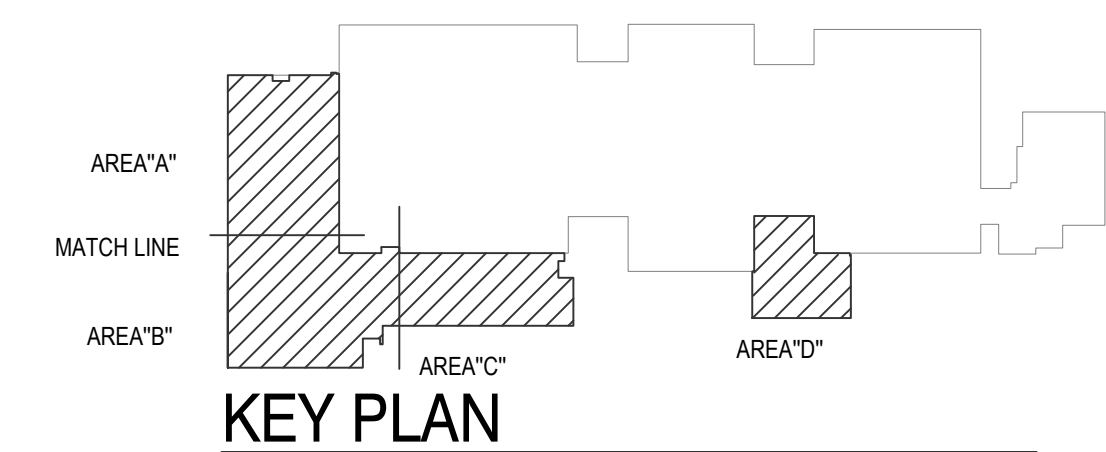

KEY PLAN



NORTH

Salas O'Brien
2600 Van Buren St., Suite 2635
Norman, OK 73072
Salas O'Brien Registration: CA# 7058
Expiration Date: 6/30/2025
Salas O'Brien Project Number: 2023-02792-00