


**GENERAL NOTES**


1. FIRE: CONNECT NEW FIRE ALARM DEVICES TO NEW MAIN BUILDING SILENT KNIGHT FIRE ALARM SYSTEM. SUPPLY ALL POWER SUPPLIES NAC PANELS, ETC NEEDED. PLEASE SEE FIRE ALARM SPECIFICATIONS FOR PART NUMBERS AND SYSTEM REQUIREMENTS.
2. SECURITY: CONNECT NEW SECURITY ALARM DEVICES TO NEW DSC 4204 POWER SUPPLY AND DSC 4116 ZONE EXPANDER. CONNECT NEW DSC 4204 POWER SUPPLY AND DSC 4116 ZONE EXPANDER TO EXISTING MAIN BUILDING DSC 4020. CONNECT WITH 2-4 CONDUCTOR 16 GAUGE NON-SHIELDED CABLES. PROGRAM AS NEEDED TO COMPLETE CONNECTION.
3. DATA: CONNECT NEW DATA, WIFI AND CAMERA NETWORK DROPS TO NEW IDF. CONNECT NEW IDF TO EXISTING MAIN BUILDING MDF VIA FIBER AND CAT 6. SEE NETWORK SPECS FOR FIBER AND CAT 6 INFO.
4. INTERCOM: CONNECT NEW INTERCOM DEVICES TO EXISTING TELECOR SYSTEM. PROVIDE TELECOR CLOCK DRIVER AS NEEDED.
5. CLOCK: CONNECT NEW CLOCK DEVICES TO EXISTING TELECOR SYSTEM. PROVIDE TELECOR CLOCK DRIVER AS NEEDED.
6. ACCESS CONTROL: CONNECT NEW ACCESS CONTROL DEVICES TO NEW KEYSAN CONTROLLER.
7. CAMERAS: CONNECT NEW CAMERAS TO NEW IDF. SEE CAMERA SPECIFICATIONS FOR MOUNTING LOCATION.

**FIRE ALARM**

- A. FIRE ALARM SYSTEM IS A PERFORMANCE BASED PER SHEET SPECIFICATIONS. CONTRACTOR TO REFERENCE SHEET T603 FOR ADDITIONAL INFORMATION.
- B. A LICENSED FIRE ALARM PLANNING SUPERINTENDENT CERTIFIED TO A MINIMUM LEVEL 3, IN THE SUBFIELD OF FIRE ALARM SYSTEMS THROUGH THE NATIONAL INSTITUTE FOR CERTIFICATION IN ENGINEERING TECHNOLOGIES (NICET), SHALL PROVIDE PLANS AND CALCULATIONS FOR A MANUAL AND AUTOMATIC FIRE DETECTION AND ALARM SYSTEM TO COMPLY WITH THE BUILDING SPACE LAYOUT, BUILDING OCCUPANCY, CURRENT NFPA 72, LOCAL AND STATE CODE REQUIREMENTS, AND THE FIRE ALARM AND DETECTION SYSTEM SPECIFICATIONS.
- C. CONTRACTOR TO ADD ADDITIONAL STROBE DEVICE TO ALL CLASSROOMS.

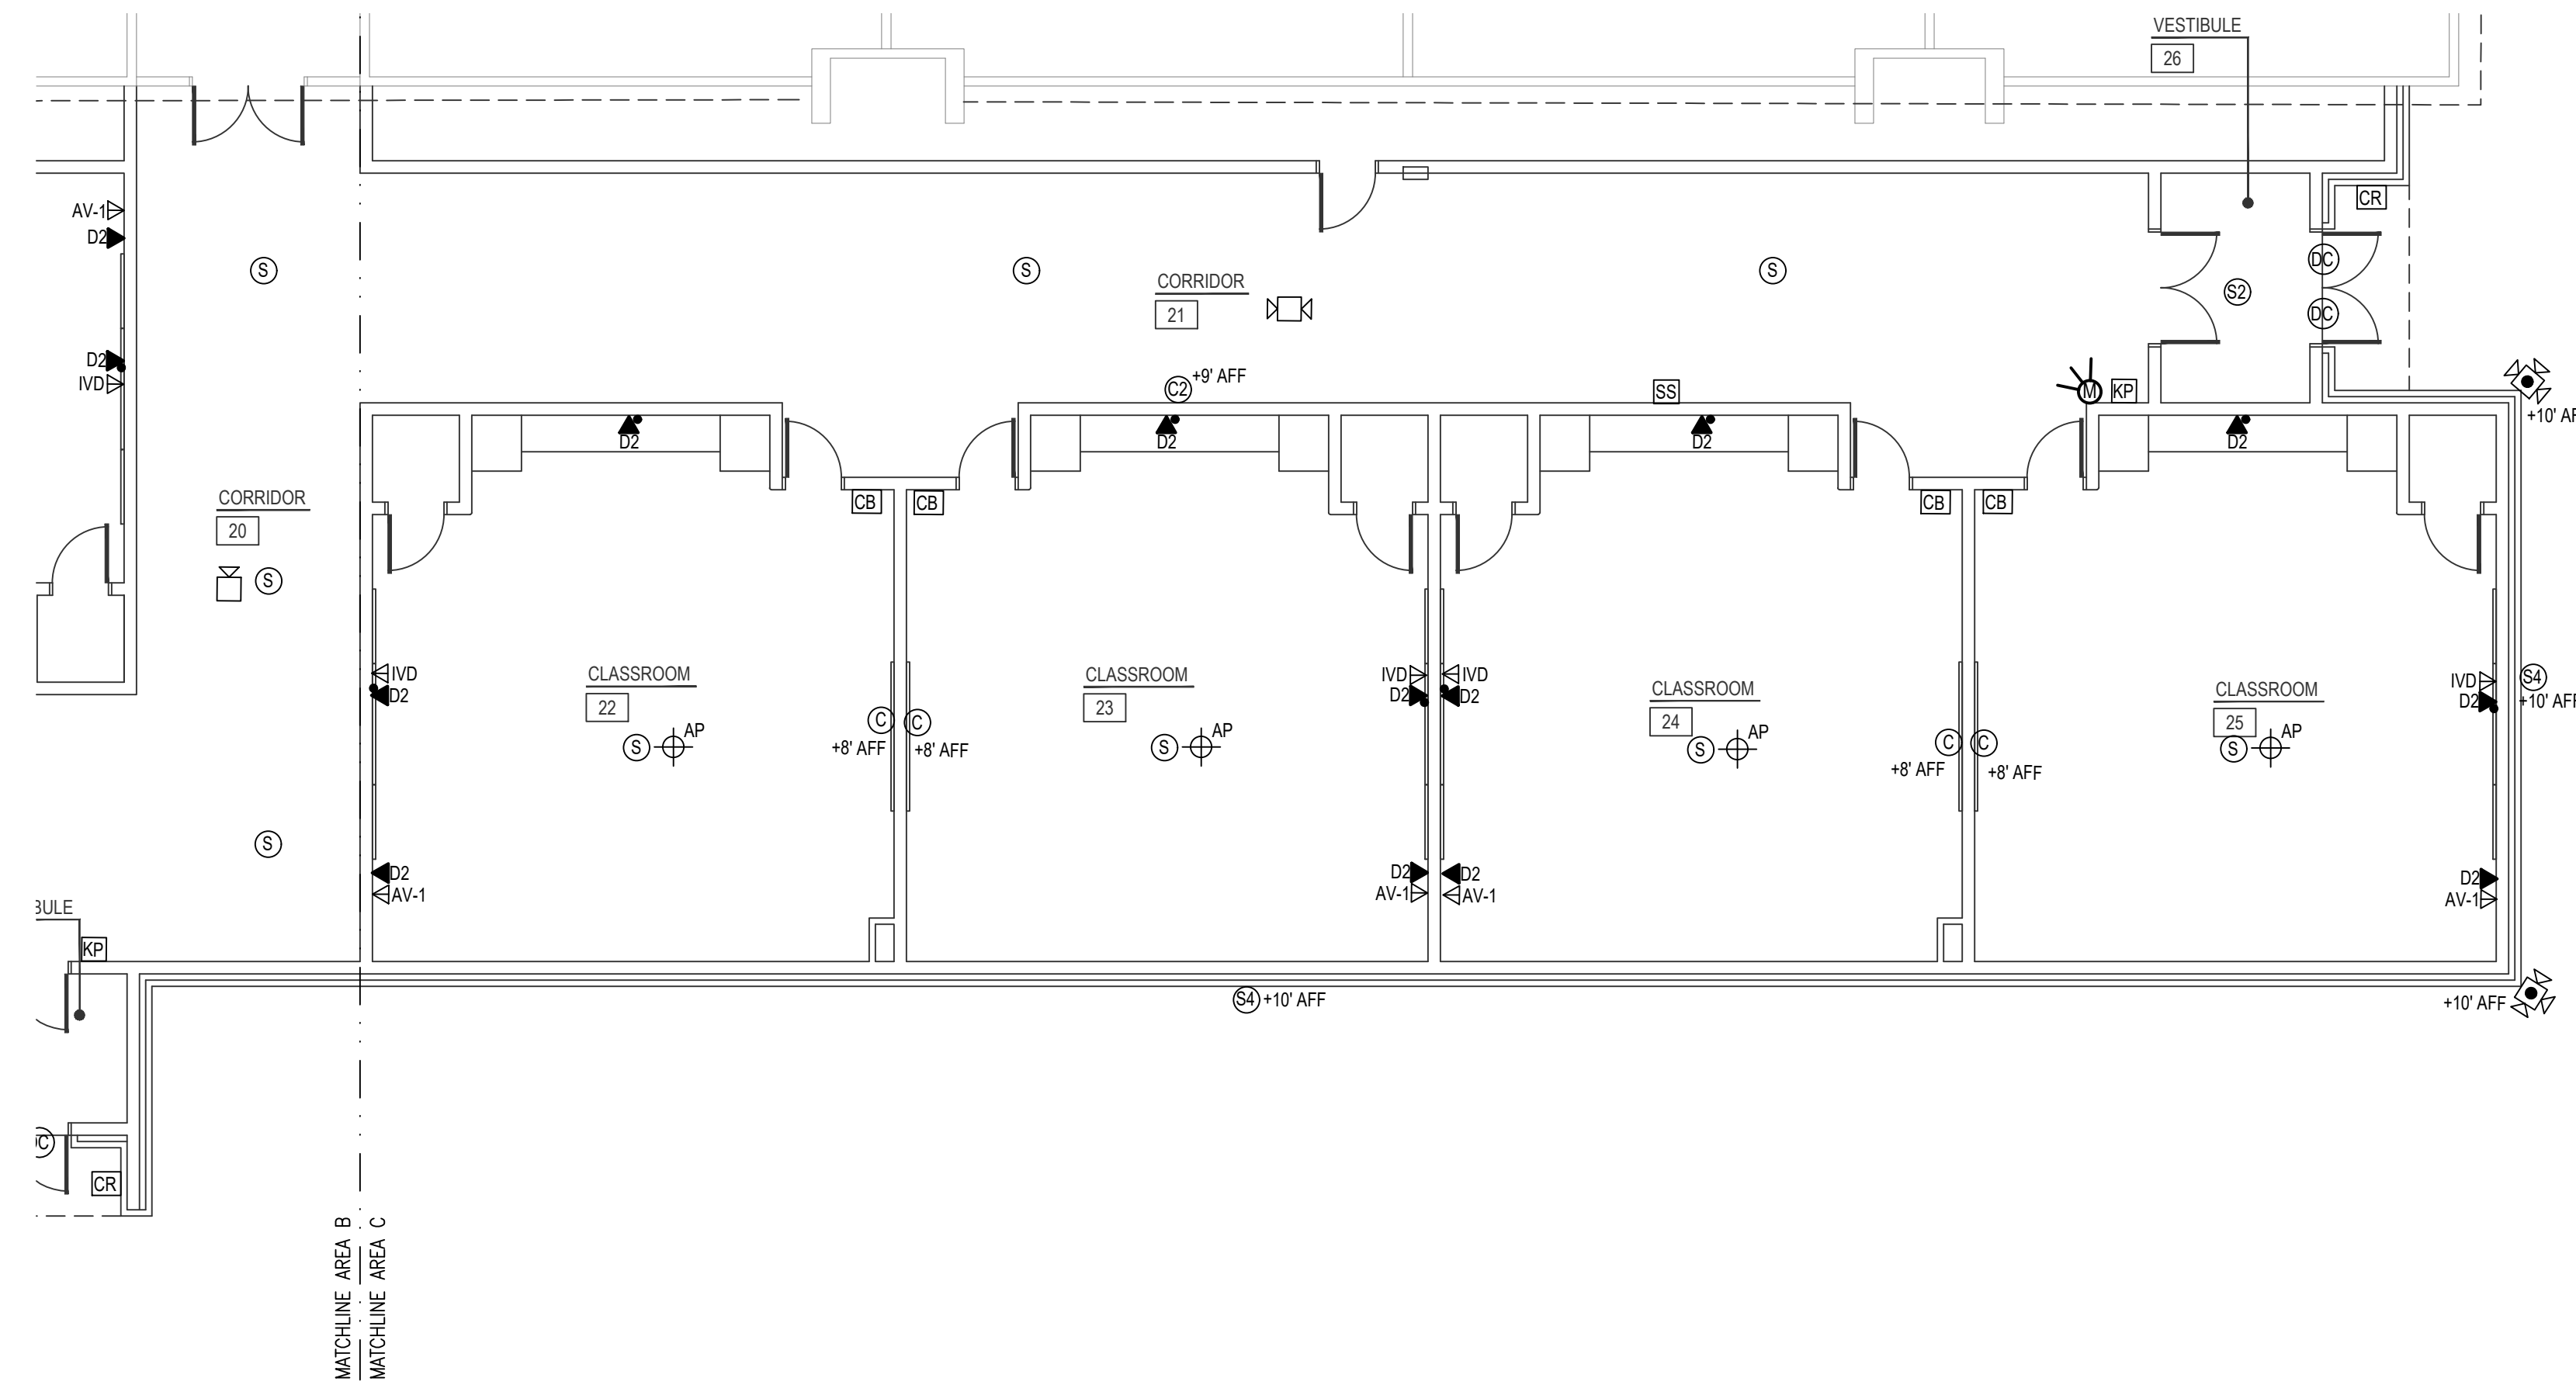

**1 CLASSROOMS - AREA C**  
SCALE: 1/8" = 1'-0"

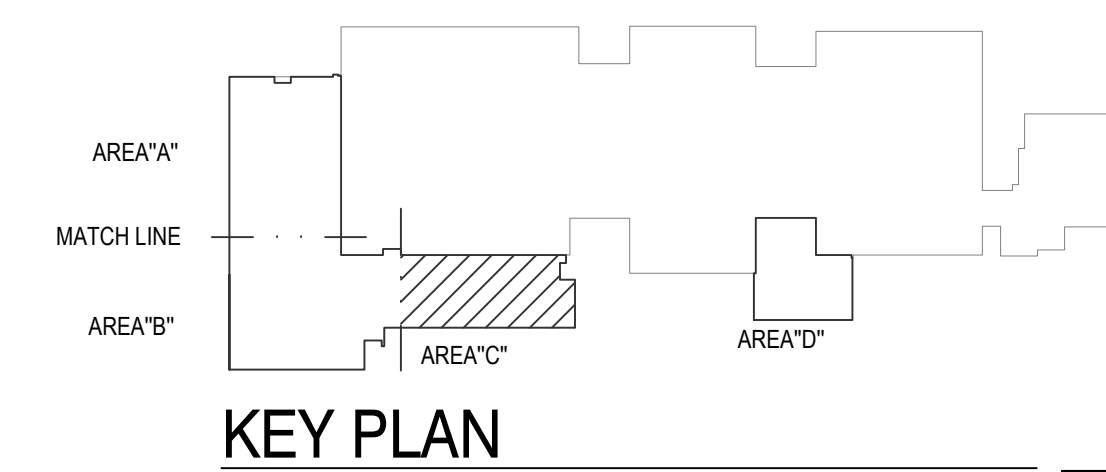

**KEY PLAN**



NY	drawn by
NY	checked by
JULY 2023	date
	revisions

MOORE PUBLIC SCHOOLS  
BOARD OF EDUCATION  
MOORE, OKLAHOMA



CLASSROOM ADDITION  
HIGHLAND WEST  
JUNIOR HIGH SCHOOL

sheet no:

**T203**

**Salas O'Brien**  
2600 Van Buren St., Suite 2635  
Norman, OK 73072  
Salas O'Brien Registration: CA# 7058  
Expiration Date: 6/30/2025  
Salas O'Brien Project Number: 2023-02792-00

OWNERSHIP USE OF DOCUMENTS:  
AGP EXPRESSLY RESERVES ITS COPYRIGHT AND OTHER PROPERTY RIGHTS OF ALL PLANS AND DRAWINGS DESIGNED AND/OR PRODUCED. PLANS AND DRAWINGS ARE NOT TO BE REPRODUCED IN ANY FORM OR MANNER WITHOUT THE EXPRESSED WRITTEN CONSENT OF AGP.