

CONSTRUCTION BULLETIN # 03

Client: Abla Griffin Partnership
 Project Name: Kelley Elementary Saferoom Addition
 Project Number: 2022-04164-00

December 30, 2022

Requested by: Owner
 Contractor:
 Salas O'Brien:

To: Mike Abla, Clay Griffin, AGP


This Construction Bulletin is issued to:

- Offer additional information for clarification or supplemental drawings for layout assistance.
- Request cost and time impact to initiate a change to the Contract Documents. Owner approval is required, do not commence with revisions unless directed in writing. Avoid Work in areas that may be affected by proposed change until approved or rejected. Once approved, forward Change Order documentation as required by the Contract Documents.
- Direct a required change in the Contract Documents. Proceed with change(s) as indicated. Forward Change Order documentation as required by the Contract Documents.
- Response to RFI _____.

Item No.	Description	Attachment
1	Refer to drawings for changes shown in clouds and deltas.	T100

END OF CB-03



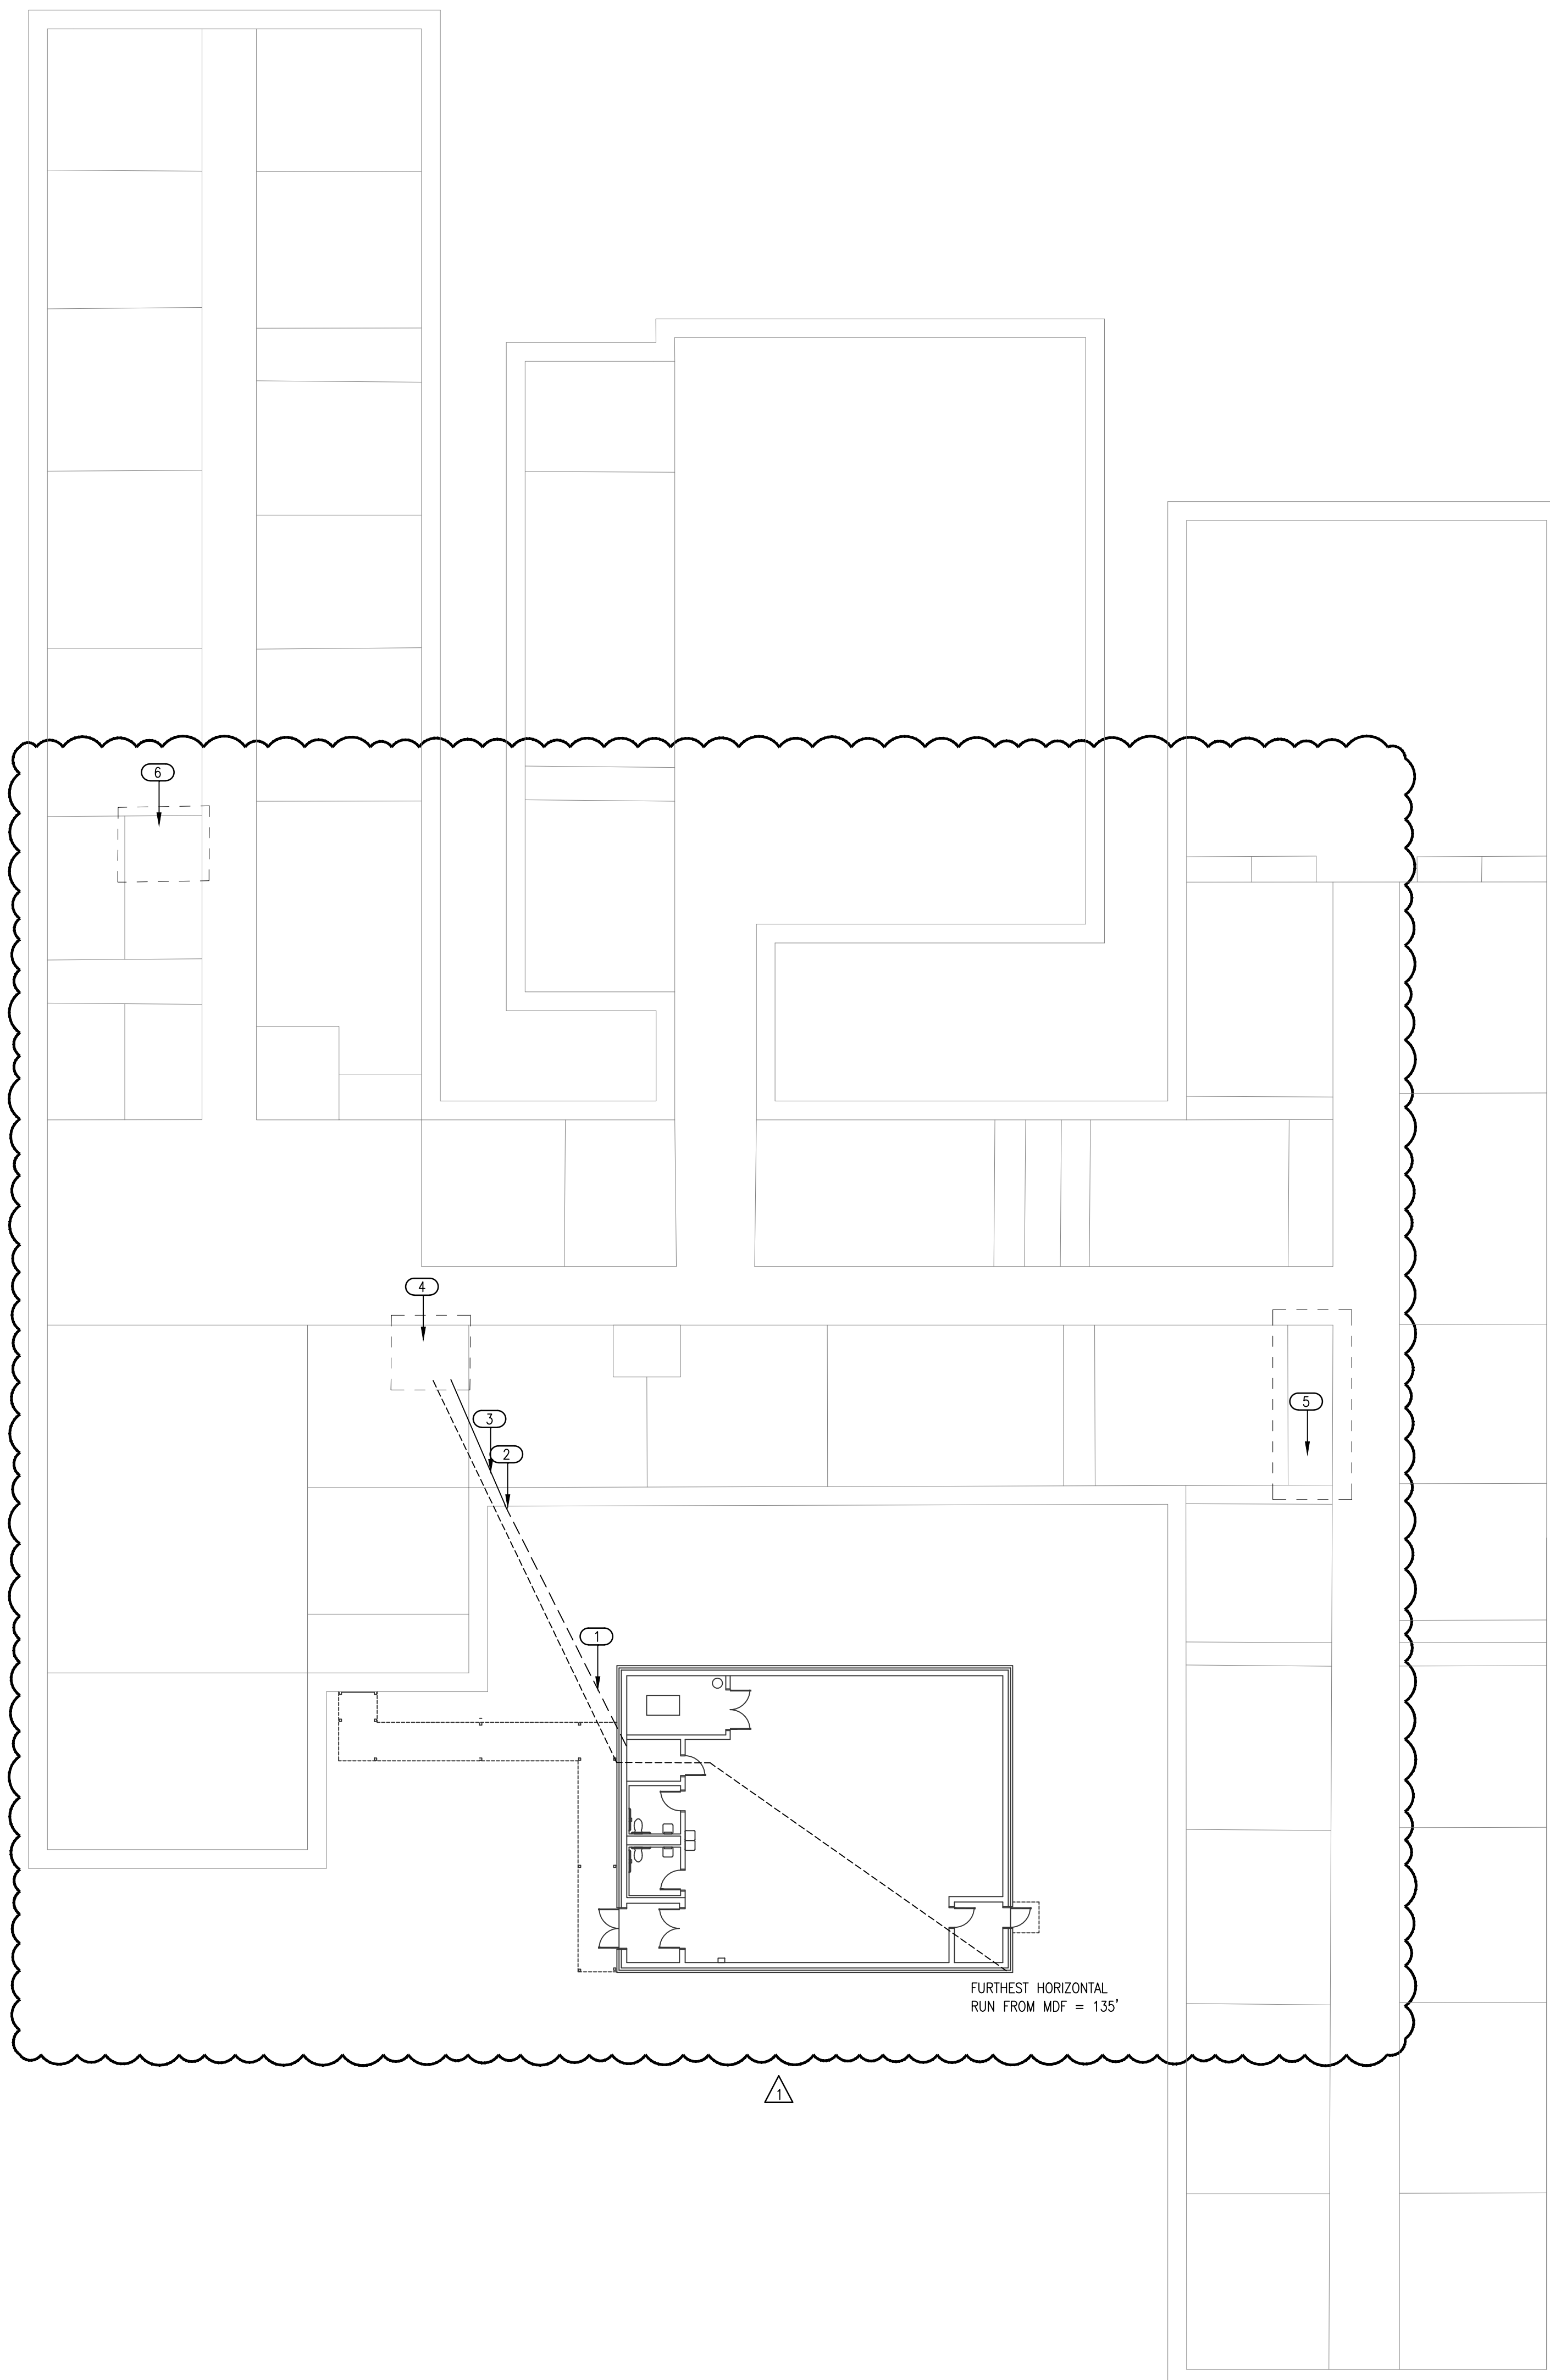

GENERAL NOTES

- A. INTERCOM: CONNECT NEW INTERCOM DEVICES TO EXISTING TELECOR SYSTEM. INTERCOM WIRE SHALL BE SHIELDED. CONTRACTOR TO PROVIDE EQUIPMENT WIRE AND SYSTEM PROGRAMMING NEEDED. PROVIDE 4 EXTRA SHIELDED INTERCOM WIRES FOR FUTURE USE. PROVIDE ENOUGH SLACK TO REACH FURTHEST WALL.
- B. DATA: CONNECT ALL NEW DATA DROPS TO EXISTING MDF LOCATED IN MAIN BUILDING. PROVIDE 4 EXTRA CAT 6 CABLES FOR FUTURE USE. PROVIDE ENOUGH SLACK TO REACH FARTHEST WALL.
- C. SECURITY ALARM: CONNECT NEW SECURITY ALARM DEVICES TO EXISTING DSC SECURITY ALARM SYSTEM LOCATED IN MAIN BUILDING. ALL WIRING SHALL BE NON-SHIELDED. CONTRACTOR TO PROVIDE ALL EQUIPMENT, WIRE AND SYSTEM PROGRAMMING NEEDED.
- D. FIRE ALARM: CONNECT NEW FIRE ALARM DEVICES TO EXISTING SILENT KNIGHT FIRE ALARM SYSTEM LOCATED IN MAIN BUILDING. CONTRACTOR TO PROVIDE ALL EQUIPMENT, WIRE AND SYSTEM PROGRAMMING NEEDED.
- E. CLOCK: CLOCK SHALL BE STAND ALONE 110V CLOCK AMERICAN TIME MODEL E56BAAV304

KEYED NOTES

- ① CONTRACTOR TO PROVIDE AND INSTALL 4-2" AND 1-1" UNDERGROUND CONDUITS FROM SAFE ROOM IDF TO EXTERIOR OF EXISTING BUILDING AS INDICATED. CONDUITS SHALL BE DEDICATED AS FOLLOWS:
 1-2" FOR DATA
 1-2" FOR INTERCOM
 1-2" FOR SECURITY
 1-2" FOR SPARE
 1-1" FOR FIRE
- ② INDICATES THE LOCATION WHERE THE UNDERGROUND CONDUITS SHALL STUB UP EXTERIOR WALL AND INTO THE PLENUM SPACE OF THE EXISTING BUILDING. CONDUITS SHALL BE SECURED TO BUILDING STRUCTURE. ALL PENETRATIONS SHALL BE PROPERLY SEALED.
- ③ INDICATED APPROXIMATE ROUTE OF ABOVE CEILING. NO WIRING CABLING SHALL BE EXPOSED.
- ④ APPROXIMATE LOCATION OF EXISTING MDF.
- ⑤ APPROXIMATE LOCATION OF EXISTING IDF.
- ⑥ APPROXIMATE LOCATION OF EXISTING FACP, INTERCOM HEAD END UNIT AND SECURITY ALARM MAIN CONTROL UNIT.

CEDAR CREEK INC.

CIVIL

KFC ENGINEERING

STRUCTURAL

SALAS O'BRIEN

MECHANICAL / ELECTRICAL

NY

drawn by

NY

checked by

OCTOBER 2022

date

12/30/22 CB03

revisions

MOORE PUBLIC SCHOOLS
 BOARD OF EDUCATION
 MOORE, OKLAHOMA



NEW ADDITION
 KELLEY ELEMENTARY
 SCHOOL

sheet no:

T100



2600 Van Buren St., Suite 2635
 Norman, Oklahoma 73072
 P: 405.364.9926 | CA#:7058 Expiration Date: 6/30/2023

Salas O'Brien Project No.: 2022-04164-00

OWNERSHIP USE OF DOCUMENTS:
 AGP EXPRESSLY RESERVES ITS
 COPYRIGHT AND OTHER PROPERTY
 RIGHTS OF ALL PLANS AND DRAWINGS
 DESIGNED AND/OR PRODUCED. PLANS
 AND DRAWINGS ARE NOT TO BE
 REPRODUCED IN ANY FORM OR MANNER
 WITHOUT THE EXPRESSED WRITTEN
 CONSENT OF AGP.