



KF	drawn by
DMG	checked by
MAY 2023	date
	revisions

MOORE PUBLIC SCHOOLS
BOARD OF EDUCATION
MOORE, OKLAHOMA



LOCKER ROOM
ADDITION
MOORE WEST
JUNIOR HIGH SCHOOL

sheet no:

M101

OWNERSHIP USE OF DOCUMENTS:


AGP EXPRESSLY RESERVES ITS
COPYRIGHT AND OTHER PROPERTY
RIGHTS OF ALL PLANS AND DRAWINGS
DESIGNED AND/OR PRODUCED. PLANS
AND DRAWINGS ARE NOT TO BE
REPRODUCED IN ANY FORM OR MANNER
WITHOUT THE EXPRESSED WRITTEN
CONSENT OF AGP.

GENERAL NOTES

- COORDINATE WORKS WITH ALL TRADES.
- COORDINATE LOCATION OF THERMOSTATS WITH E.C. ROUGH-IN BY E.C.
- EXPOSED CEILING WITH SPIRAL DUCT SHALL HAVE PAINT GRIP FINISH. COLOR BY ARCHITECT.

KEYED NOTES

- PROVIDE DUCTWORK RUNNING FROM EXHAUST GRILLE CARRYING MOISTURE-LADEN AIR CONSTRUCTED OF ALUMINUM IN ACCORDANCE WITH SMACNA STANDARDS. SEAL ALL JOINTS AND SEAMS WATERTIGHT. SLOPE DUCT DOWN TO GRILLE.
- PROVIDE 4" REINFORCED CONCRETE PAD. INSTALL UNIT IN ADHERENCE WITH MANUFACTURER'S SUGGESTED CLEARANCES. EXTEND CONCRETE PAD A MINIMUM OF 6" ON EACH SIDE OF UNIT. EXTEND PAD TO BUILDING. COORDINATE WITH G.C. AND ARCHITECT.
- DUCT UP TO EF-1.
- ROUTE DUCTWORK TIGHT TO BOTTOM OF STRUCTURE.

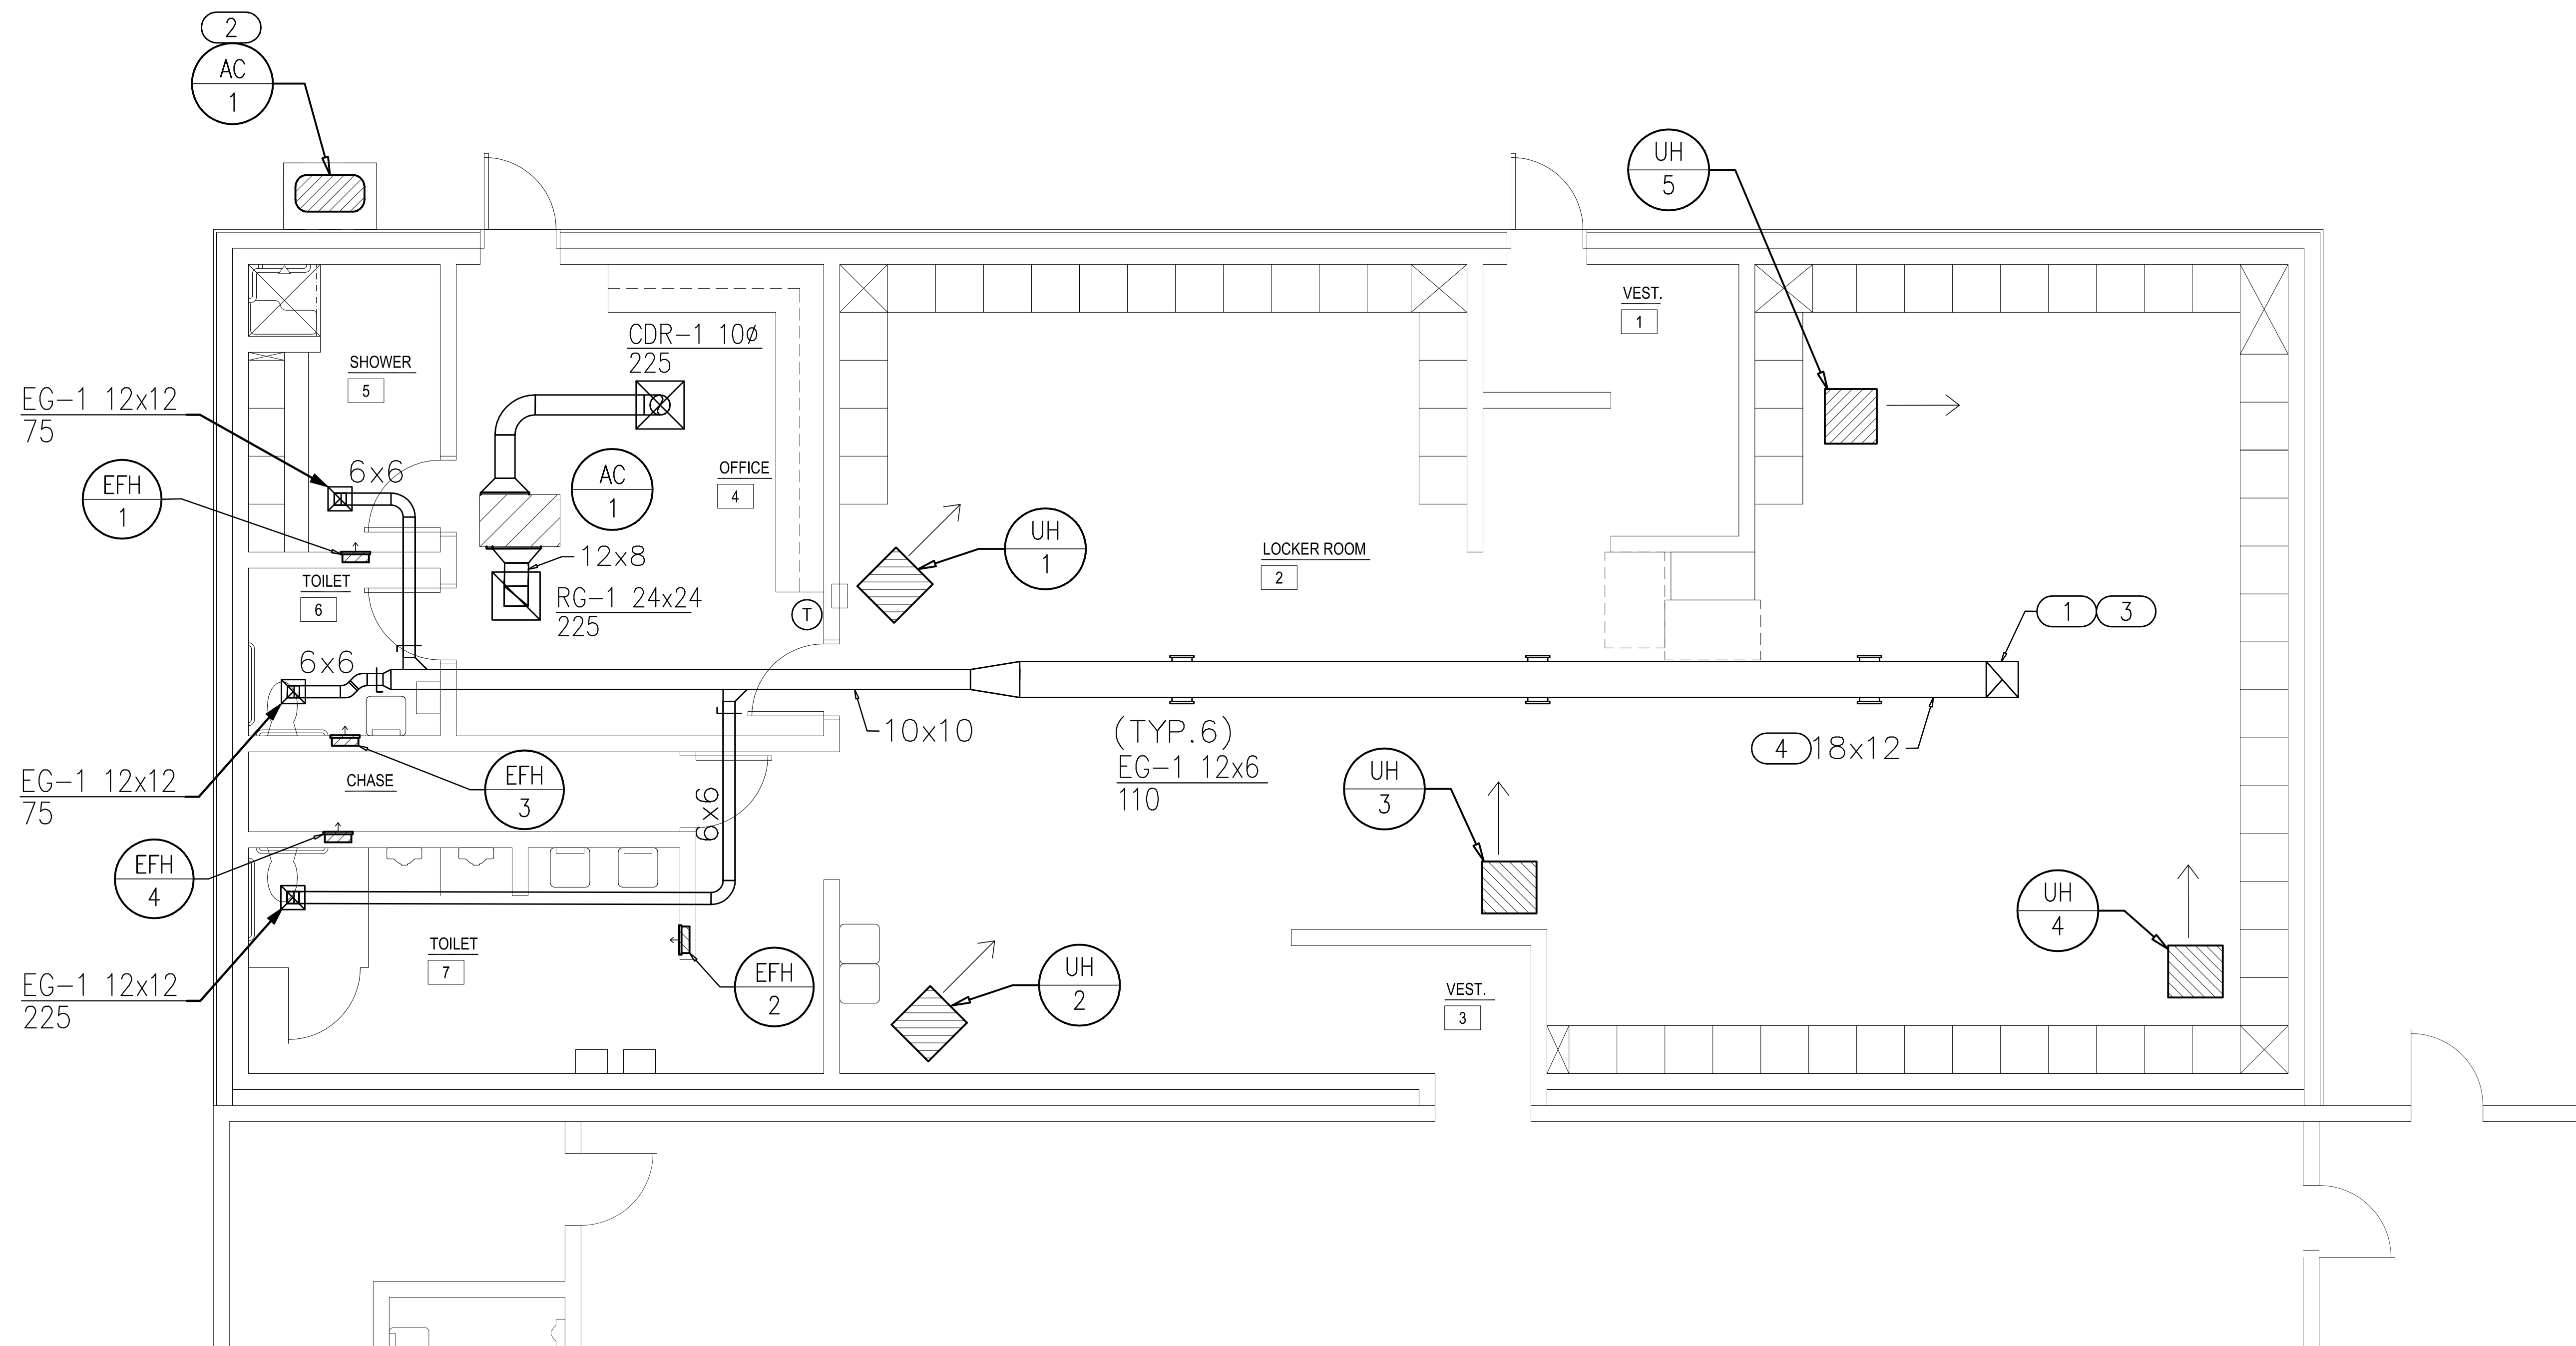

MECHANICAL DUCTWORK PLAN
SCALE: 1/4" = 1'-0"



Salas O'Brien
2600 Van Buren St., Suite 2635
Norman, OK 73072
Salas O'Brien Registration: CA# 7058
Expiration Date: 6/30/2025
Salas O'Brien Project Number: 2023-04636-00