



KC
drawn by

KP
checked by

MAY 2023
date

revisions

MOORE PUBLIC SCHOOLS
BOARD OF EDUCATION
MOORE, OKLAHOMA



LOCKER ROOM
ADDITION
MOORE WEST
JUNIOR HIGH SCHOOL

sheet no:

PD101

OWNERSHIP USE OF DOCUMENTS:


AGP EXPRESSLY RESERVES ITS
COPYRIGHT AND OTHER PROPERTY
RIGHTS OF ALL PLANS AND DRAWINGS
DESIGNED AND/OR PRODUCED. PLANS
AND DRAWINGS ARE NOT TO BE
REPRODUCED IN ANY FORM OR MANNER
WITHOUT THE EXPRESSED WRITTEN
CONSENT OF AGP.

GENERAL NOTES

1. FIELD VERIFY EXISTING CONDITIONS PRIOR TO COMMENCING WORK.
2. COORDINATE WORK WITH ALL TRADES ON SITE.

KEYED NOTES

- ① REMOVE STORM DRAINAGE PIPING BELOW GRADE AND ABOVE GRADE. FIELD VERIFY LOCATION. COORDINATE REMOVAL WITH SITE CONTRACTOR.
- ② REMOVE SANITARY SEWER BELOW GRADE FOR REPLACEMENT OF PIPING RATED FOR BELOW NEW ADDITION. FIELD VERIFY LOCATION AND SIZE.
- ③ REMOVE SANITARY SEWER BELOW GRADE FOR REROUTING AROUND NEW ADDITION. FIELD VERIFY LOCATION AND SIZE. COORDINATE WITH SITE CONTRACTOR.

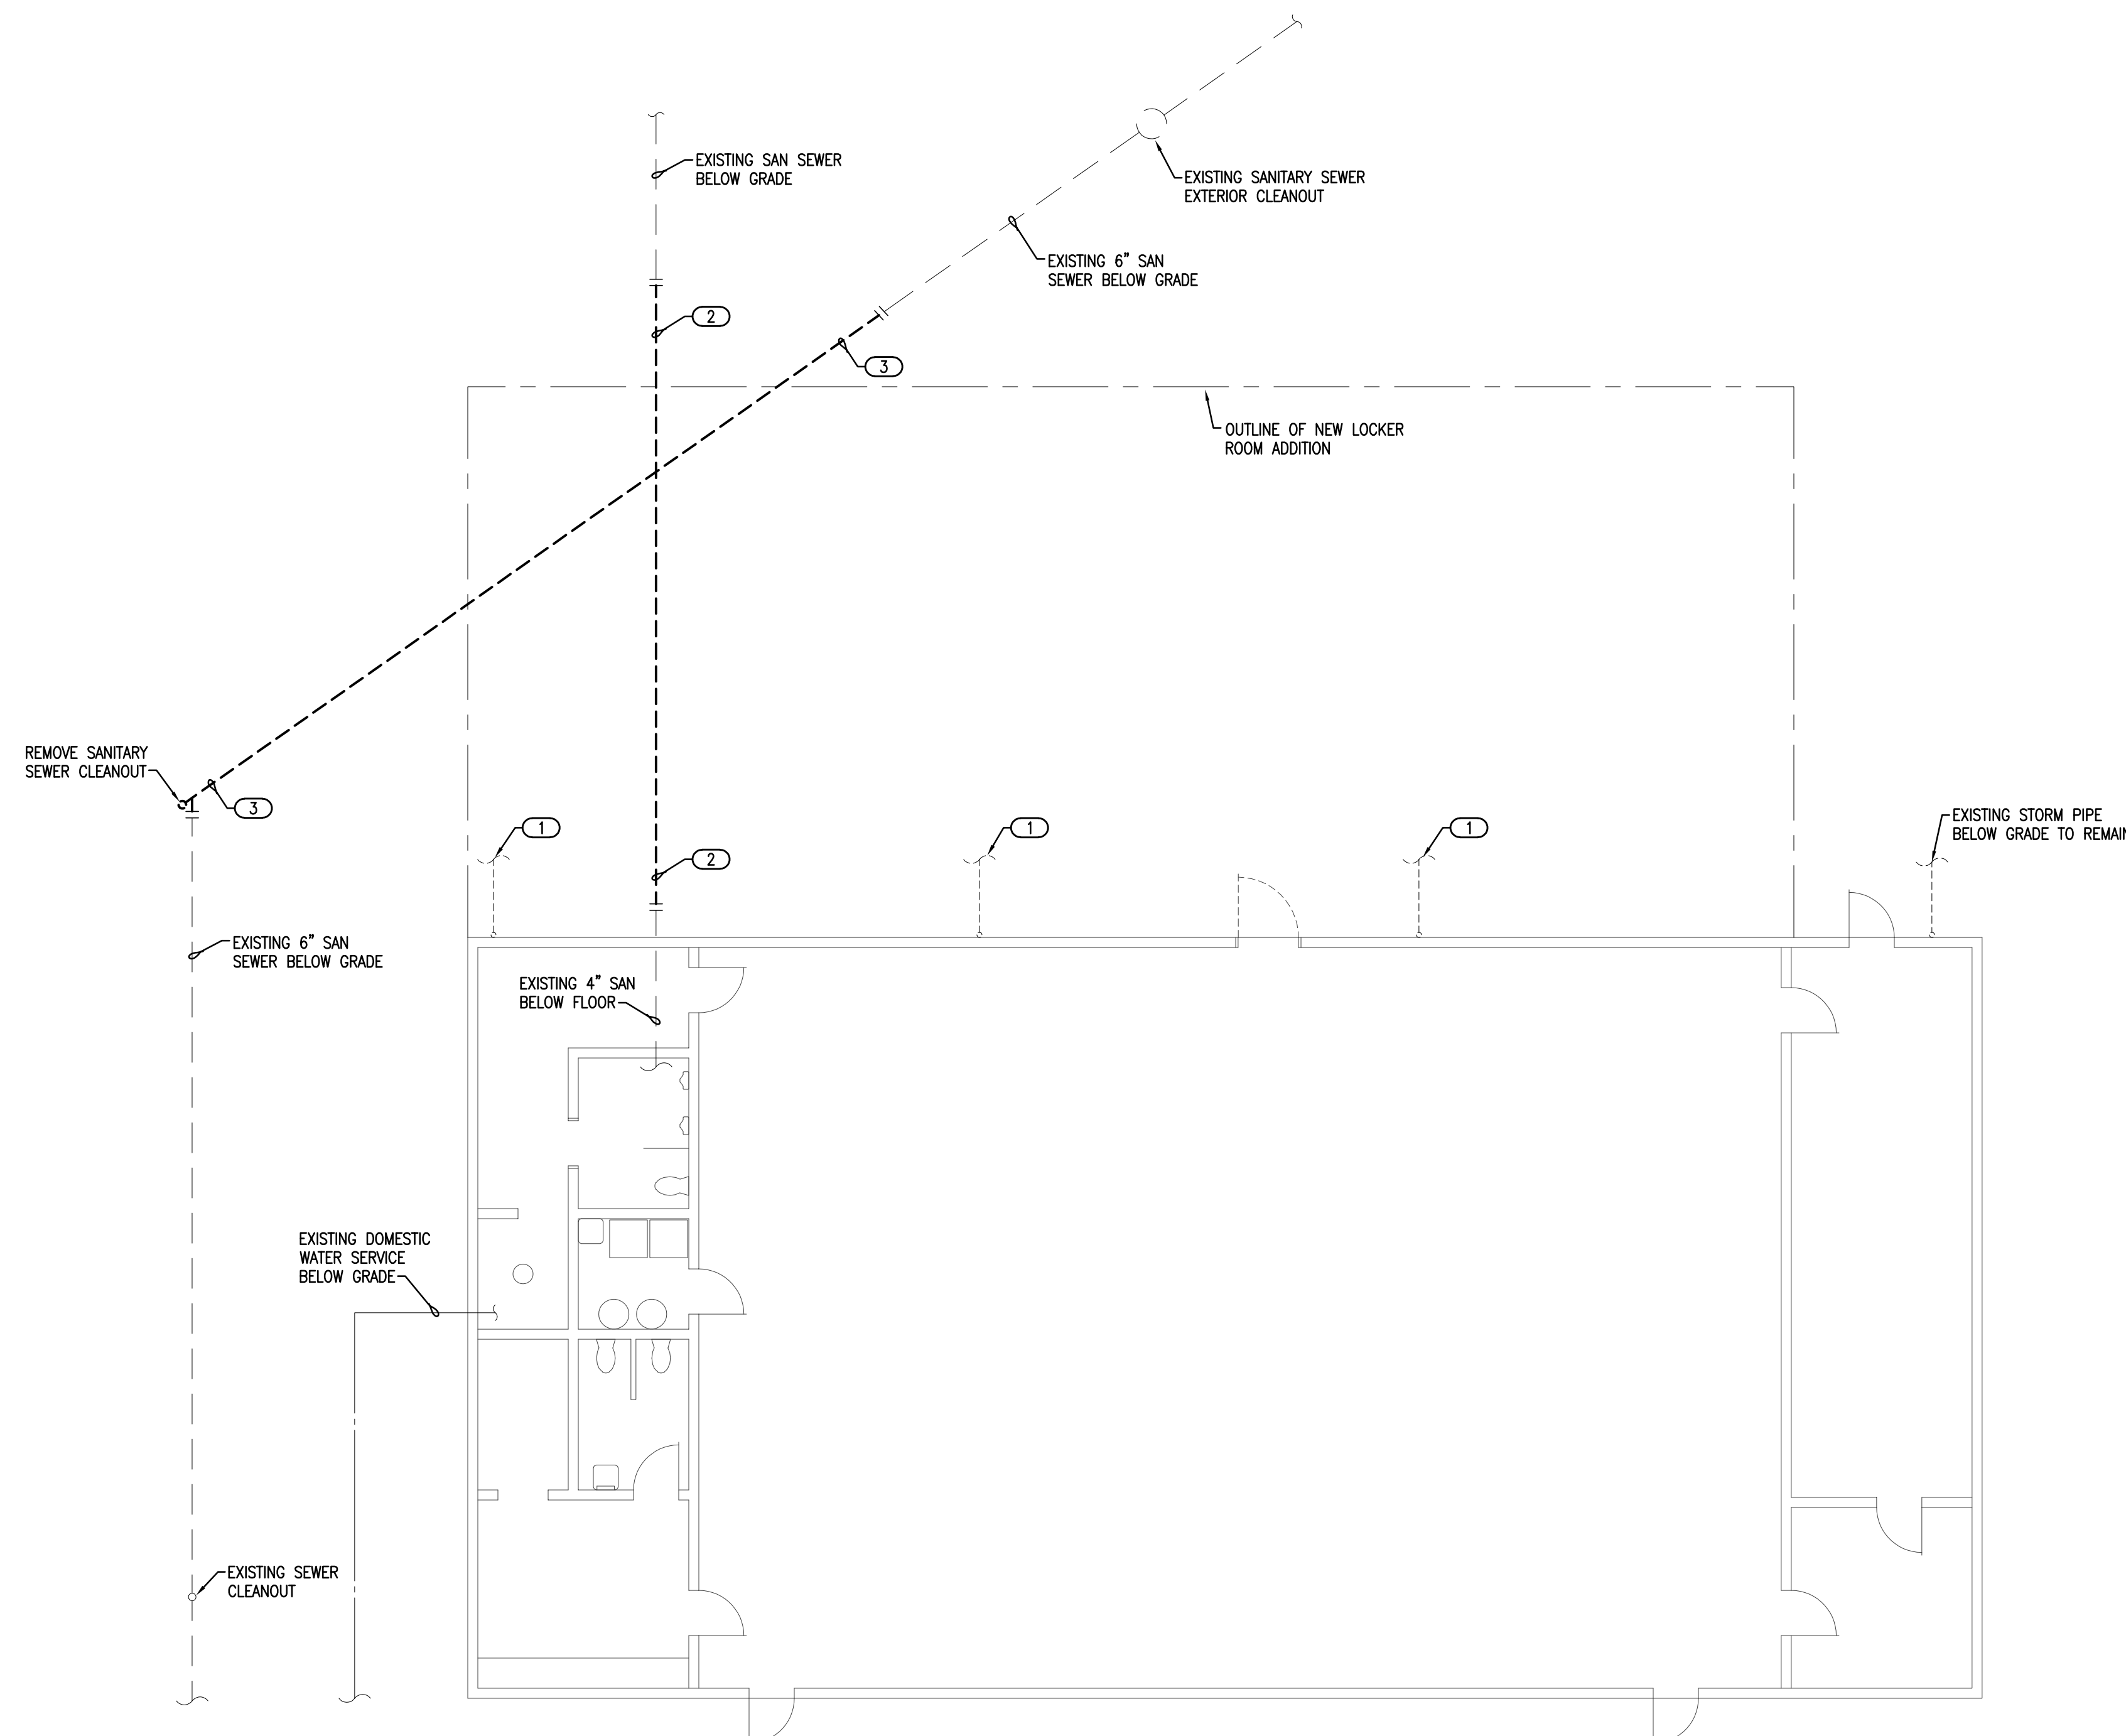

1 PLUMBING PLAN - DEMOLITION
SCALE: 1/8" = 1'-0"

