



MOORE PUBLIC SCHOOLS DISTRICT NO. 1-2  
CLEVELAND COUNTY MOORE, OKLAHOMA

# CHILD CARE CENTER

201 NORTH EASTERN AVE.  
MOORE, OK. 73160

**AGP** | the Abla Griffin  
Partnership

313 SE. 5TH ST. MOORE, OK. 73160  
405.735.3477 AGP@theAGP.net www.theAGP.net

CONSTRUCTION MANAGER



1909 S. EASTERN AVE.  
MOORE, OK 73160

STRUCTURAL  
KFC ENGINEERING

205 NW 63rd, SUITE 390  
OKLAHOMA CITY, OK 73116

MECHANICAL/ELECTRICAL/PLUMBING  
SALAS O'BRIEN

2900 S. TELEPHONE RD., SUITE 120  
MOORE, OKLAHOMA 73160

CIVIL  
CEDAR CREEK


11912 N. PENNSYLVANIA AVE., SUITE D4  
OKLAHOMA CITY, OK 73120

KITCHEN CONSULTANT  
STURM CONSULTING, INC.

6838 S. HUDSON PL.  
TULSA, OK. 74135

## INDEX TO DRAWINGS

SHEET NUMBER	DESCRIPTION	SHEET NUMBER	DESCRIPTION
C	COVER SHEET	F101	FIRE PROTECTION PLAN - SITE
--	TOPOGRAPHIC SURVEY - FOR INFORMATION ONLY	P000	GENERAL NOTES
G100	LEGENDS / MAPS / ETC.	P001	PLUMBING SITE PLAN
G101	SHELTER CALCULATION PLAN / SHELTER LOCATION PLAN	P002	PLUMBING PLAN - BELOW GRADE
GEN-101	GENERATOR BUILDING FLOOR PLAN / ELEVATIONS / SECTIONS / DETAILS	P110	PLUMBING PLAN - ABOVE GRADE
PUBLIC WATER PLANS		P201	PLUMBING PLAN - ROOF
C0.00	COVER SHEET	P302	PLUMBING ISOMETRIC WASTE & VENT
C1.00	UTILITY PLAN	P301	PLUMBING ISOMETRIC WATER SUPPLY
C2.00	WATERLINE 1 PLAN AND PROFILE	P501	DETAILS
C2.01	WATERLINE DETAILS	P502	DETAILS
C3.00	EROSION CONTROL PLAN	P801	SCHEDULES
C3.01	EROSION CONTROL DETAILS	M000	MECHANICAL NOTES
S100	GENERAL NOTES	M101	MECHANICAL PLAN
S101	GENERAL NOTES	M201	MECHANICAL ROOF PLAN
S102	GENERAL NOTES	M501	DETAILS
S103	SHELTER INFORMATION / SHELTER LOAD PLAN	M801	SCHEDULES
S104	DETAILS	T000	TECHNOLOGY LEGENDS / NOTES
S105	DETAILS	T101	TECHNOLOGY SITE PLAN
S106	SPECIAL INSPECTIONS	T201	TECHNOLOGY PLAN
S200	OVERALL FOUNDATION PLAN	T301	DETAILS
S201	OVERALL FOUNDATION PLAN	T302	DETAILS
S202	PARTIAL FOUNDATION PLAN	T303	DETAILS
S300	OVERALL FRAMING PLAN	T304	DETAILS
S301	FRAMING PLAN	T401	SYSTEM SPECIFICATIONS
S501	FOUNDATION SECTIONS	T402	SYSTEM SPECIFICATIONS
S601	FRAMING SECTIONS	T403	SYSTEM SPECIFICATIONS
S602	FRAMING SECTIONS	E000	ELECTRICAL NOTES / SCHEDULES
S700	GENERAL FOUNDATION PLAN / FRAMING PLAN / SECTIONS	E100	ELECTRICAL SITE PLAN
S701	DEMOLITION PLAN	E201	ELECTRICAL LIGHTING PLAN
S702	OVERALL FOUNDATION PLAN	E202	ELECTRICAL POWER PLAN
A100a	DIMENSION PLAN	E203	ELECTRICAL ROOF PLAN
A100b	REFERENCE PLAN	E401	ELECTRICAL ONE-LINE DIAGRAM / SCHEDULE
A101	WALL TYPE PLAN	E501	DETAILS
A102	LIFE SAFETY PLAN	E502	DETAILS
A103	ENLARGED FLOOR PLANS	E801	SCHEDULES
A104	ENLARGED FLOOR PLANS	E802	SCHEDULES
A105	ENLARGED FLOOR PLANS		
A106	REFLECTED CEILING PLAN		
A107	ROOF PLAN - CLASSROOM AREA / ROOF PLAN - OFFICE AREA		
A107a	ROOF DETAILS		
A108	MECHANICAL PLAN		
A109	EQUIPMENT FLOOR PLAN		
A110	BUILDING ELEVATIONS		
A301	BUILDING SECTION		
A302	WALL SECTIONS		
A303	WALL SECTIONS		
A401	INTERIOR ELEVATIONS		
A402	INTERIOR ELEVATIONS		
A501	DETAILS		
A601	ROOM FINISH SCHEDULE / COLOR SCHEDULE		
A602	DOOR SCHEDULE / DOOR ELEVATIONS / FRAME ELEVATIONS		
A701	MILLWORK DETAILS		
A702	MILLWORK DETAILS		
F101	FOODSERVICE EQUIPMENT ARRANGEMENT PLAN		
F102	ELEVATIONS		
FS201	FOODSERVICE EQUIPMENT SPECIAL CONDITIONS PLAN / DETAILS		
FS301	FOODSERVICE EQUIPMENT PLUMBING CONNECTIONS PLAN / SCHEDULE / DETAILS		
FS401	FOODSERVICE EQUIPMENT ELECTRICAL CONNECTIONS PLAN / SCHEDULE / DETAILS		
FS501	FOODSERVICE EQUIPMENT VENTILATOR PLAN		
FS502	FOODSERVICE EQUIPMENT VENTILATOR PLAN		
FS503	FOODSERVICE EQUIPMENT VENTILATOR PLAN		
FS504	FOODSERVICE EQUIPMENT VENTILATOR PLAN		
FS505	FOODSERVICE EQUIPMENT VENTILATOR PLAN		
FS506	FOODSERVICE EQUIPMENT VENTILATOR PLAN		
FS601	FOODSERVICE EQUIPMENT WALK-IN PLAN		
FS701	FOODSERVICE EQUIPMENT REFRIGERATION PLAN		
FS801	FOODSERVICE EQUIPMENT SNEEZE GUARD PLAN		

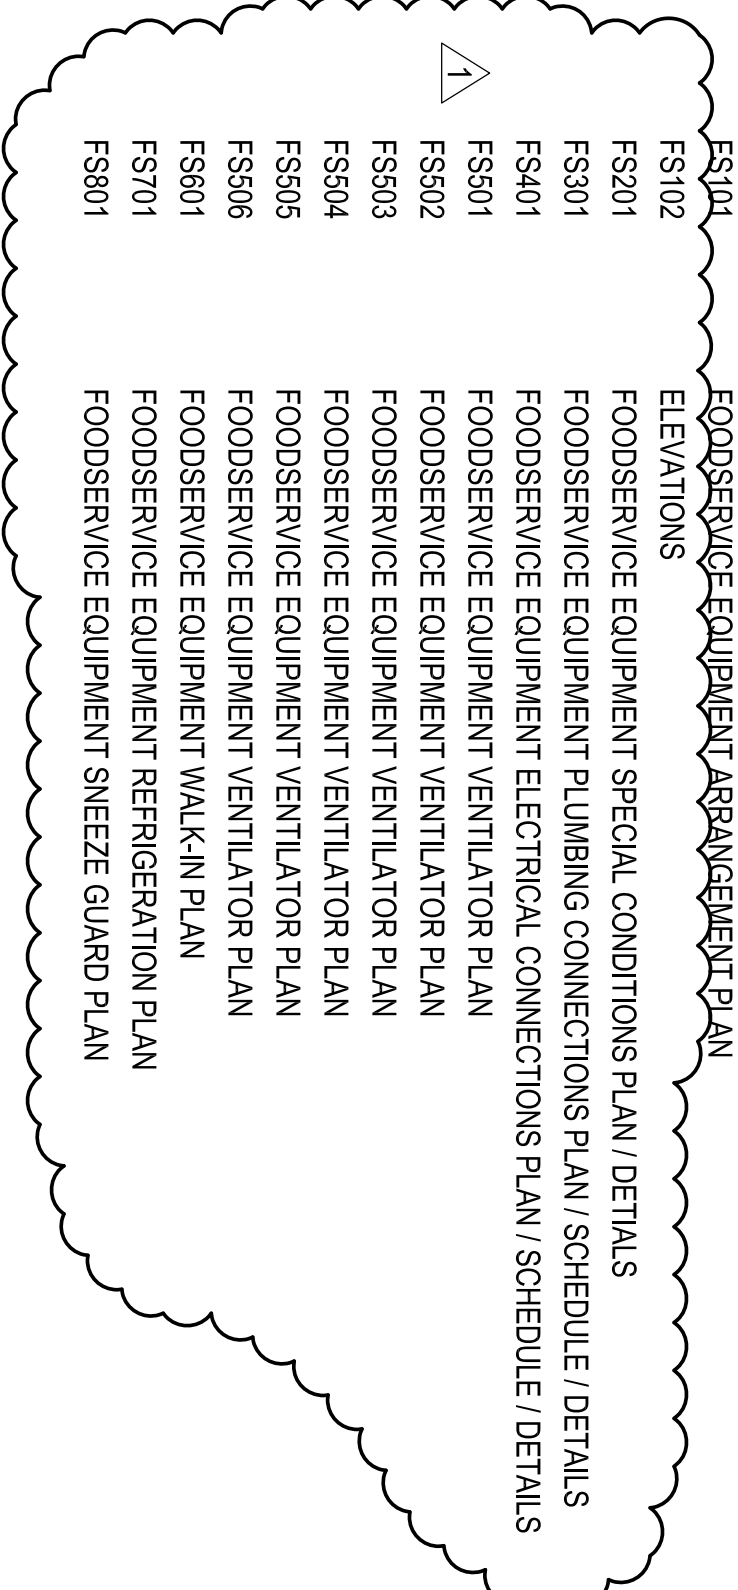

Revisions:

ADDENDUM #1

Sheet no:

C

date:

OCTOBER 2024

CHILD CARE CENTER  
SET NO.