

CG	drawn by	MA	checked by
			OCTOBER 2024
			date
			revisions





MOORE
PUBLIC SCHOOLS

CHILD CARE FACILITY
201 N. EASTERN AVE.

Sheet No.:


A402

OWNERSHIP USE OF DOCUMENTS:
APP EXPRESSLY RESERVES ITS
COPYRIGHT AND OTHER PROPERTY
RIGHTS OF ALL PLANS AND DRAWINGS
DESIGNED AND/OR PRODUCED. PLANS
AND DRAWINGS ARE NOT TO BE
REPRODUCED IN ANY FORM OR MANNER
WITHOUT THE EXPRESS WRITTEN
CONSENT OF AGP.








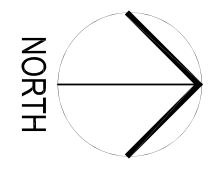
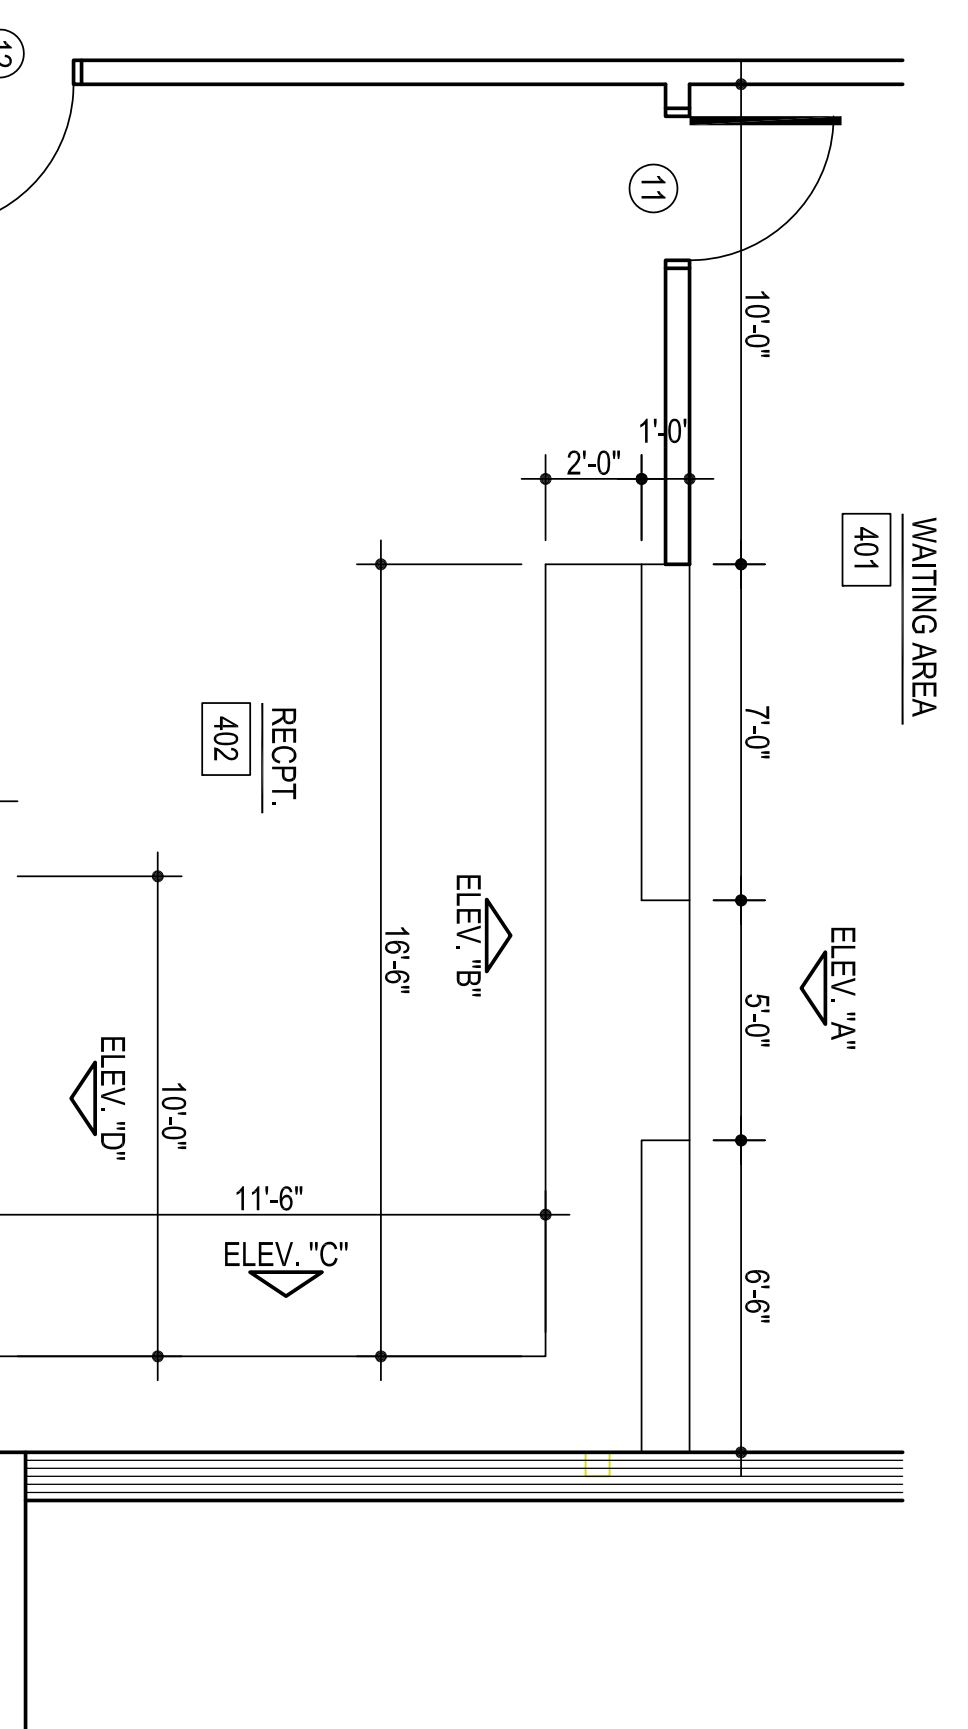


1
ENLARGED FLOOR PLAN ROOM #402, & 403
1/4" = 1'-0"

NOTE: CONTRACTOR TO VERIFY THAT THE MOUNTING HEIGHTS & MINIMUM CLEARANCES OF ALL WALL MOUNTED FIXTURES (I.E. PLUMBING FIXTURES, GRAB BARS, MIRRORS, ETC.) MEET ALL APPLICABLE CODES & STANDARDS PRIOR TO INSTALLATION.

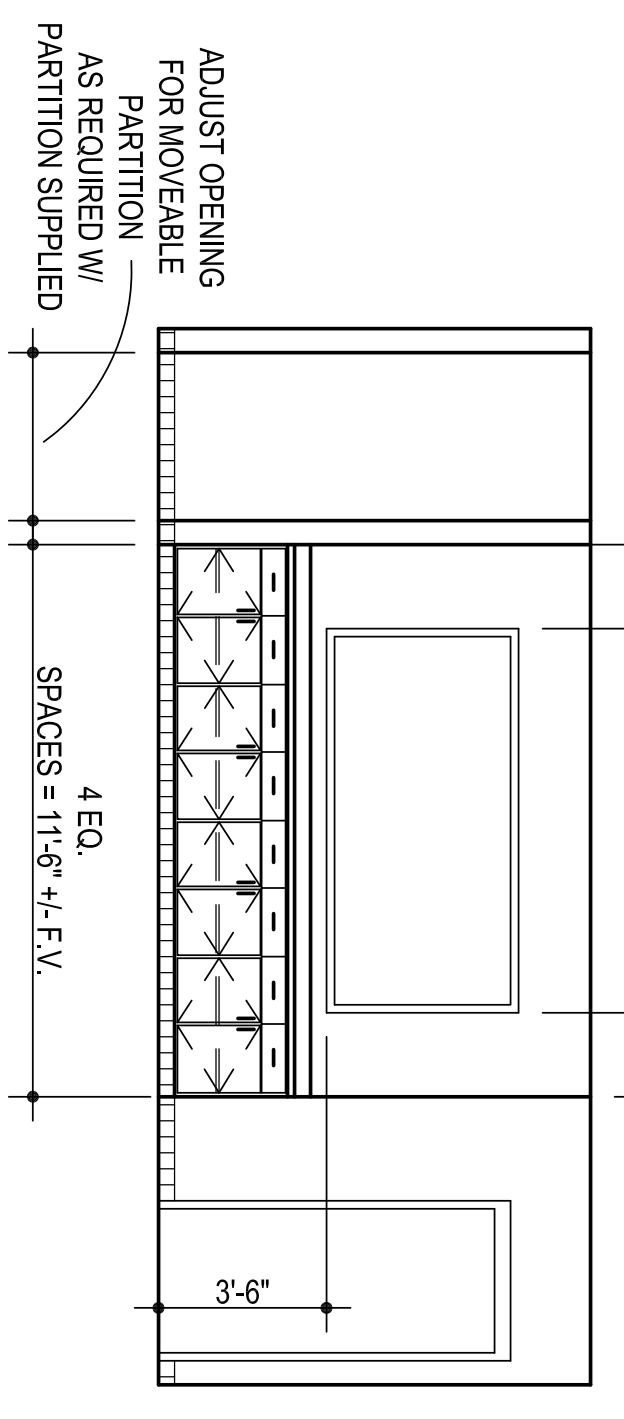

2
E. WALL ROOM #429
1/4" = 1'-0"

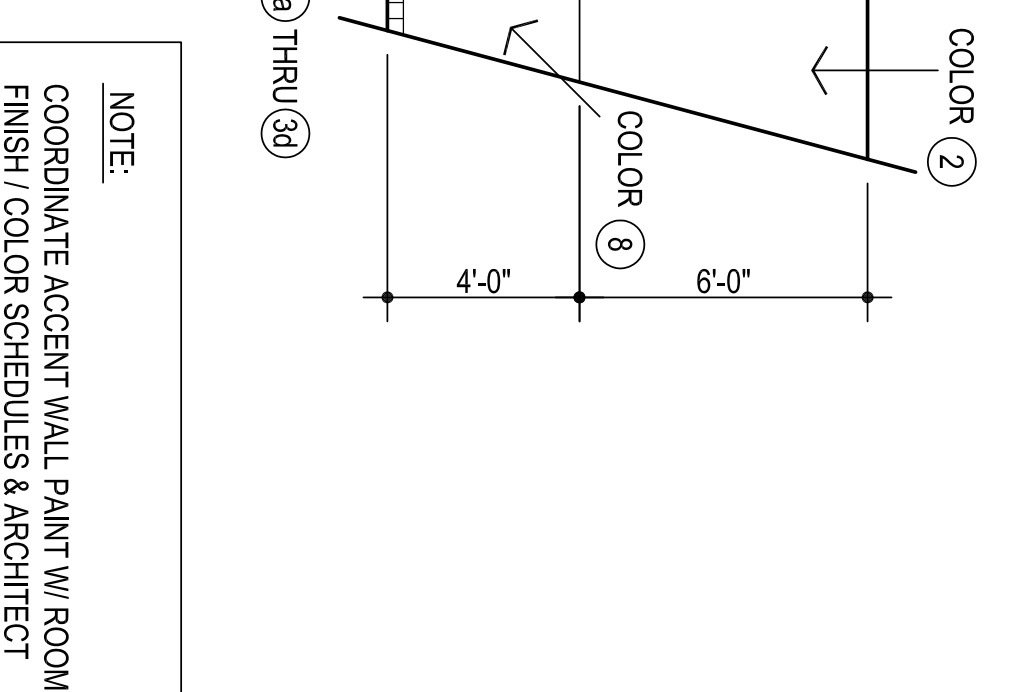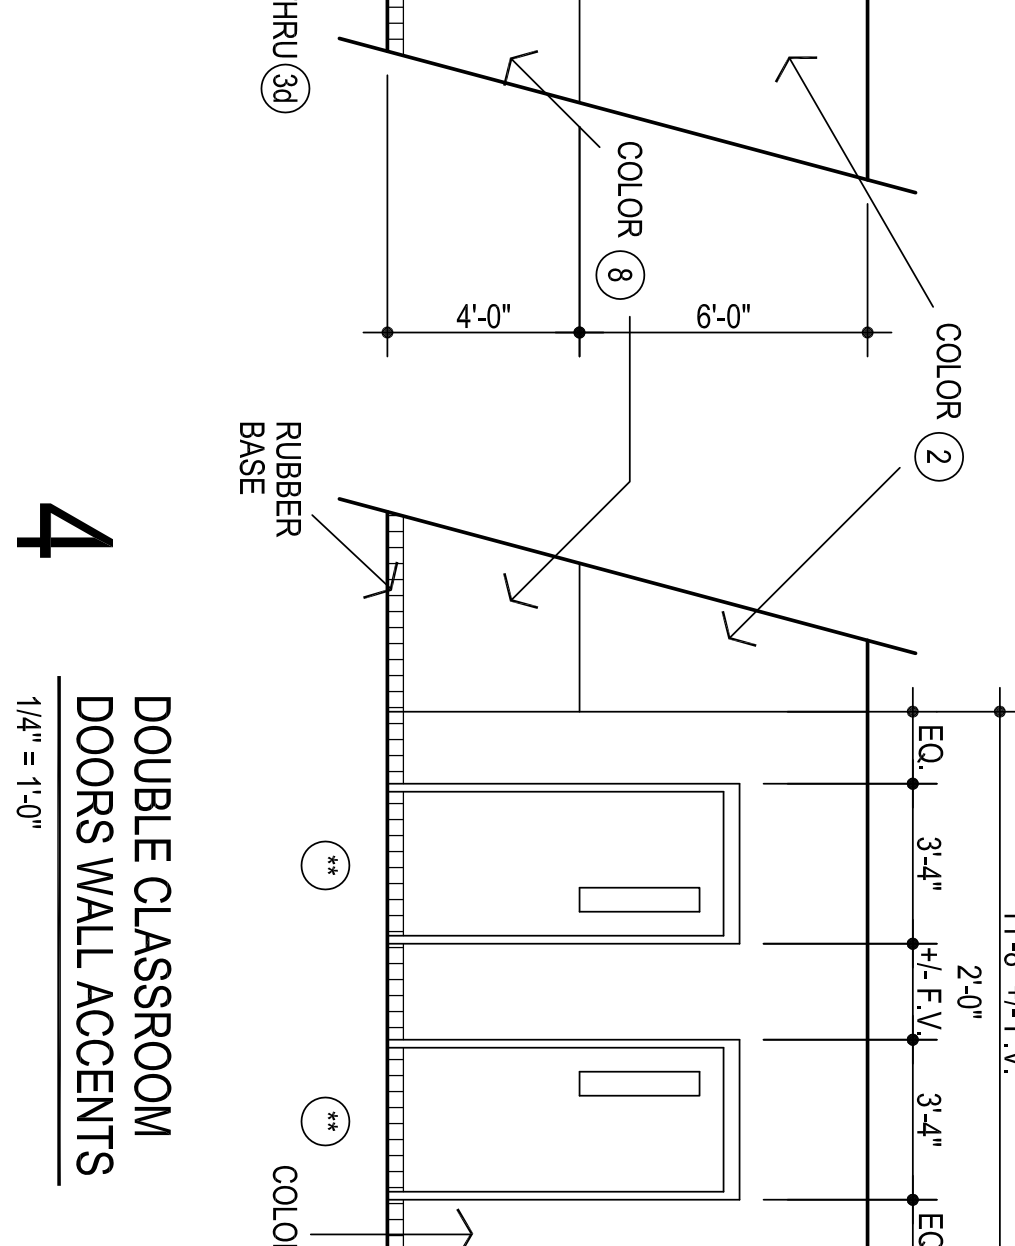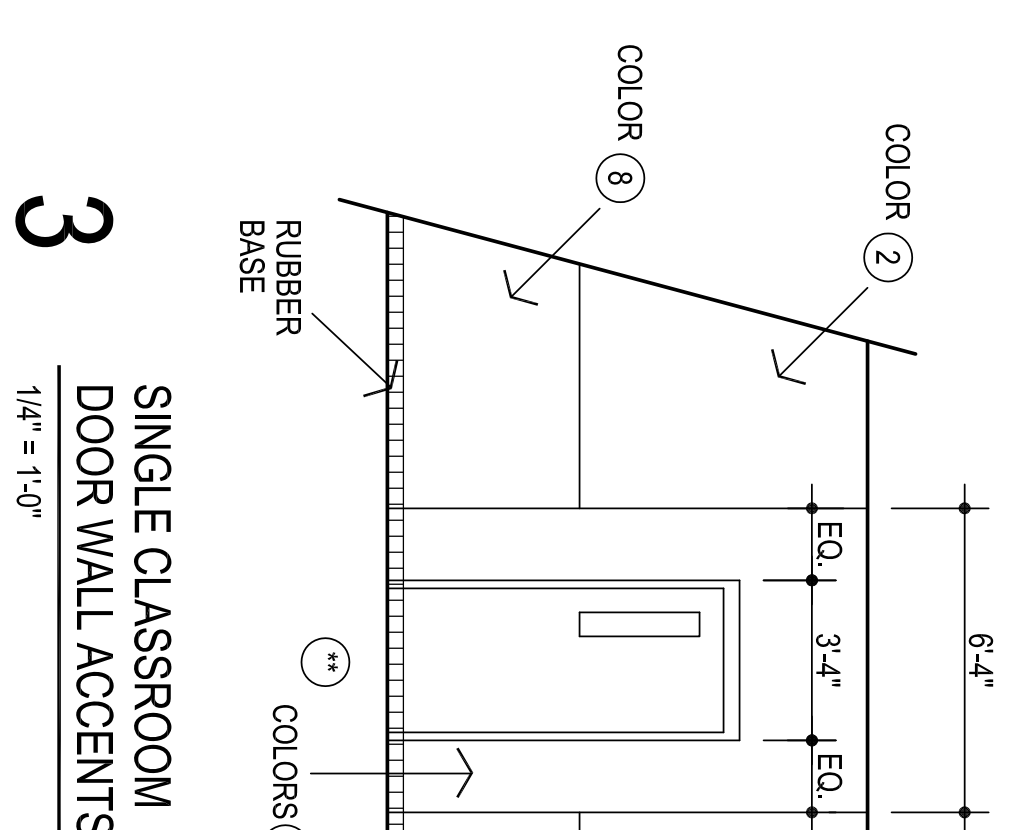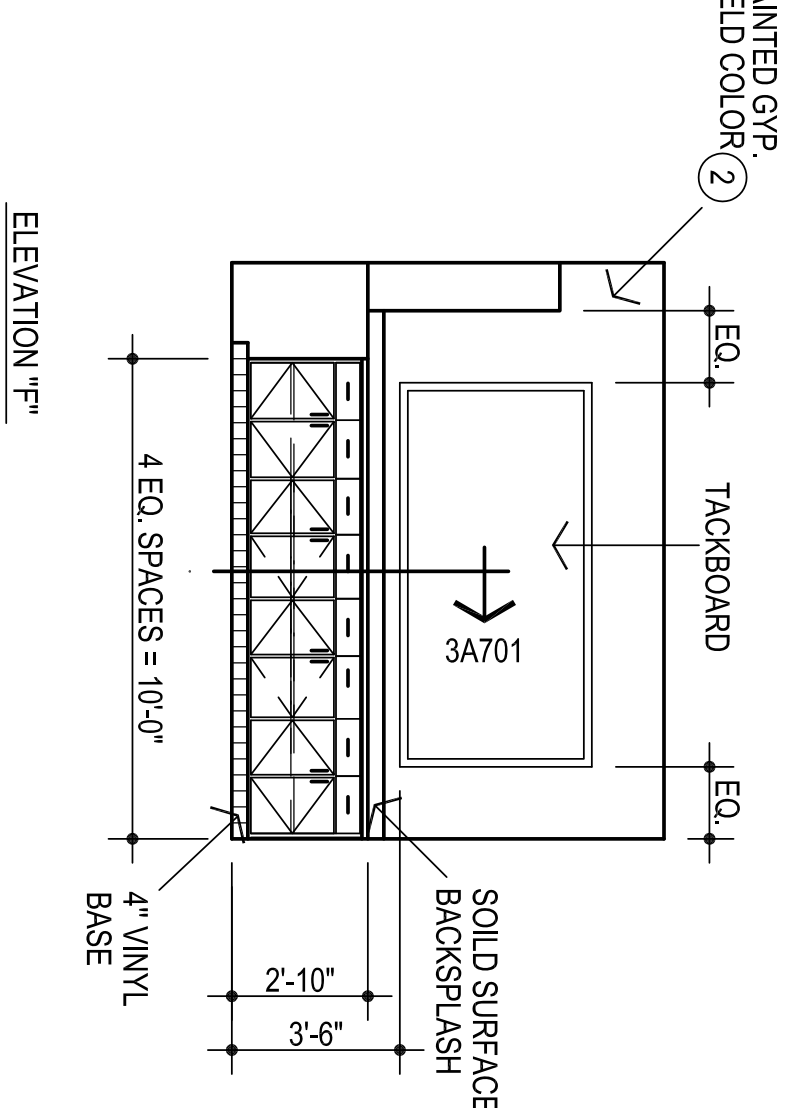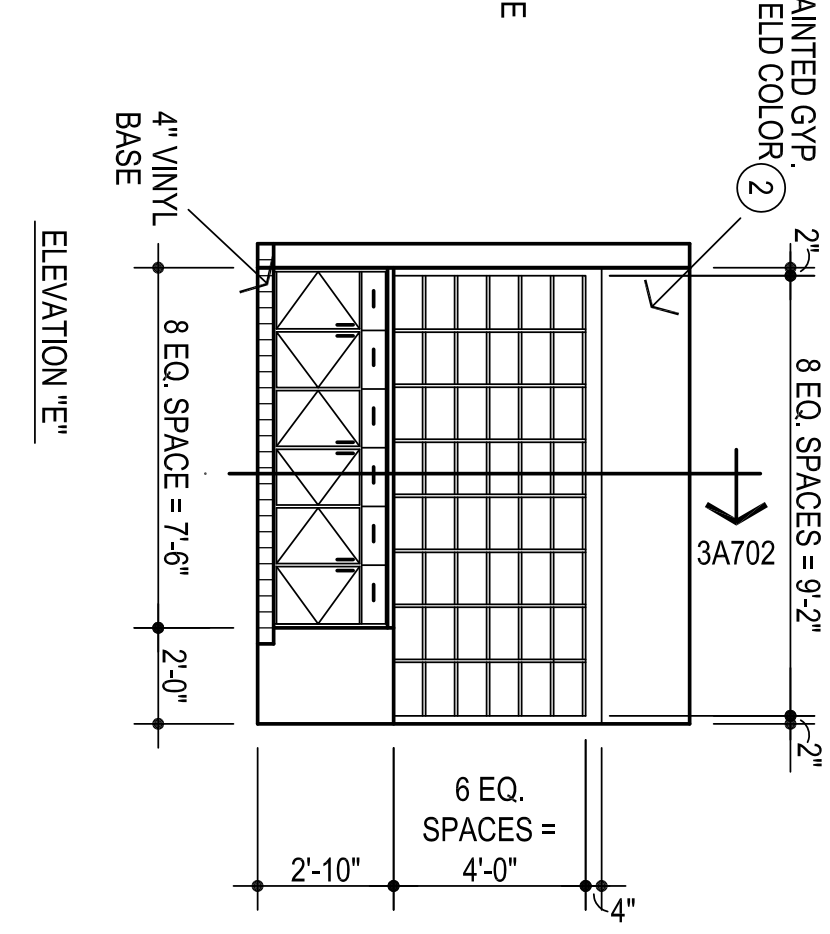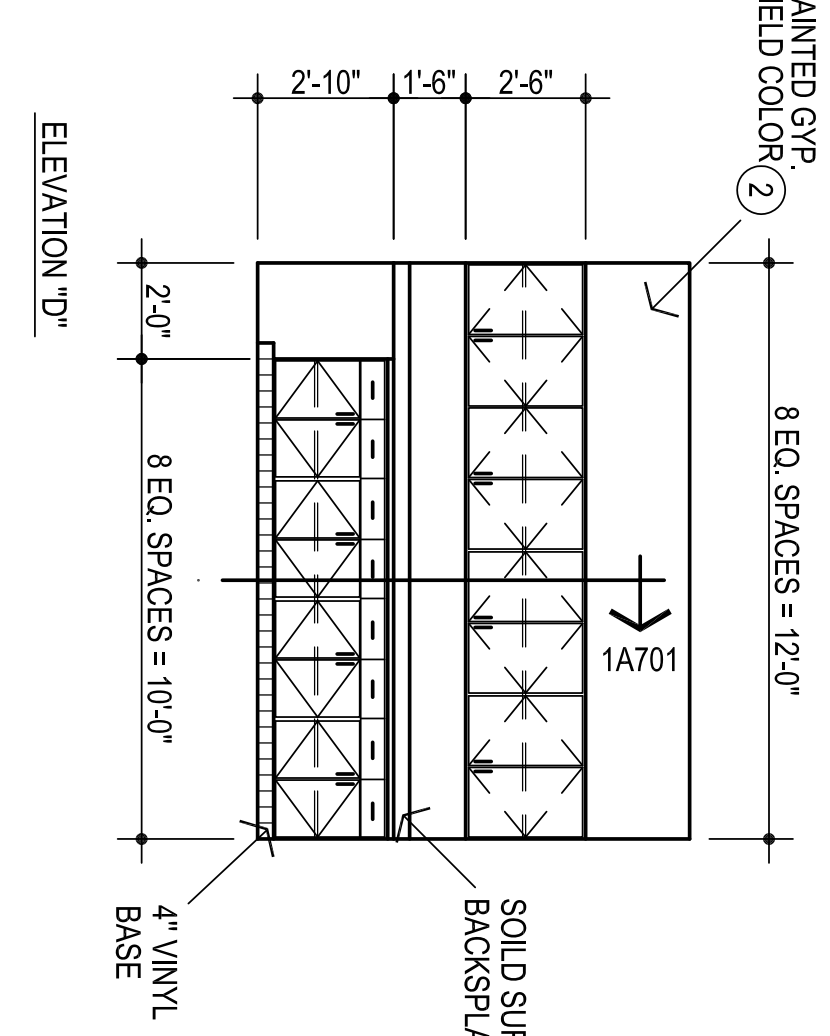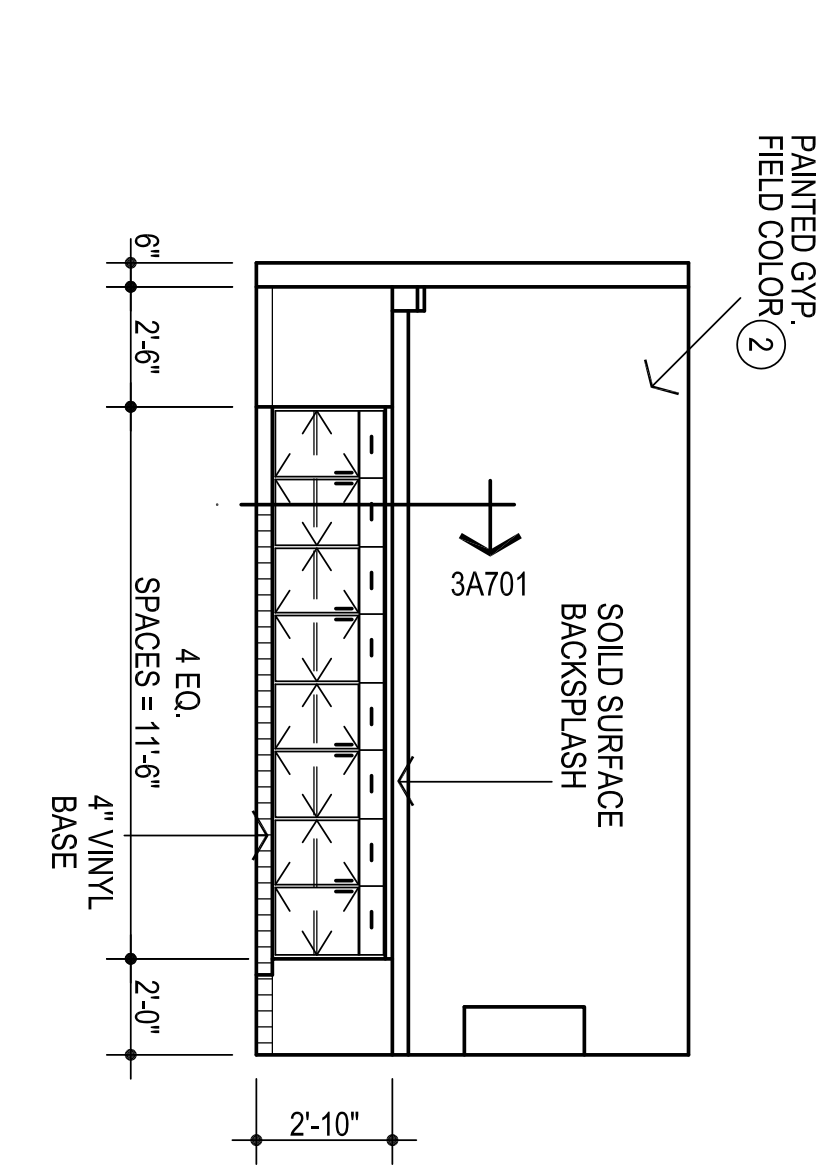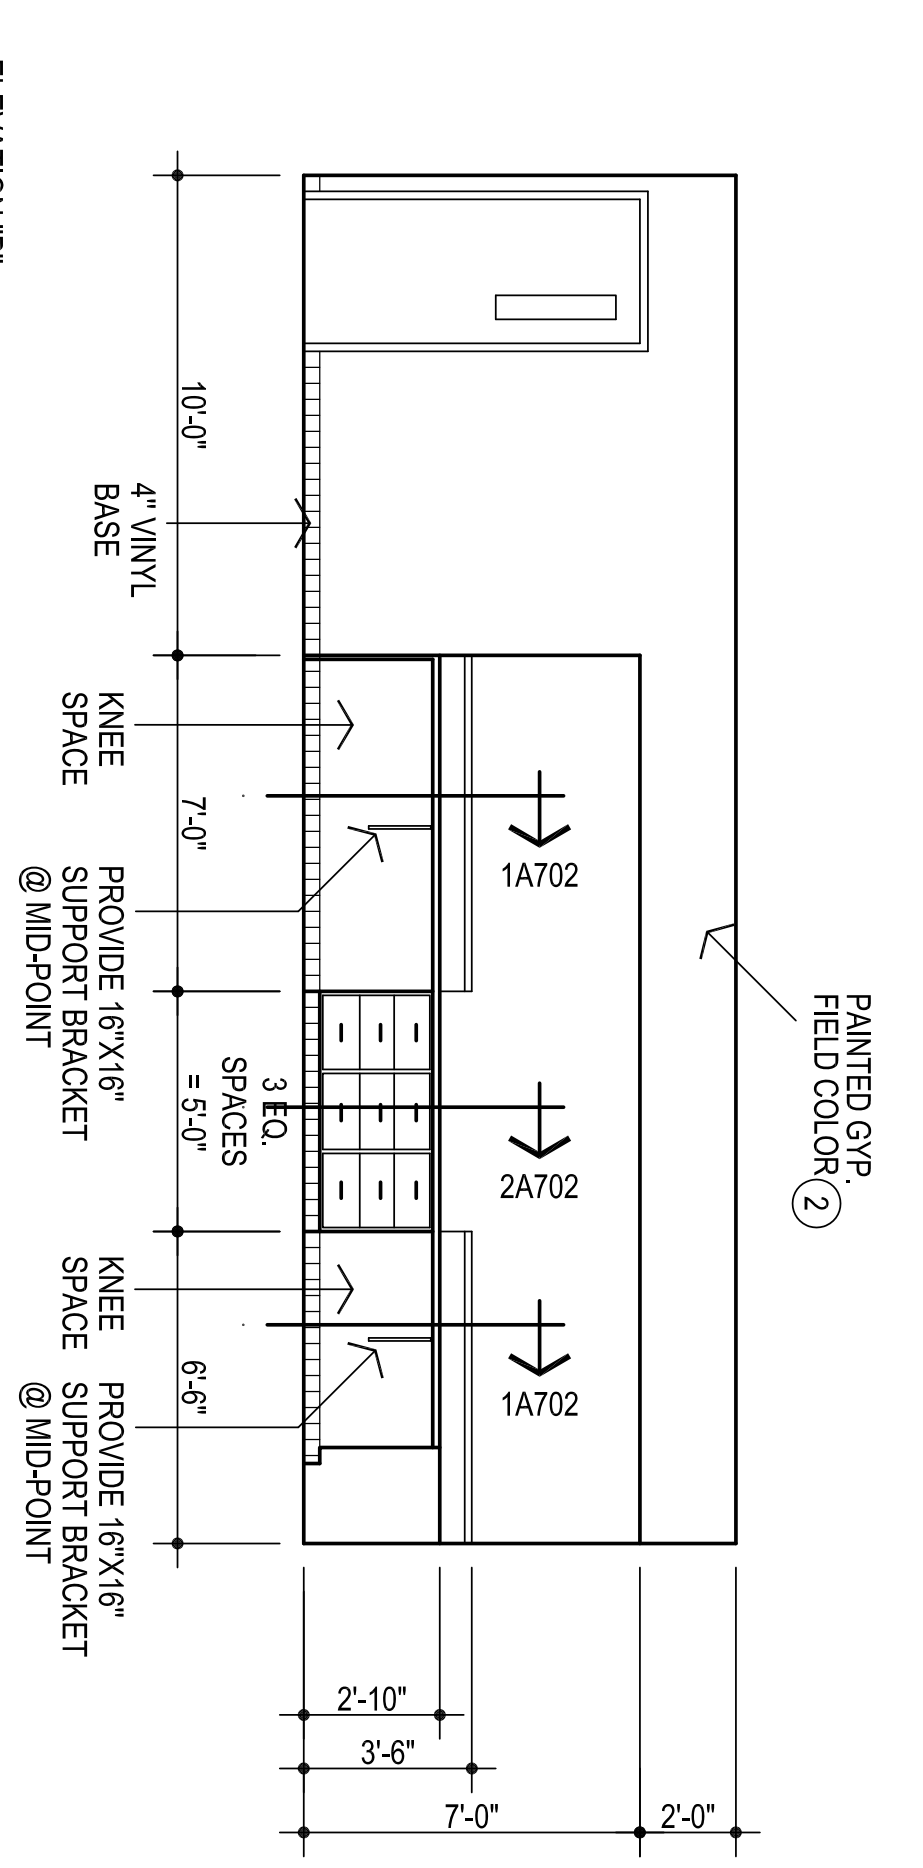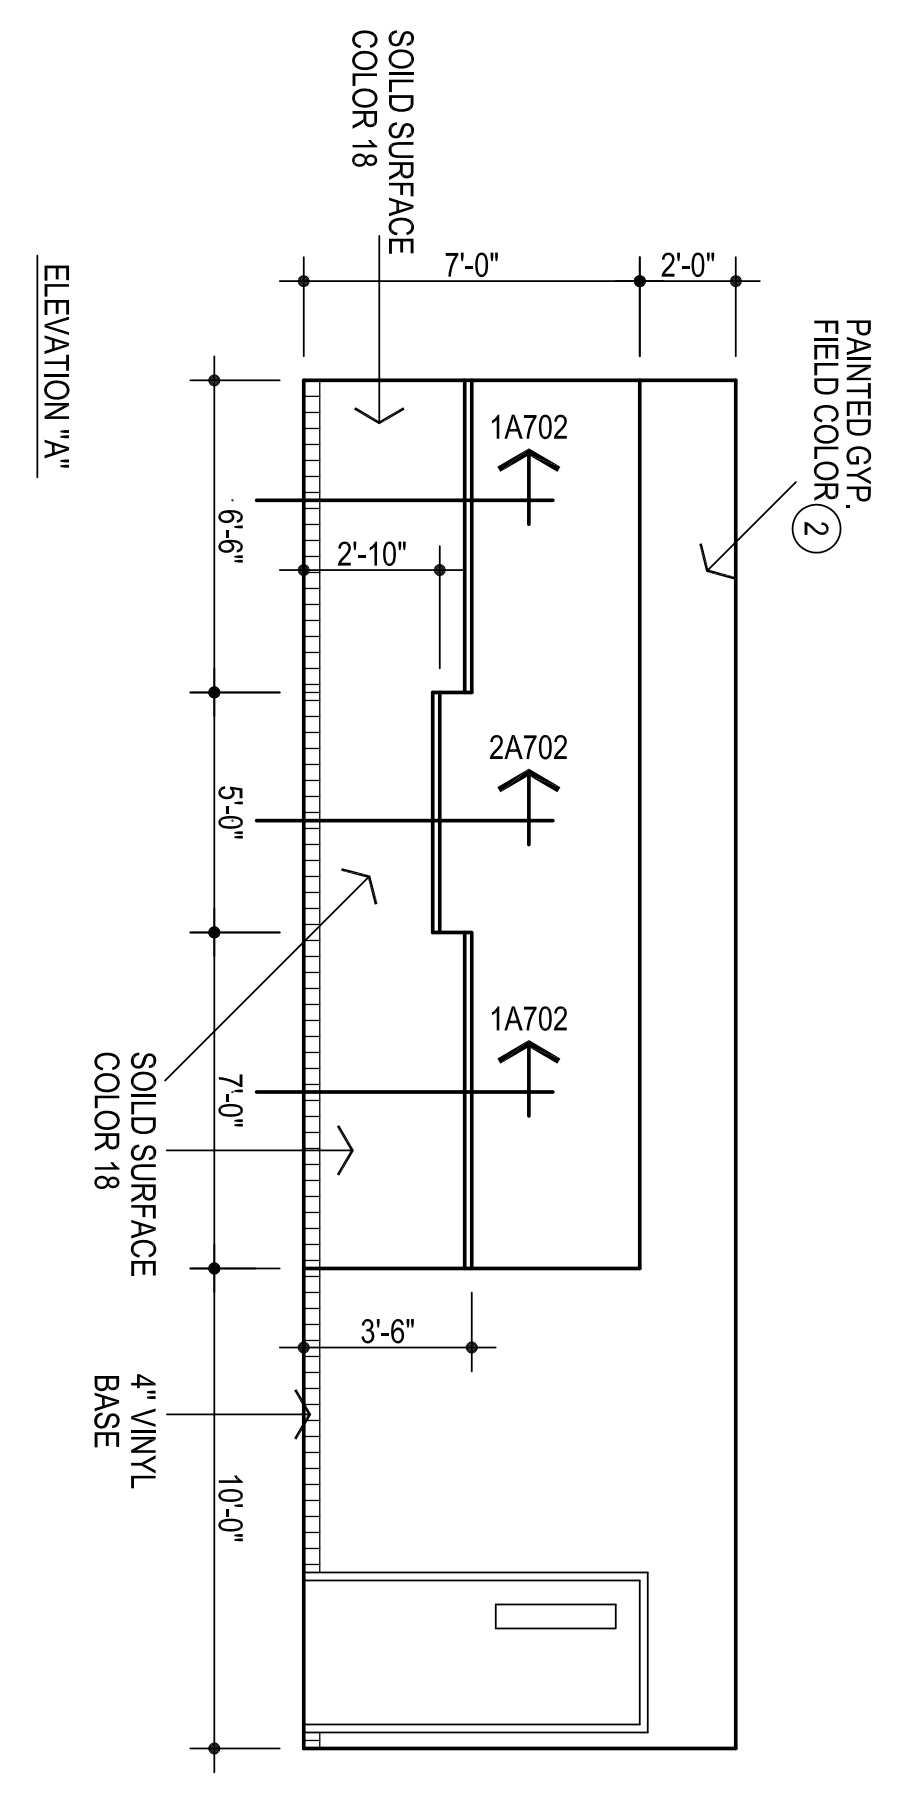

3
SINGLE CLASSROOM
DOOR WALL ACCENTS
1/4" = 1'-0"

4
DOUBLE CLASSROOM
DOOR WALL ACCENTS
1/4" = 1'-0"

NOTE:
COORDINATE ACCENT WALL PAINT W/ ROOM
FINISH / COLOR SCHEDULES & ARCHITECT