

| GENERAL NOTES |   |
|---------------|---|
| 1.            | COORDINATE INSTALLATION OF EQUIPMENT AND DUCTWORK WITH ALL TRADES.  |
| 2.            | COORDINATE LOCATION OF THERMOSTATS WITH E.C. ROUGH-IN BY E.C.   |
| 3.            | COORDINATE CARBON DIOXIDE SENSOR LOCATION WITH EARTHSMART PRIOR TO INSTALLATION.                                  |
| 4.            | FIELD VERIFY EXISTING CONDITIONS PRIOR TO COMMENCING WORK.  |
| 5.            | PROVIDE PIPE SLEEVES FOR ALL PIPE PENETRATIONS OF CONCRETE FLOORS, BELOW GRADE WALLS AND BEAMS.                   |
| 6.            | FIELD VERIFY LOCATION OF EXISTING WATER, NATURAL GAS, SANITARY SEWER AND STORM SEWER LINES PRIOR TO CONSTRUCTION. |



| KEYED NOTES |   |
|-------------|---|
| ①           | ROUTE CONDENSATE INTO NEAREST EXISTING BUILDING FURNACE CLOSET. TIE INTO EXISTING CONDENSATE LINE.  |
| ②           | FIELD VERIFY EXISTING 4" SANITARY SEWER PIPE MATERIAL PRIOR TO COMMENCING WORK. IF REQUIRED REPLACE PIPING UNDER NEW BUILDING ADDITION WITH PVC RATED FOR UNDER BUILDING FLOOR. |
| ③           | DUCT UP TO 8X24 OPENING IN ROOF HOOD.   |

RK  
drawn by  
DMG  
checked by  
APRIL 2023  
date  
revisions


MOORE PUBLIC SCHOOLS  
BOARD OF EDUCATION  
MOORE, OKLAHOMA



OFFICE  
ADDITION -  
NORTHMOOR  
ELEMENTARY SCHOOL

sheet no:

**M101**

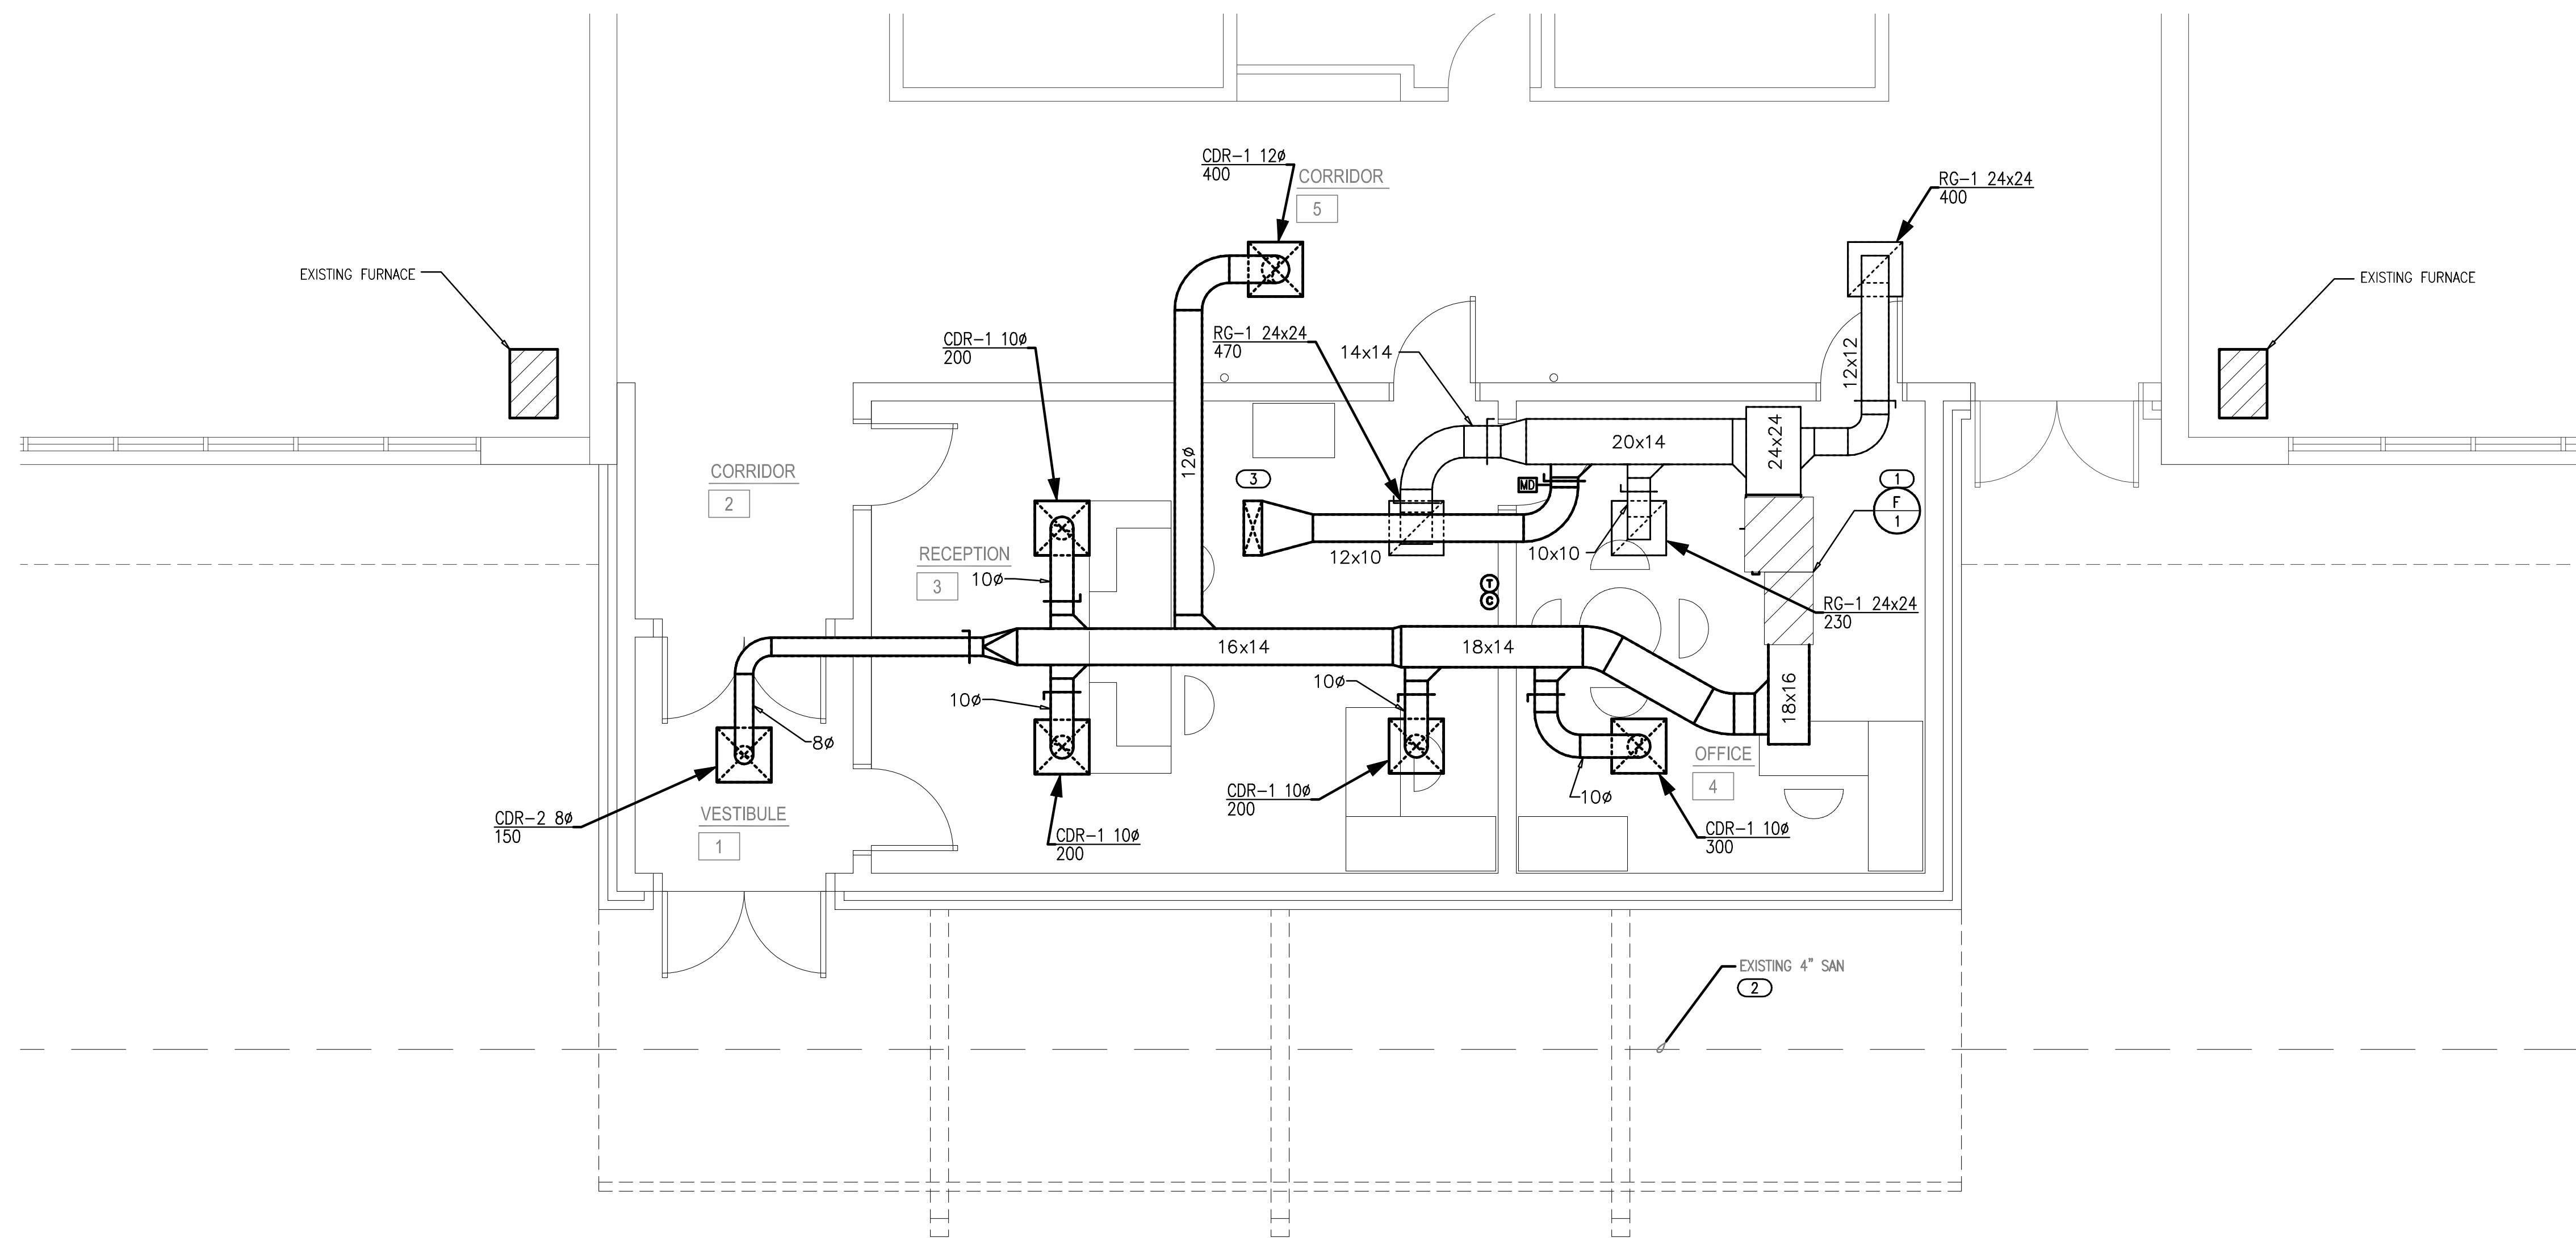

**1 MECHANICAL DUCTWORK PLAN - FLOOR**  
SCALE: 1/4" = 1'-0"



**Salas O'Brien**  
2800 Van Buren St., Suite 2635  
Norman, OK 73072  
Salas O'Brien Registration: CA# 7058  
Expiration Date: 6/30/2023  
Salas O'Brien Project Number: 2023-01177-00

OWNERSHIP USE OF DOCUMENTS:  
AGP EXPRESSLY RESERVES ITS  
COPYRIGHT AND OTHER PROPERTY  
RIGHTS OF ALL PLANS AND DRAWINGS  
DESIGNED AND/OR PRODUCED. PLANS  
AND DRAWINGS ARE NOT TO BE  
REPRODUCED IN ANY FORM OR MANNER  
WITHOUT THE EXPRESSED WRITTEN  
CONSENT OF AGP.