

**MOORE PUBLIC SCHOOLS -
OLD SCHOOL REPLACEMENT**


Moore Public Schools - Moore, Oklahoma
AGP - Moore, Oklahoma

CONSTRUCTION BULLETIN NO. 4

August 18, 2026

1. UPDATED / REVISED ELEVATOR SHAFT DIMENSIONS TO MATCH THE SHOP DRAWINGS. REFER TO ATTACHED REVISED SHEETS S201, S301, S302, A102, A103, A106, A108, & A304.


END OF CONSTRUCTION BULLETIN NO. 4

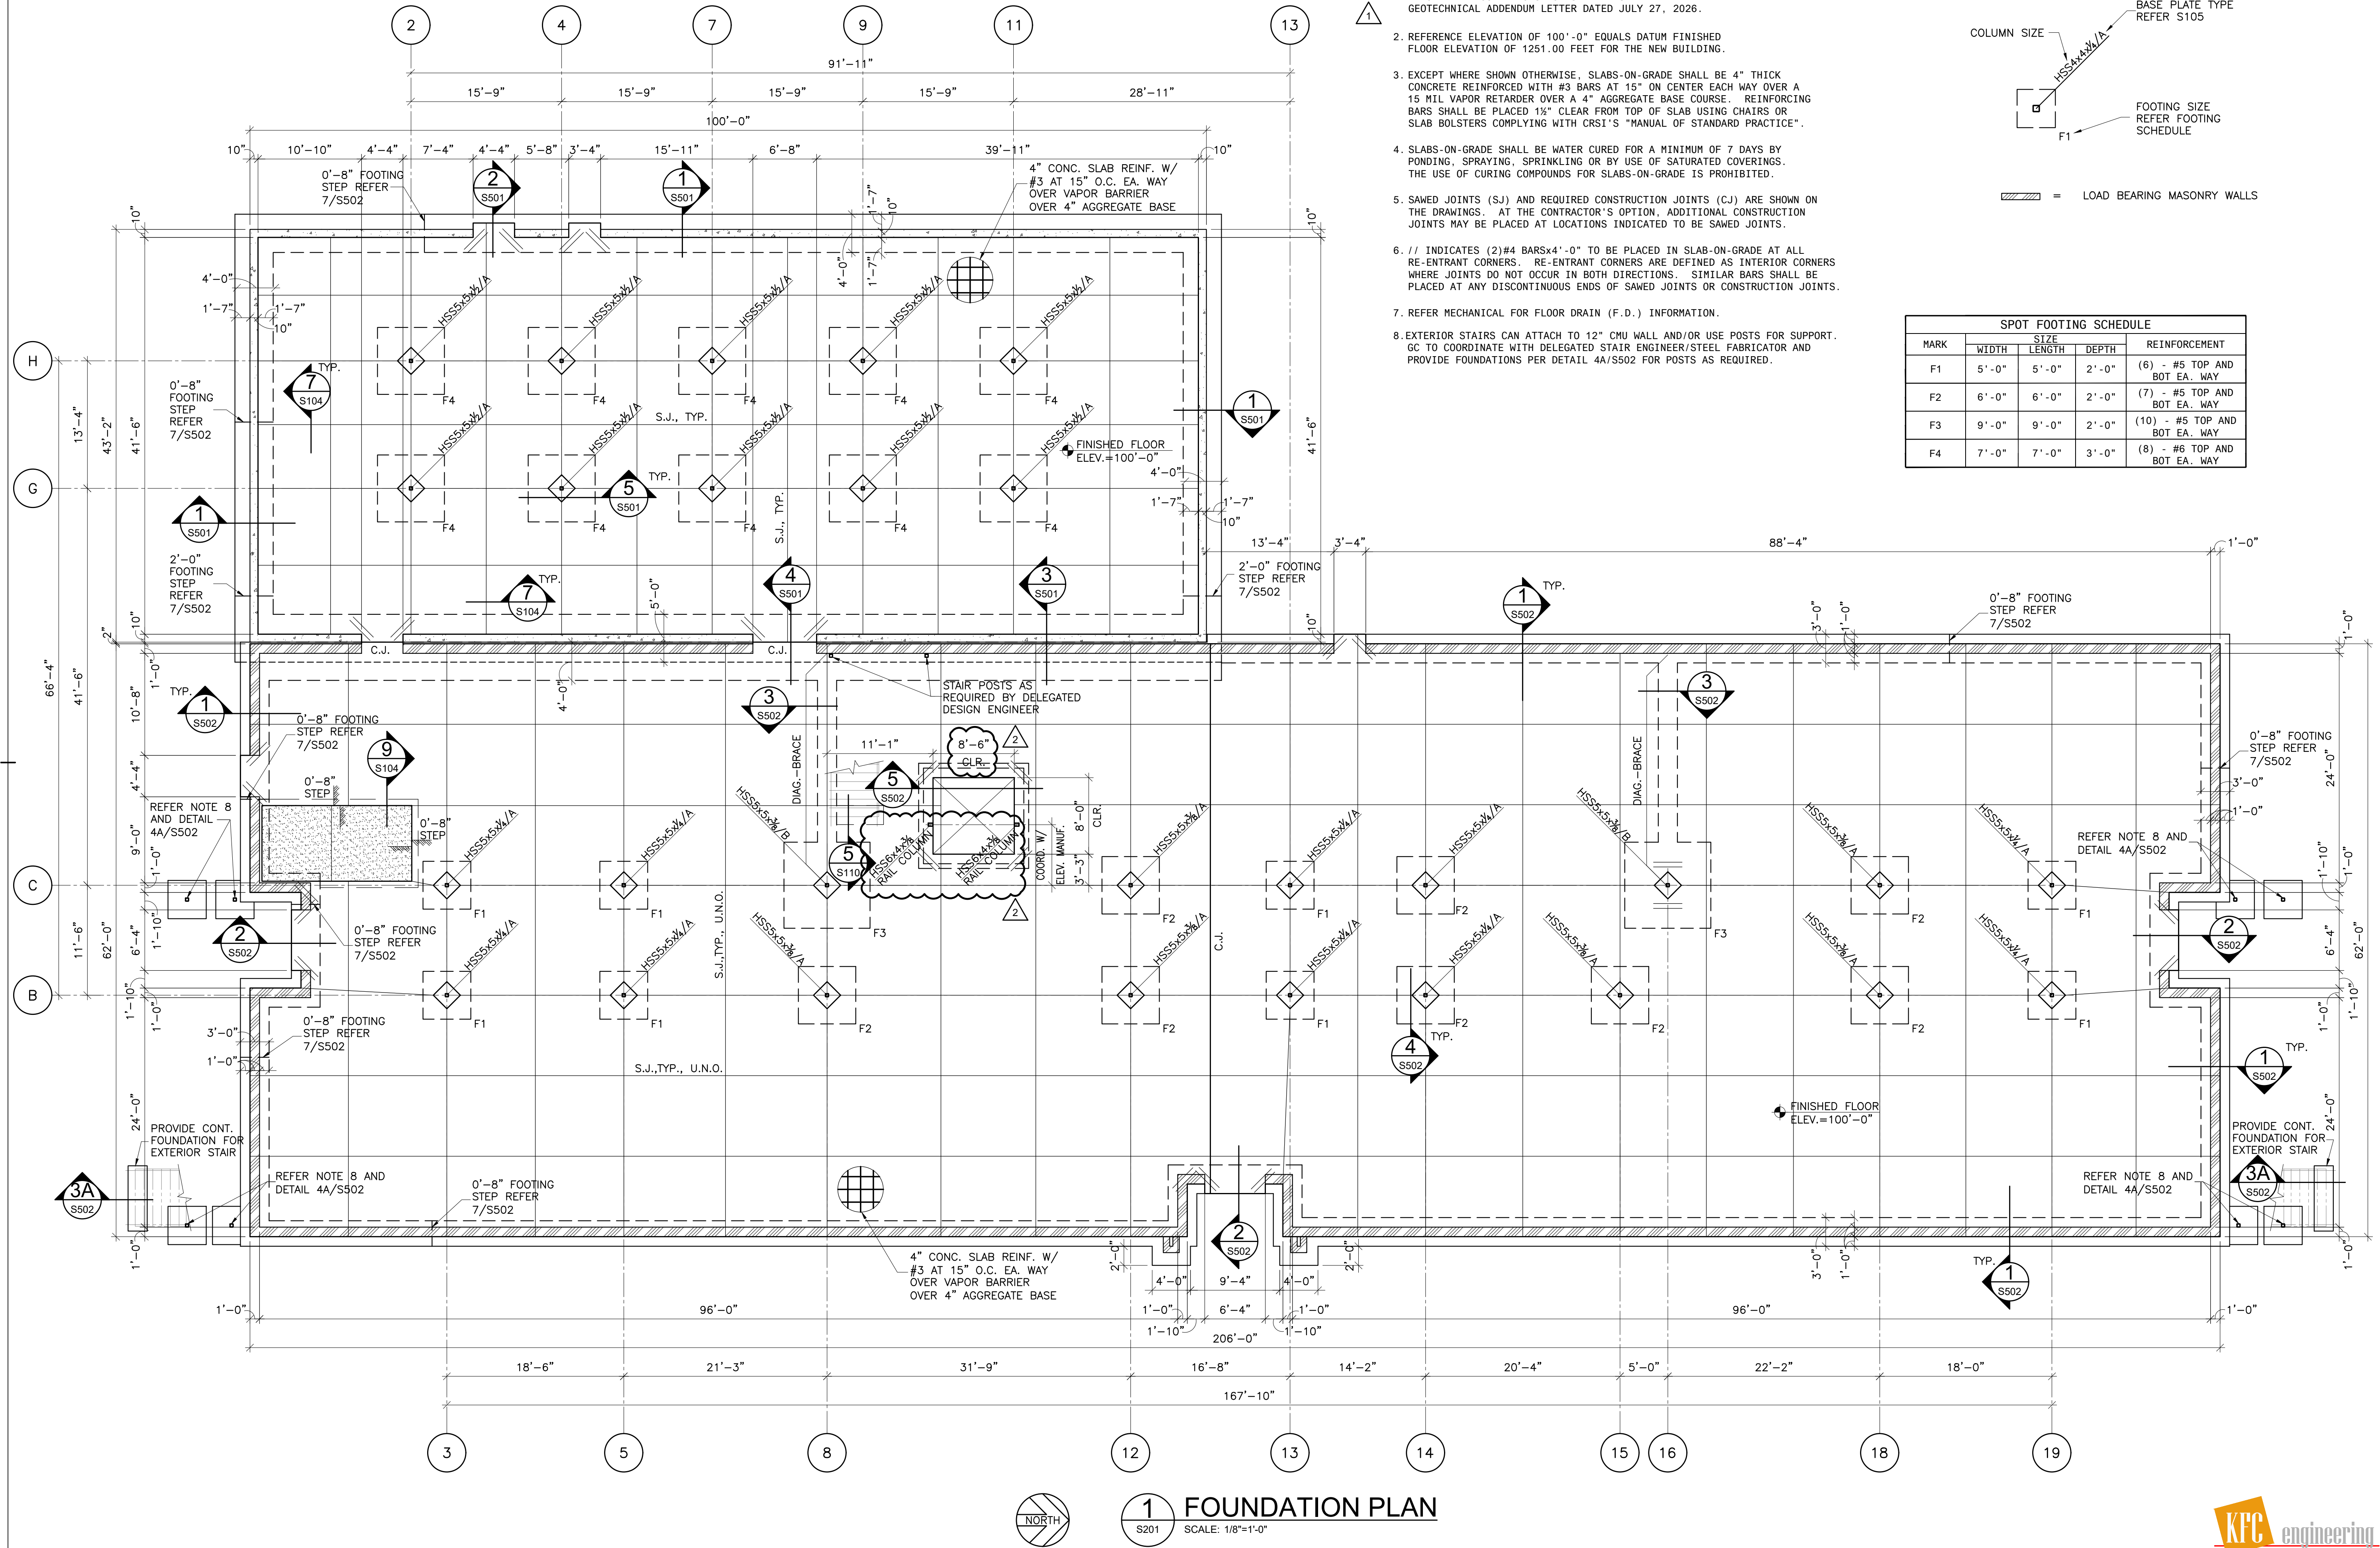

FOUNDATION PLAN NOTES:

1. FOUNDATION AND SLAB SUBGRADE SHALL BE PREPARED AS OUTLINED IN THE STRUCTURAL GENERAL NOTES. EXISTING BASEMENT SHALL BE PREPARED PER DEEP FILL RECOMMENDATIONS IN THE GEOTECHNICAL REPORT AND FOUNDATIONS FOR SHELTER SHALL BE PREPARED PER GEOTECHNICAL ADDENDUM LETTER DATED JULY 27, 2026.
2. REFERENCE ELEVATION OF 100'-0" EQUALS DATUM FINISHED FLOOR ELEVATION OF 1251.00 FEET FOR THE NEW BUILDING.
3. EXCEPT WHERE SHOWN OTHERWISE, SLABS-ON-GRADE SHALL BE 4" THICK CONCRETE REINFORCED WITH #3 BARS AT 15" ON CENTER EACH WAY OVER A 15 MIL VAPOR RETARDER OVER A 4" AGGREGATE BASE COURSE. REINFORCING BARS SHALL BE PLACED 1 1/2" CLEAR FROM TOP OF SLAB USING CHAIRS OR SLAB BOLSTERS COMPLYING WITH CRSI'S "MANUAL OF STANDARD PRACTICE".
4. SLABS-ON-GRADE SHALL BE WATER CURED FOR A MINIMUM OF 7 DAYS BY PONDING, SPRAYING, SPRINKLING OR BY USE OF SATURATED COVERINGS. THE USE OF CURING COMPOUNDS FOR SLABS-ON-GRADE IS PROHIBITED.
5. SAWED JOINTS (S.J.) AND REQUIRED CONSTRUCTION JOINTS (C.J.) ARE SHOWN ON THE DRAWINGS. AT THE CONTRACTOR'S OPTION, ADDITIONAL CONSTRUCTION JOINTS MAY BE PLACED AT LOCATIONS INDICATED TO BE SAWED JOINTS.
6. // INDICATES (2)#4 BARSx4'-0" TO BE PLACED IN SLAB-ON-GRADE AT ALL RE-ENTRANT CORNERS. RE-ENTRANT CORNERS ARE DEFINED AS INTERIOR CORNERS WHERE JOINTS DO NOT OCCUR IN BOTH DIRECTIONS. SIMILAR BARS SHALL BE PLACED AT ANY DISCONTINUOUS ENDS OF SAWED JOINTS OR CONSTRUCTION JOINTS.
7. REFER MECHANICAL FOR FLOOR DRAIN (F.D.) INFORMATION.
8. EXTERIOR STAIRS CAN ATTACH TO 12" CMU WALL AND/OR USE POSTS FOR SUPPORT. GC TO COORDINATE WITH DELEGATED STAIR ENGINEER/STEEL FABRICATOR AND PROVIDE FOUNDATIONS PER DETAIL 4A/S502 FOR POSTS AS REQUIRED.

FOUNDATION PLAN LEGEND:

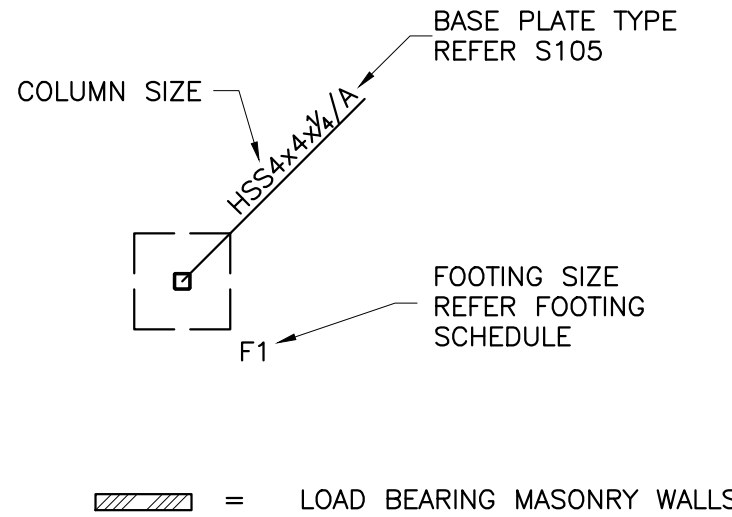


MARK	SIZE			REINFORCEMENT
	WIDTH	LENGTH	DEPTH	
F1	5'-0"	5'-0"	2'-0"	(6) - #5 TOP AND BOT EA. WAY
F2	6'-0"	6'-0"	2'-0"	(7) - #5 TOP AND BOT EA. WAY
F3	9'-0"	9'-0"	2'-0"	(10) - #5 TOP AND BOT EA. WAY
F4	7'-0"	7'-0"	3'-0"	(8) - #6 TOP AND BOT EA. WAY



CC
drawn by
BB
checked by
NOVEMBER 2025
date

revisions
1 CB #1 07/29/2026
2 CB #4 08/14/2026

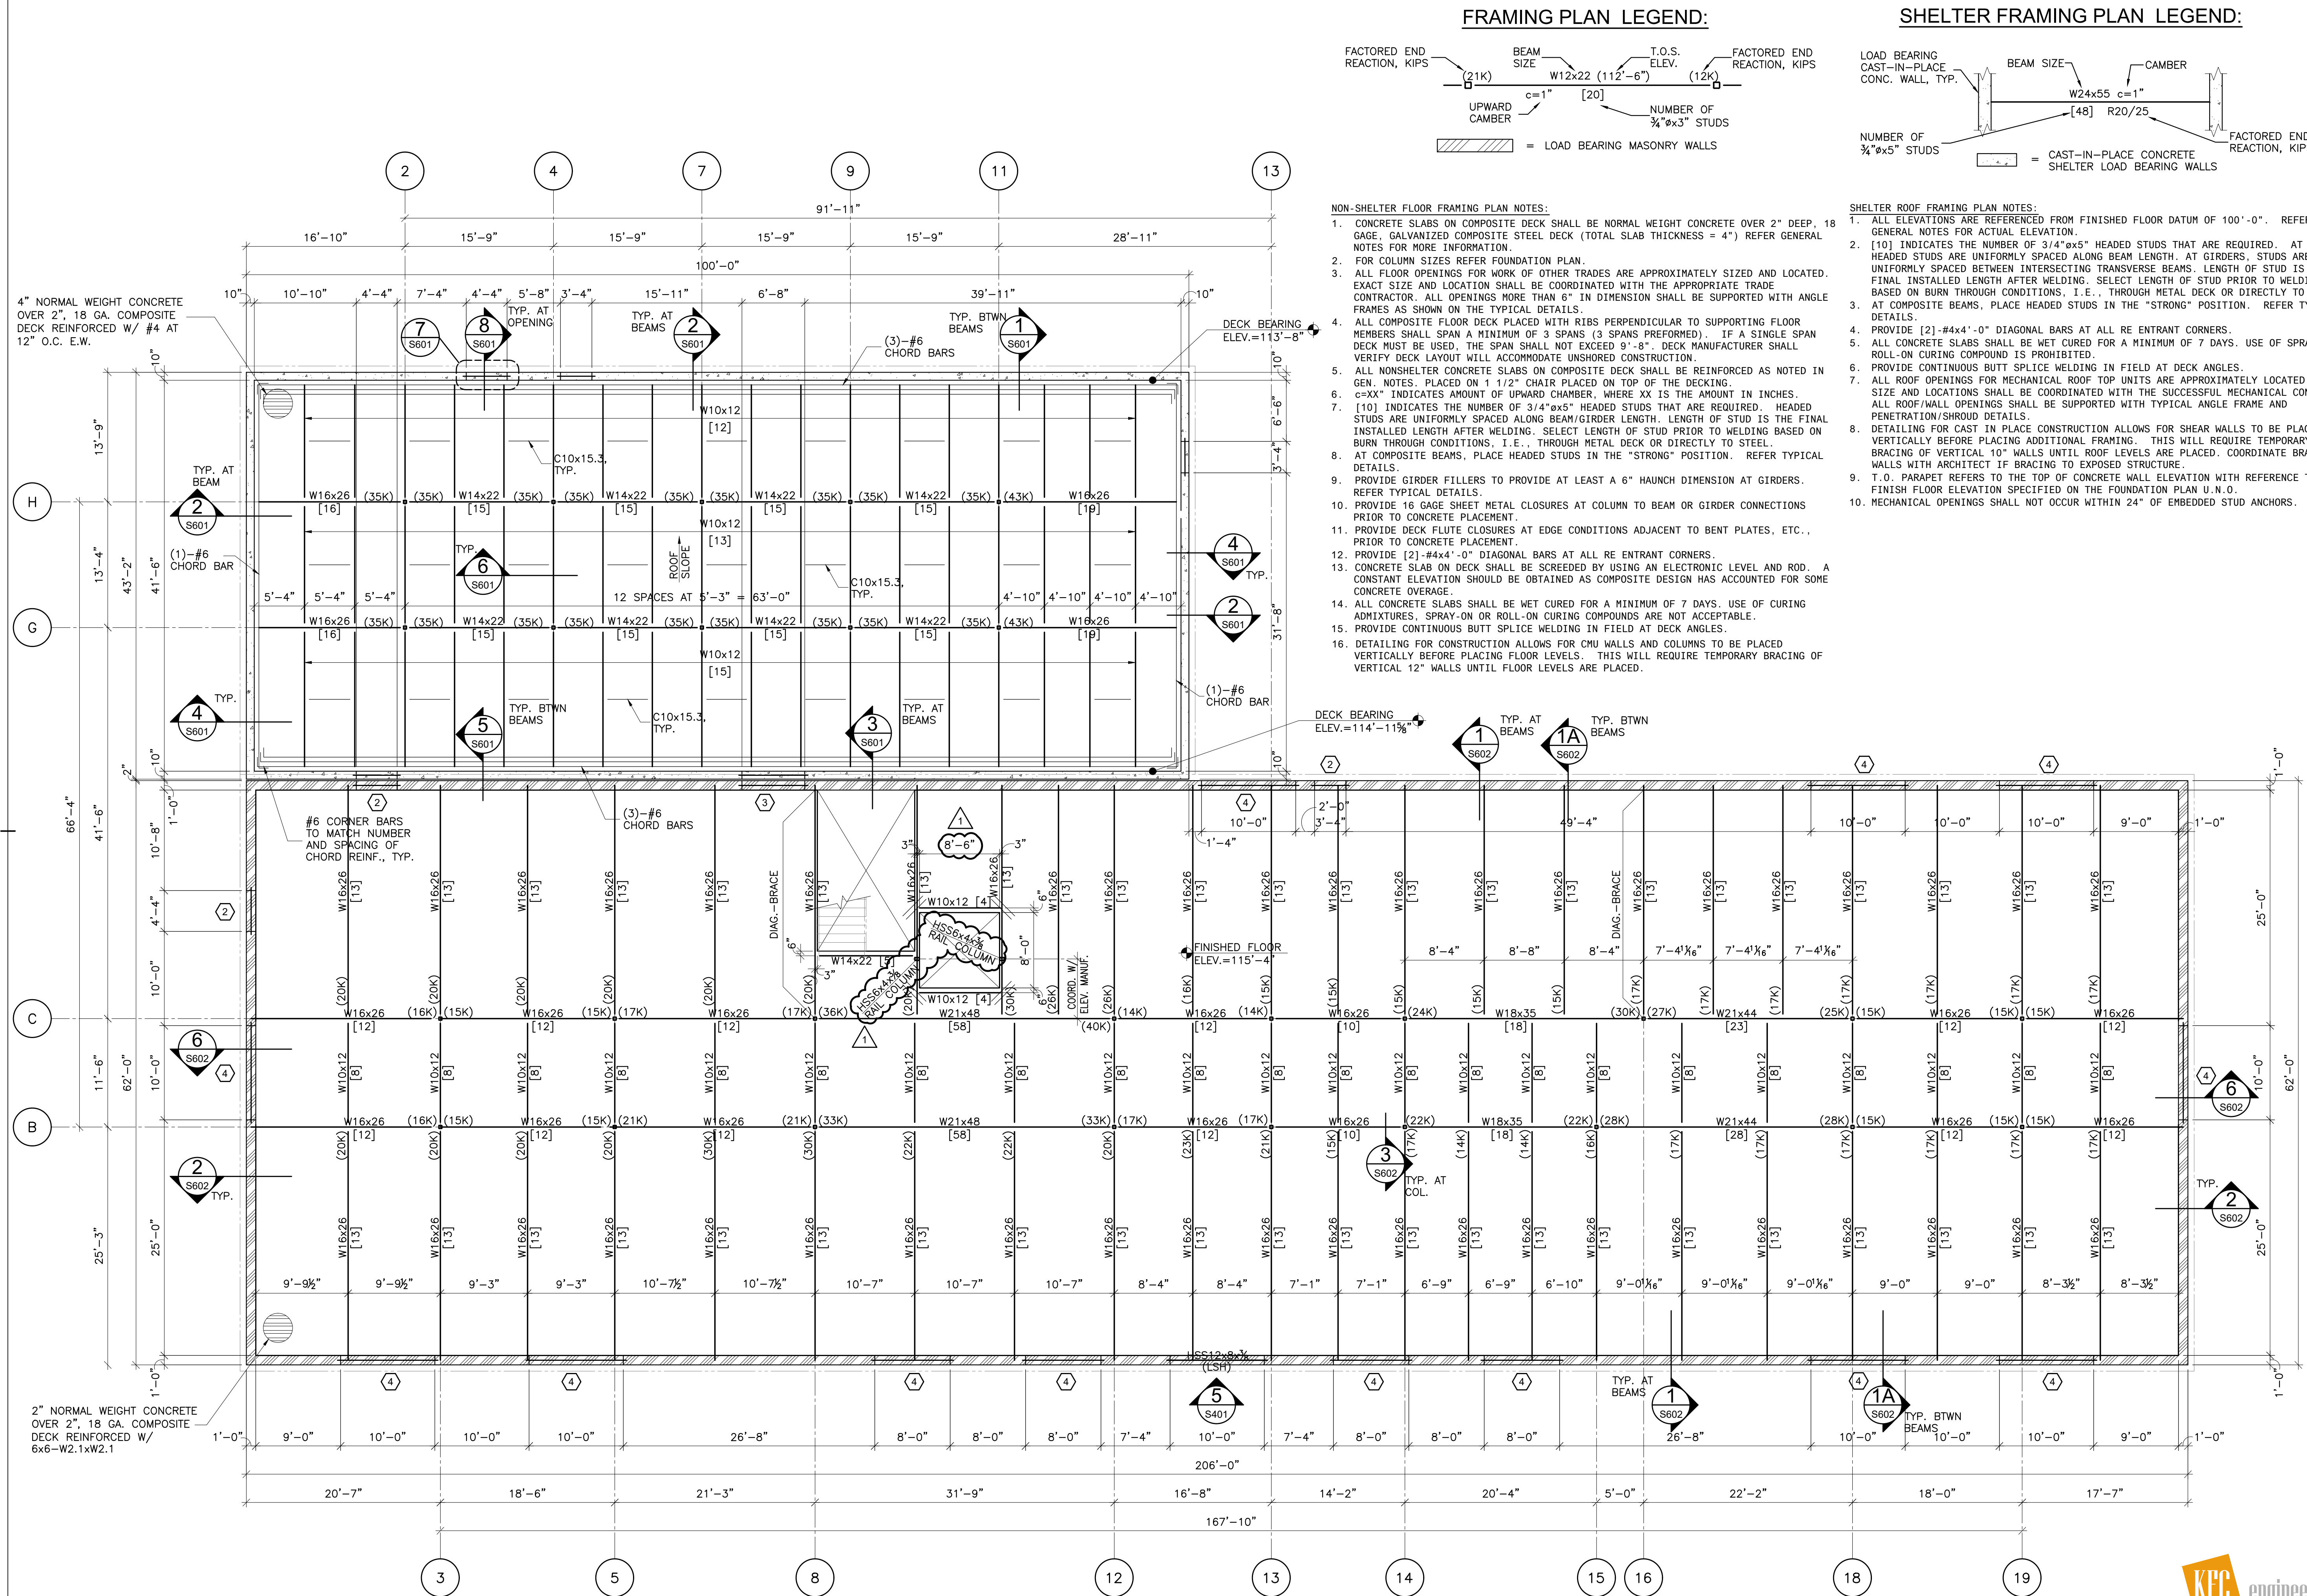

CC	drawn by
BB	checked by
NOVEMBER 2025	date
revisions	
1	CB #4 08/14/2026





CC	drawn by
BB	checked by
NOVEMBER 2025	date

revisions
1 CB #4 08/14/2026



OLD SCHOOL
UPGRADES

sheet no:


S302

OWNERSHIP USE OF DOCUMENTS:


AGP EXPRESSLY RESERVES ITS
COPYRIGHT AND OTHER PROPERTY
RIGHTS OF ALL PLANS AND DRAWINGS
DESIGNED AND/OR PRODUCED. PLANS
AND DRAWINGS ARE NOT TO BE
REPRODUCED IN ANY FORM OR MANNER
WITHOUT THE EXPRESSED WRITTEN
CONSENT OF AGP.



ROOF FRAMING PLAN LEGEND:

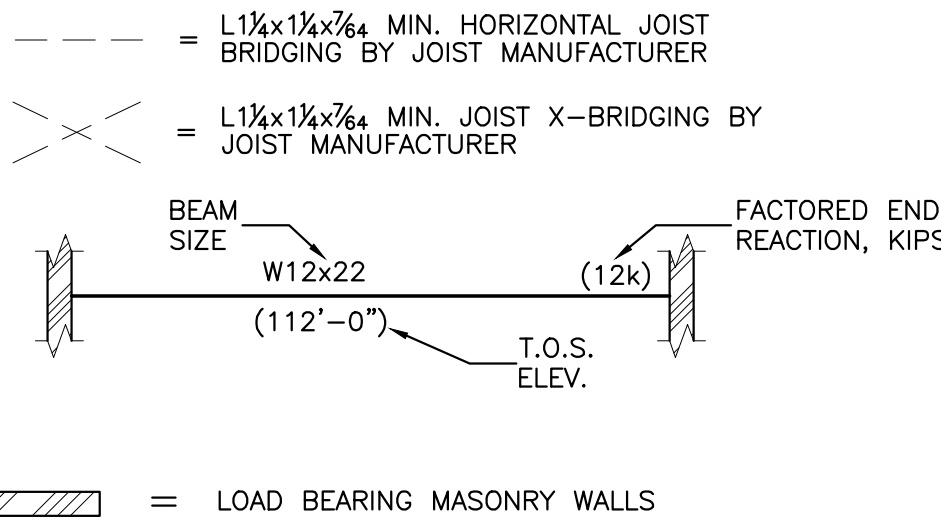

- ROOF FRAMING PLAN NOTES:
- ALL ELEVATIONS ARE REFERENCED FROM FINISHED FLOOR DATUM OF 100'-0". REFER GENERAL NOTES FOR ACTUAL ELEVATION.
 - ALL ROOF OPENINGS FOR MECHANICAL ROOF TOP UNITS ARE APPROXIMATELY LOCATED. EXACT SIZE AND LOCATIONS SHALL BE COORDINATED WITH THE SUCCESSFUL MECHANICAL CONTRACTOR. ALL ROOF/WALL OPENINGS SHALL BE SUPPORTED WITH TYPICAL ANGLE FRAME UNLESS NOTED OTHERWISE.
 - T.O. PARAPET REFERS TO THE TOP OF MASONRY WALL ELEVATION WITH REFERENCE TO FINISH FLOOR ELEVATION SPECIFIED ON THE FOUNDATION PLAN U.N.O.
 - ① DENOTES MASONRY LINTEL TYPE. REFER TYPICAL MASONRY DETAILS FOR ADDITIONAL INFORMATION.
 - OFFSET STEEL JOISTS AS REQUIRED FOR CODE REQUIRED MINIMUM BEARING ON STEEL BEAMS

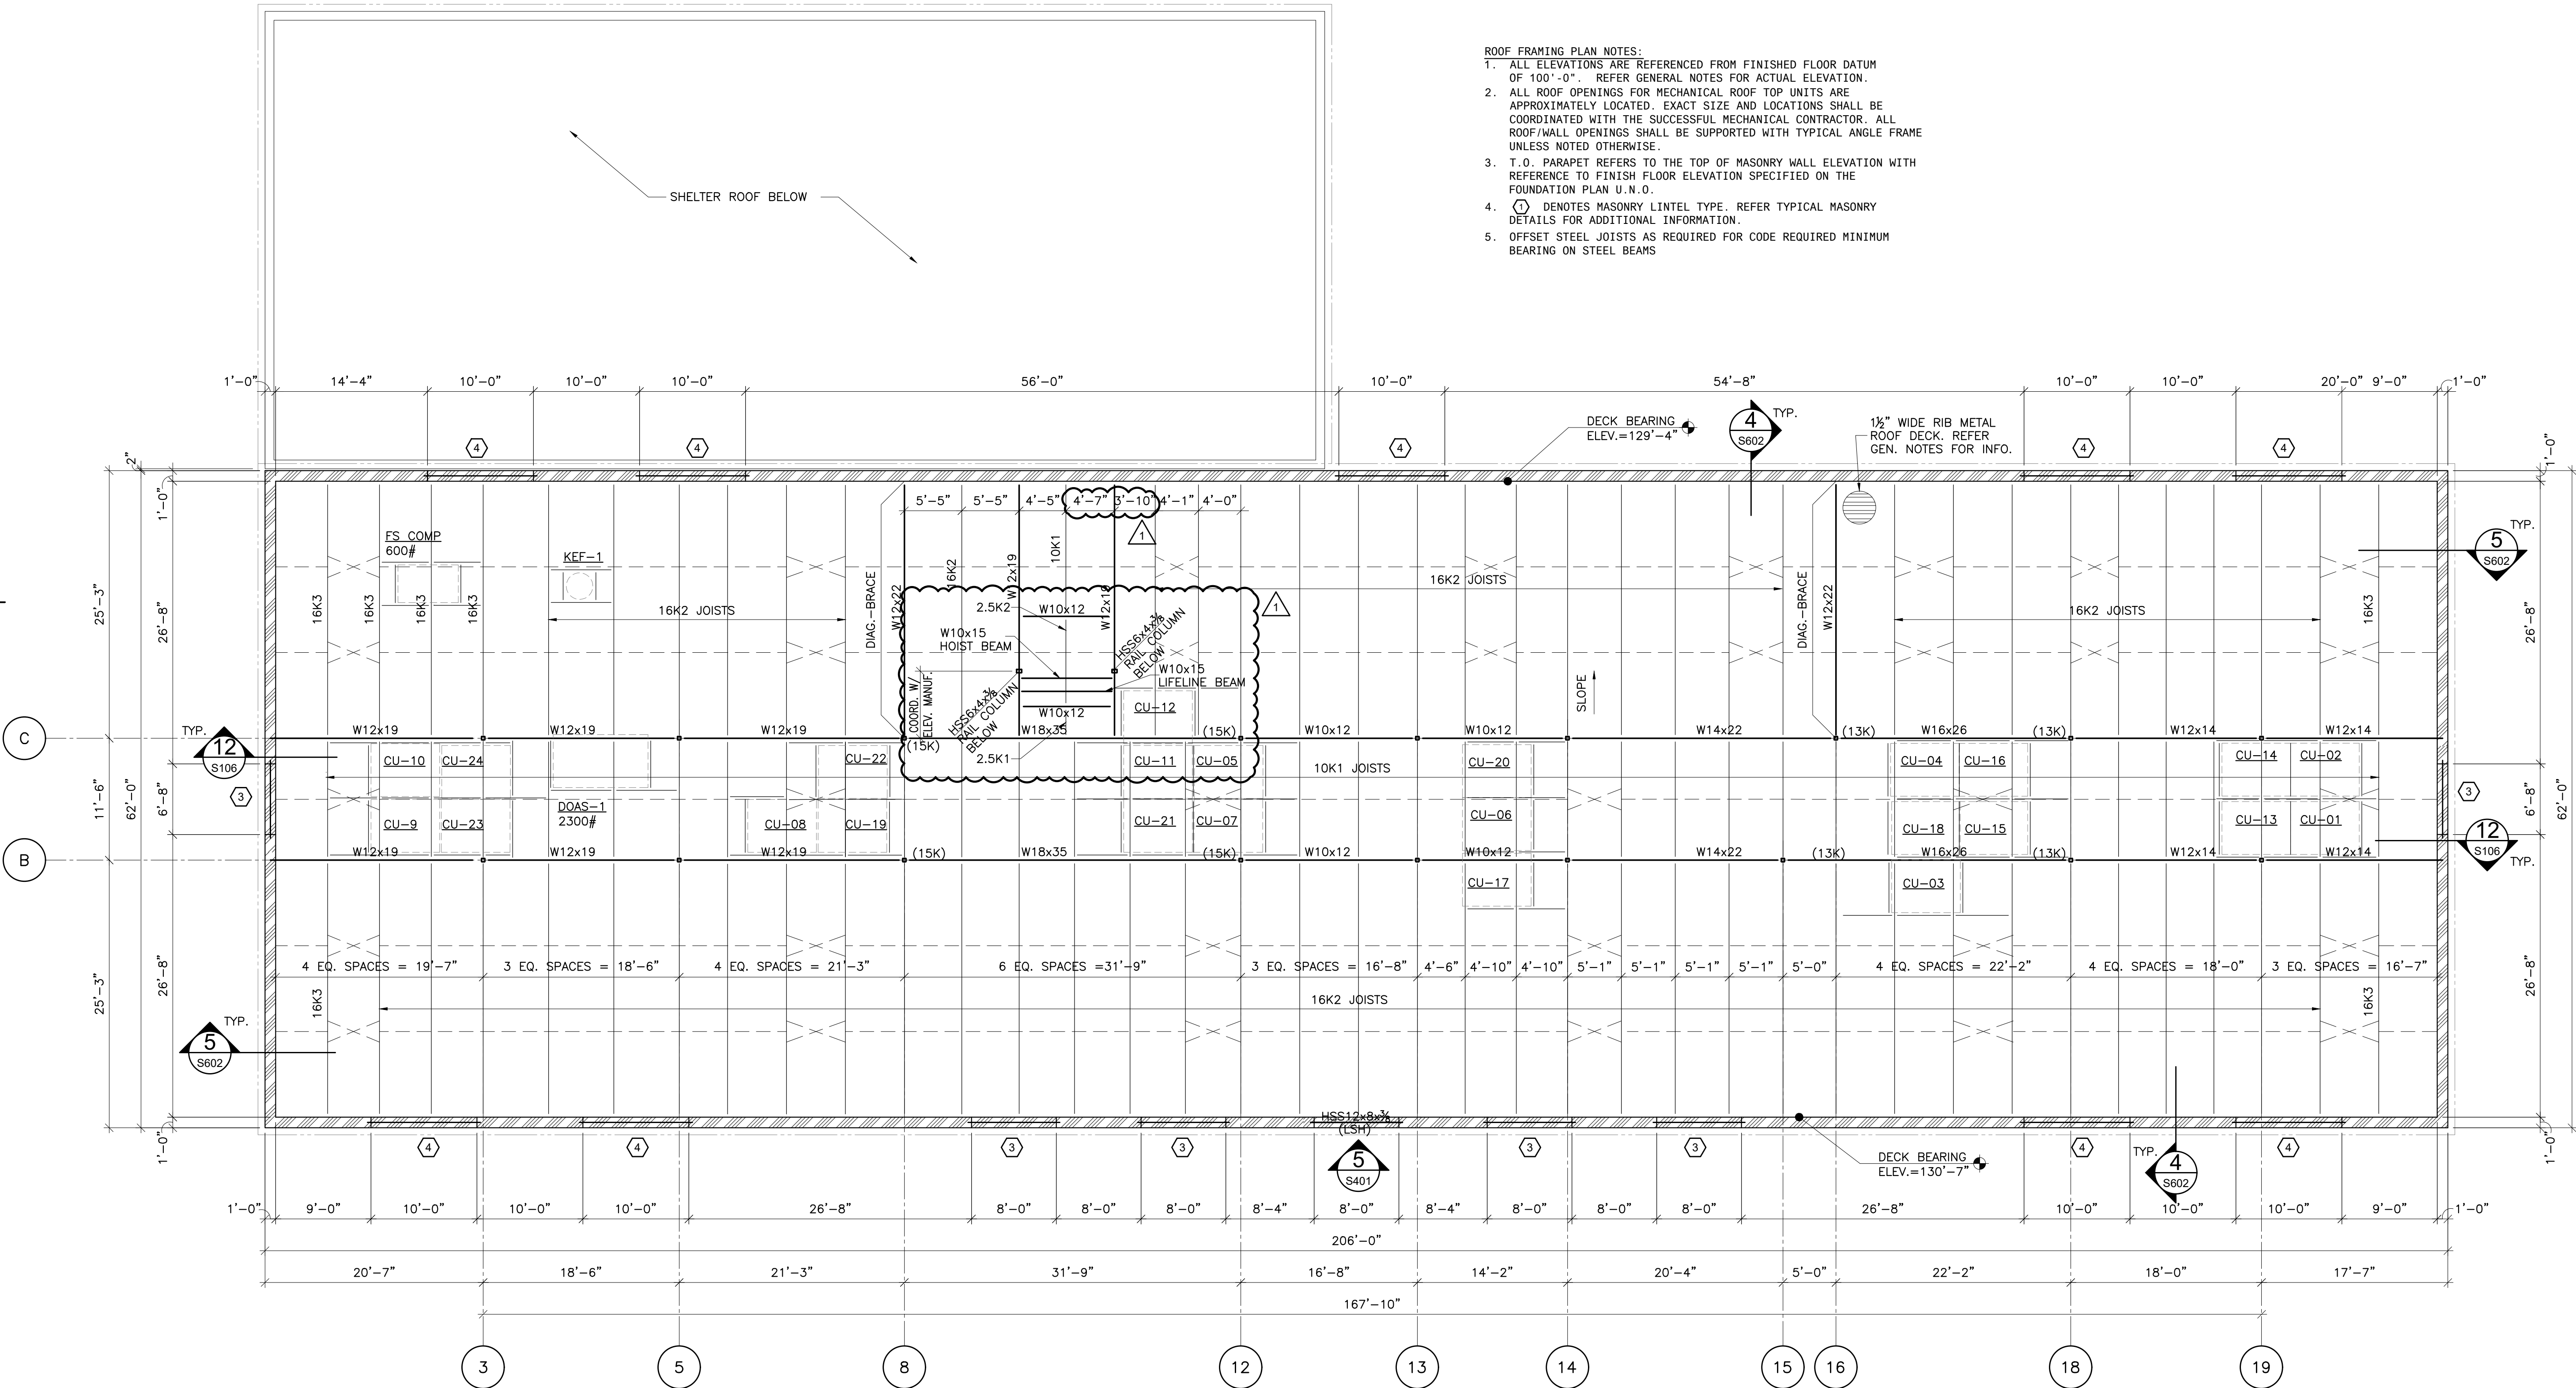

1 ROOF FRAMING PLAN
S301 SCALE: 1/8"=1'-0"



**MOORE
PUBLIC SCHOOLS**


**OLD SCHOOL
REPLACEMENT**

Sheet No.:

A102

FIRST FLOOR PLAN

OWNERSHIP USE OF DOCUMENTS:
ACP EXPRESSLY RESERVES ITS
COPYRIGHT AND OTHER PROPERTY
RIGHTS OF ALL PLANS AND DRAWINGS
DESIGNED AND/OR PRODUCED. PLANS
AND DRAWINGS ARE NOT TO BE
REPRODUCED IN ANY FORM OR MANNER
WITHOUT THE EXPRESSED WRITTEN
CONSENT OF ACP.

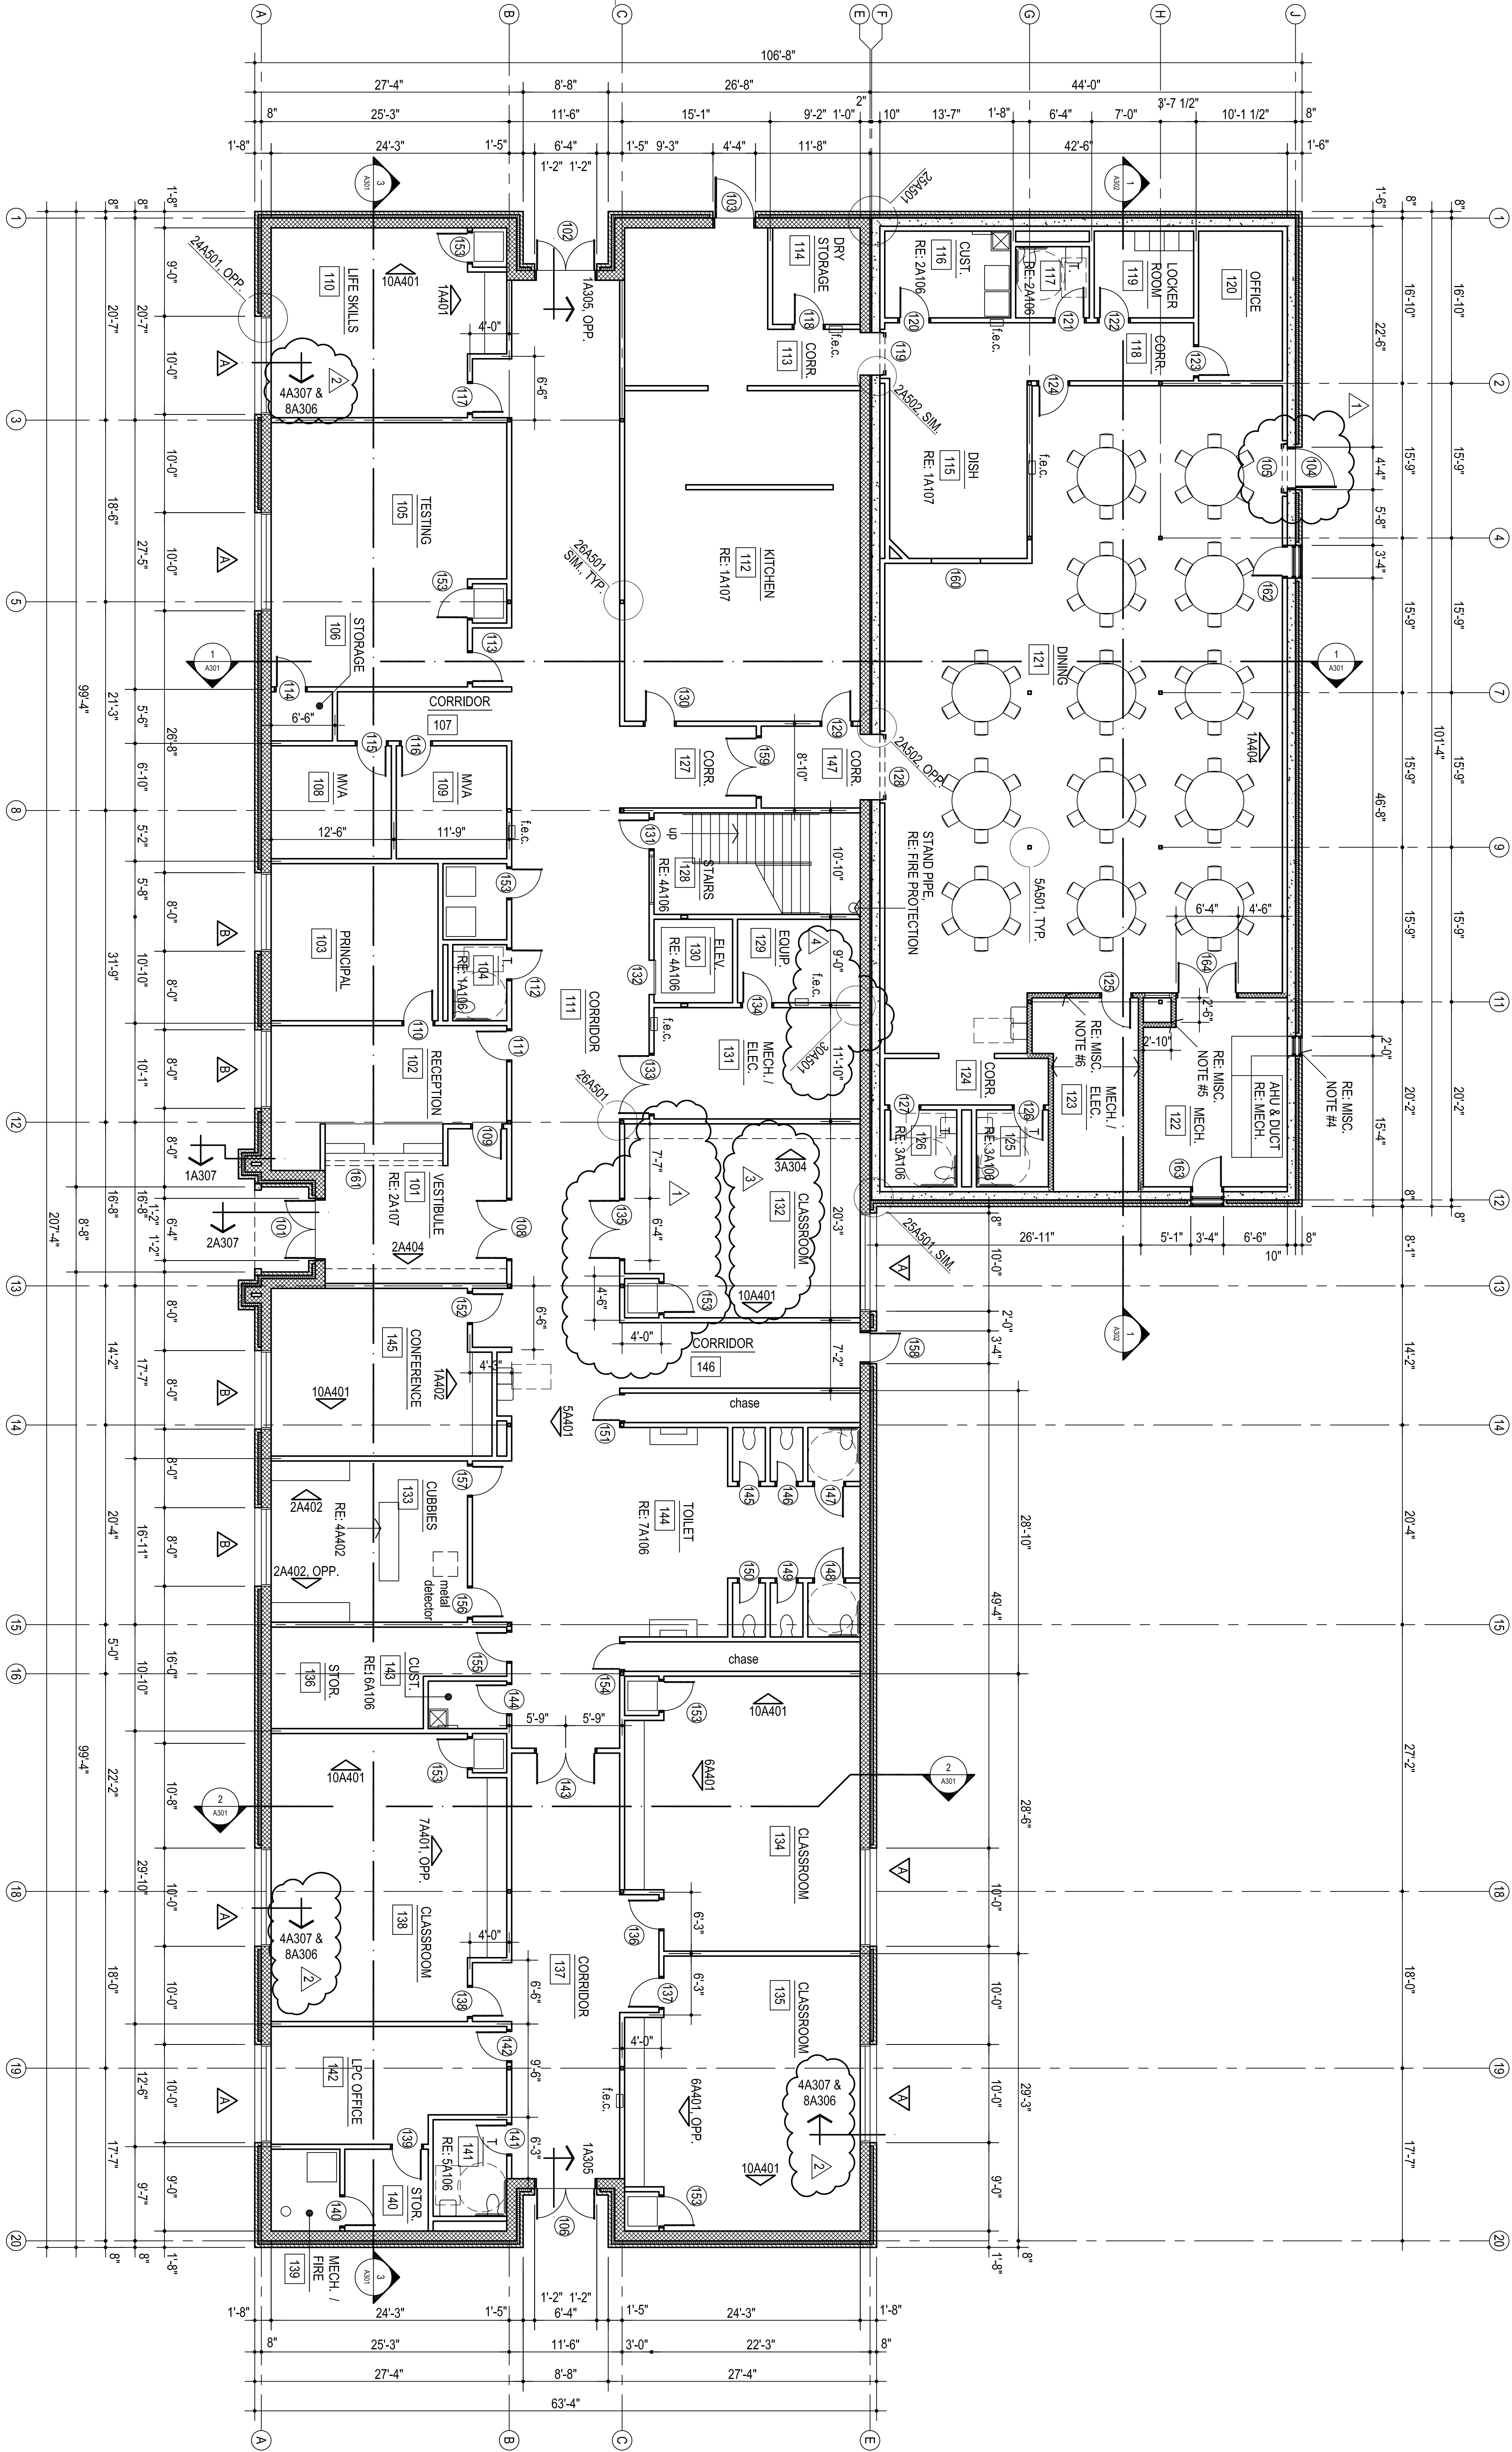




MISCELLANEOUS NOTES:

1. F.E.C. - FIRE EXTINGUISHER AND CABINET
2. DO NOT SCALE DRAWINGS TO OBTAIN MATERIAL QUANTITIES.
USE DRAWINGS WHICH ARE DIMENSIONED OR COORDINATE W/
EXISTING CONDITIONS &OR ARCHITECT & ENGINEERS.
3. INTERIOR PARTITIONS ARE DIMENSIONED TO
CENTER LINE
4. COORDINATE LOUVER LOCATION WITH MECHANICAL
EQUIPMENT LAYOUT. PRIOR TO CONSTRUCTION.
5. VERTICAL CHASE WALL TO BE 6" MTL. STUDS
W/ 6" BATT INSUL. 5/8" GYP. BD. EACH SIDE -
WRAP TOP TRACK WITH 5/8" GYP. BD. -
TOP OF WALL TO BE 8'-0" ABOVE FIN. FLR.
6. WALLS AT ROOM 122 & 123 TO RECEIVE 6" BATT
INSULATION TO DECK ABOVE.

FIRST FLOOR PLAN

1/8" = 1'-0"

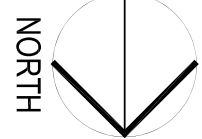

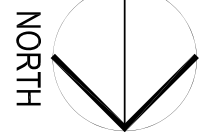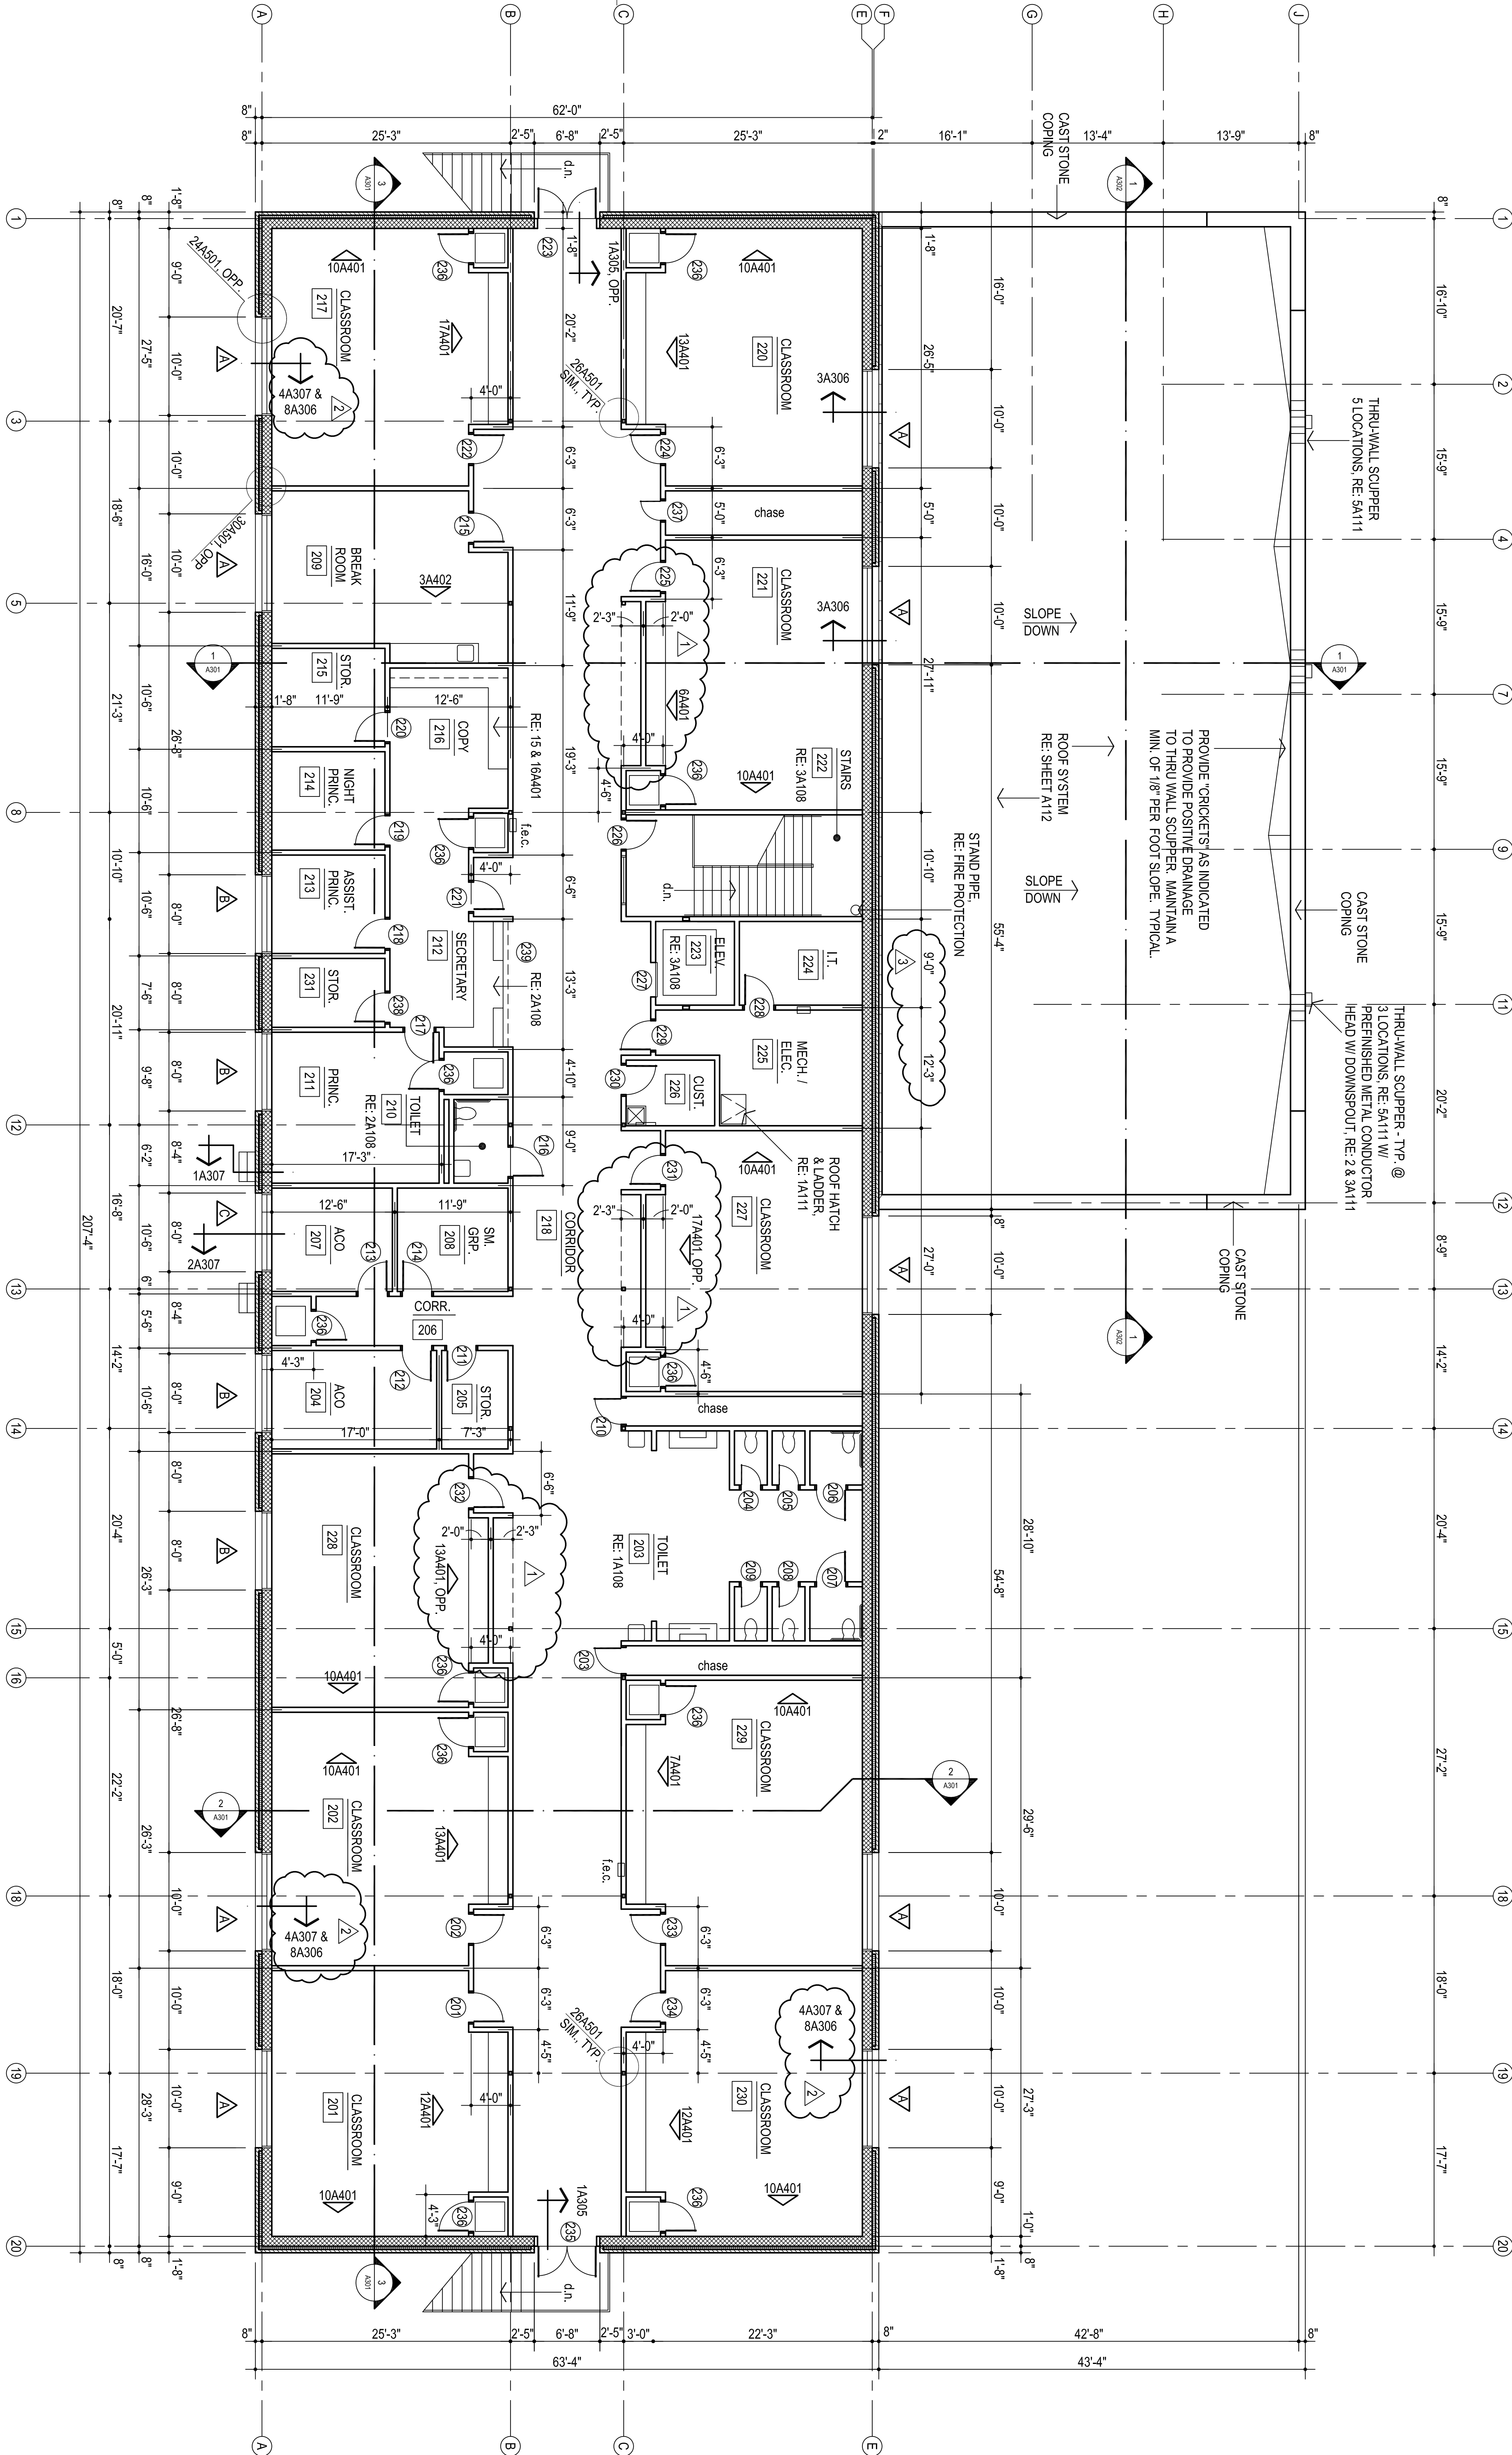

SECOND FLOOR PLAN


1/8" = 1'-0"

- MISCELLANEOUS NOTES:
1. F.E.C. - FIRE EXTINGUISHER AND CABINET
 2. DO NOT SCALE DRAWINGS TO OBTAIN MATERIAL QUANTITIES.
USE DRAWINGS WHICH ARE DIMENSIONED OR COORDINATE W/
EXISTING CONDITIONS &/OR ARCHITECT & ENGINEERS.
 3. INTERIOR PARTITIONS ARE DIMENSIONED TO
CENTER LINE


102 CLASSROOM

102 CLASSROOM


102 CLASSROOM

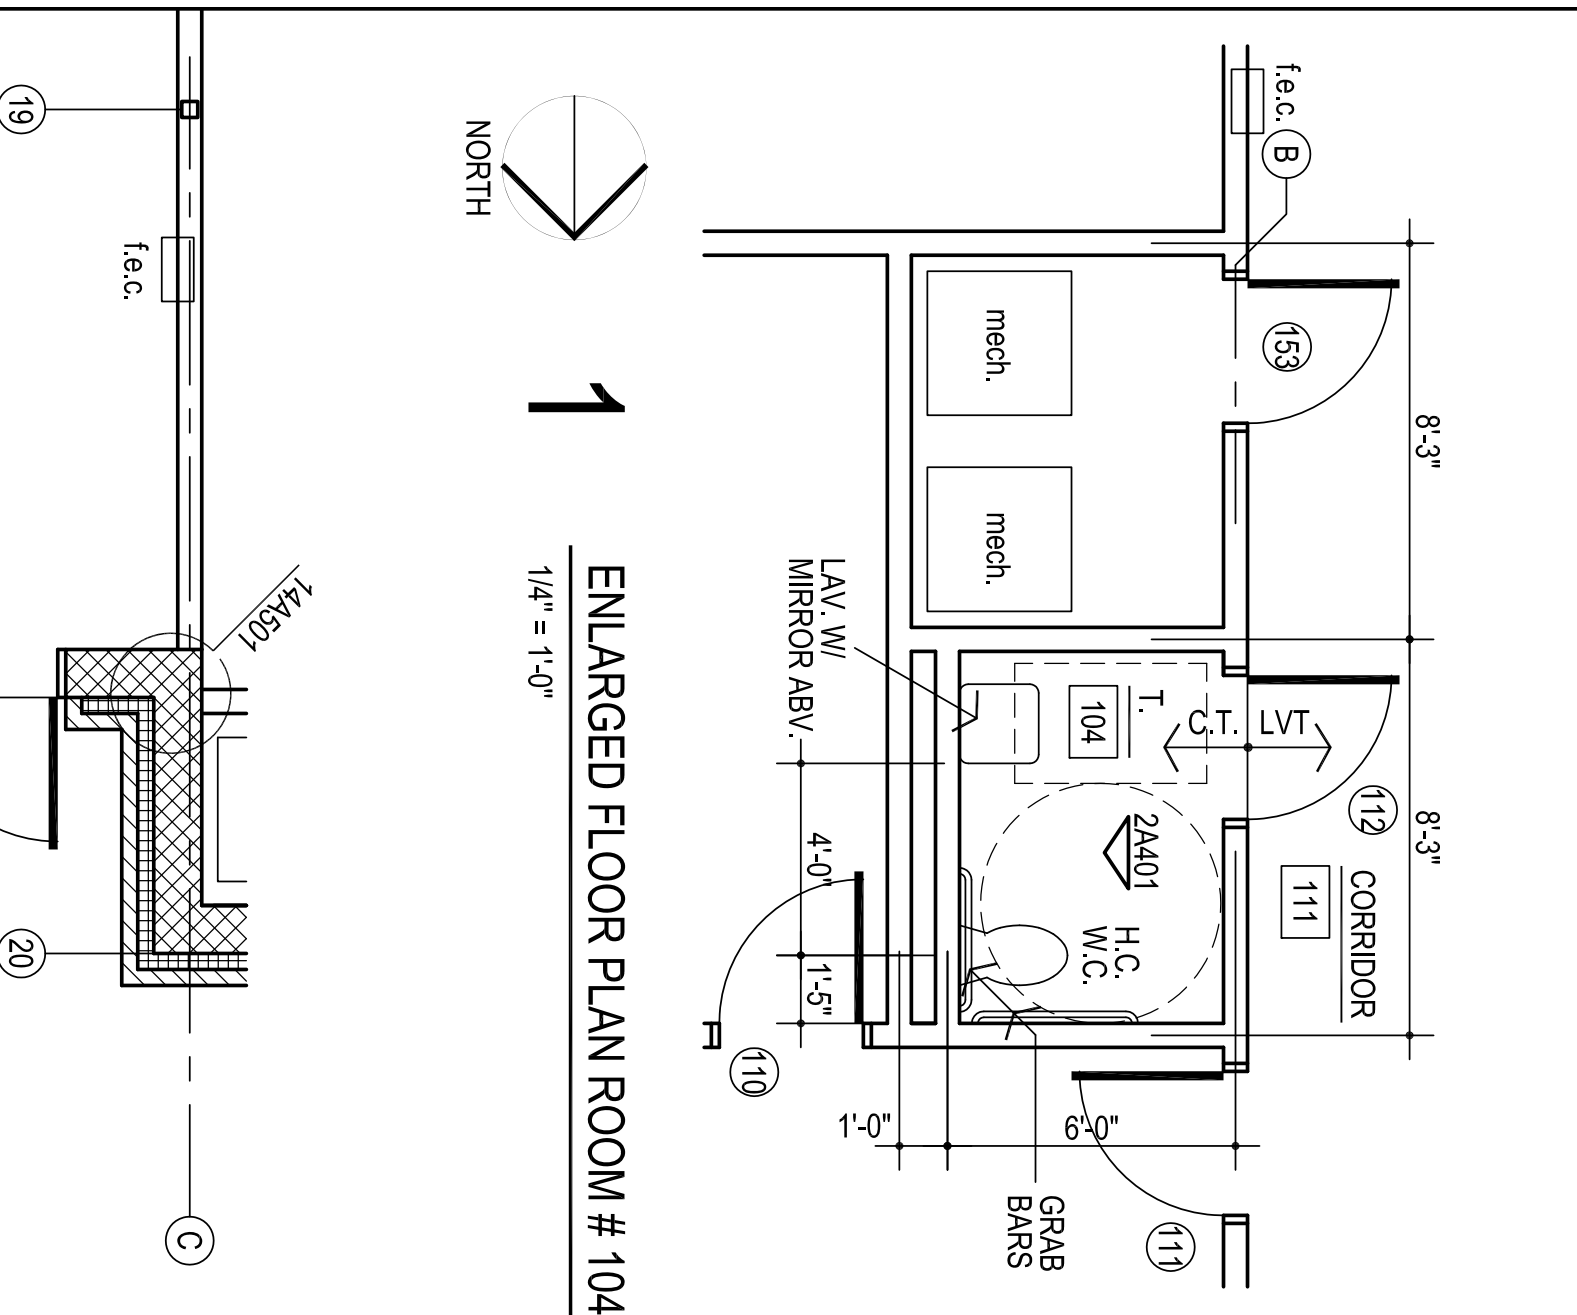


1
ENLARGED FLOOR PLAN ROOM # 104
1/4" = 1'-0"

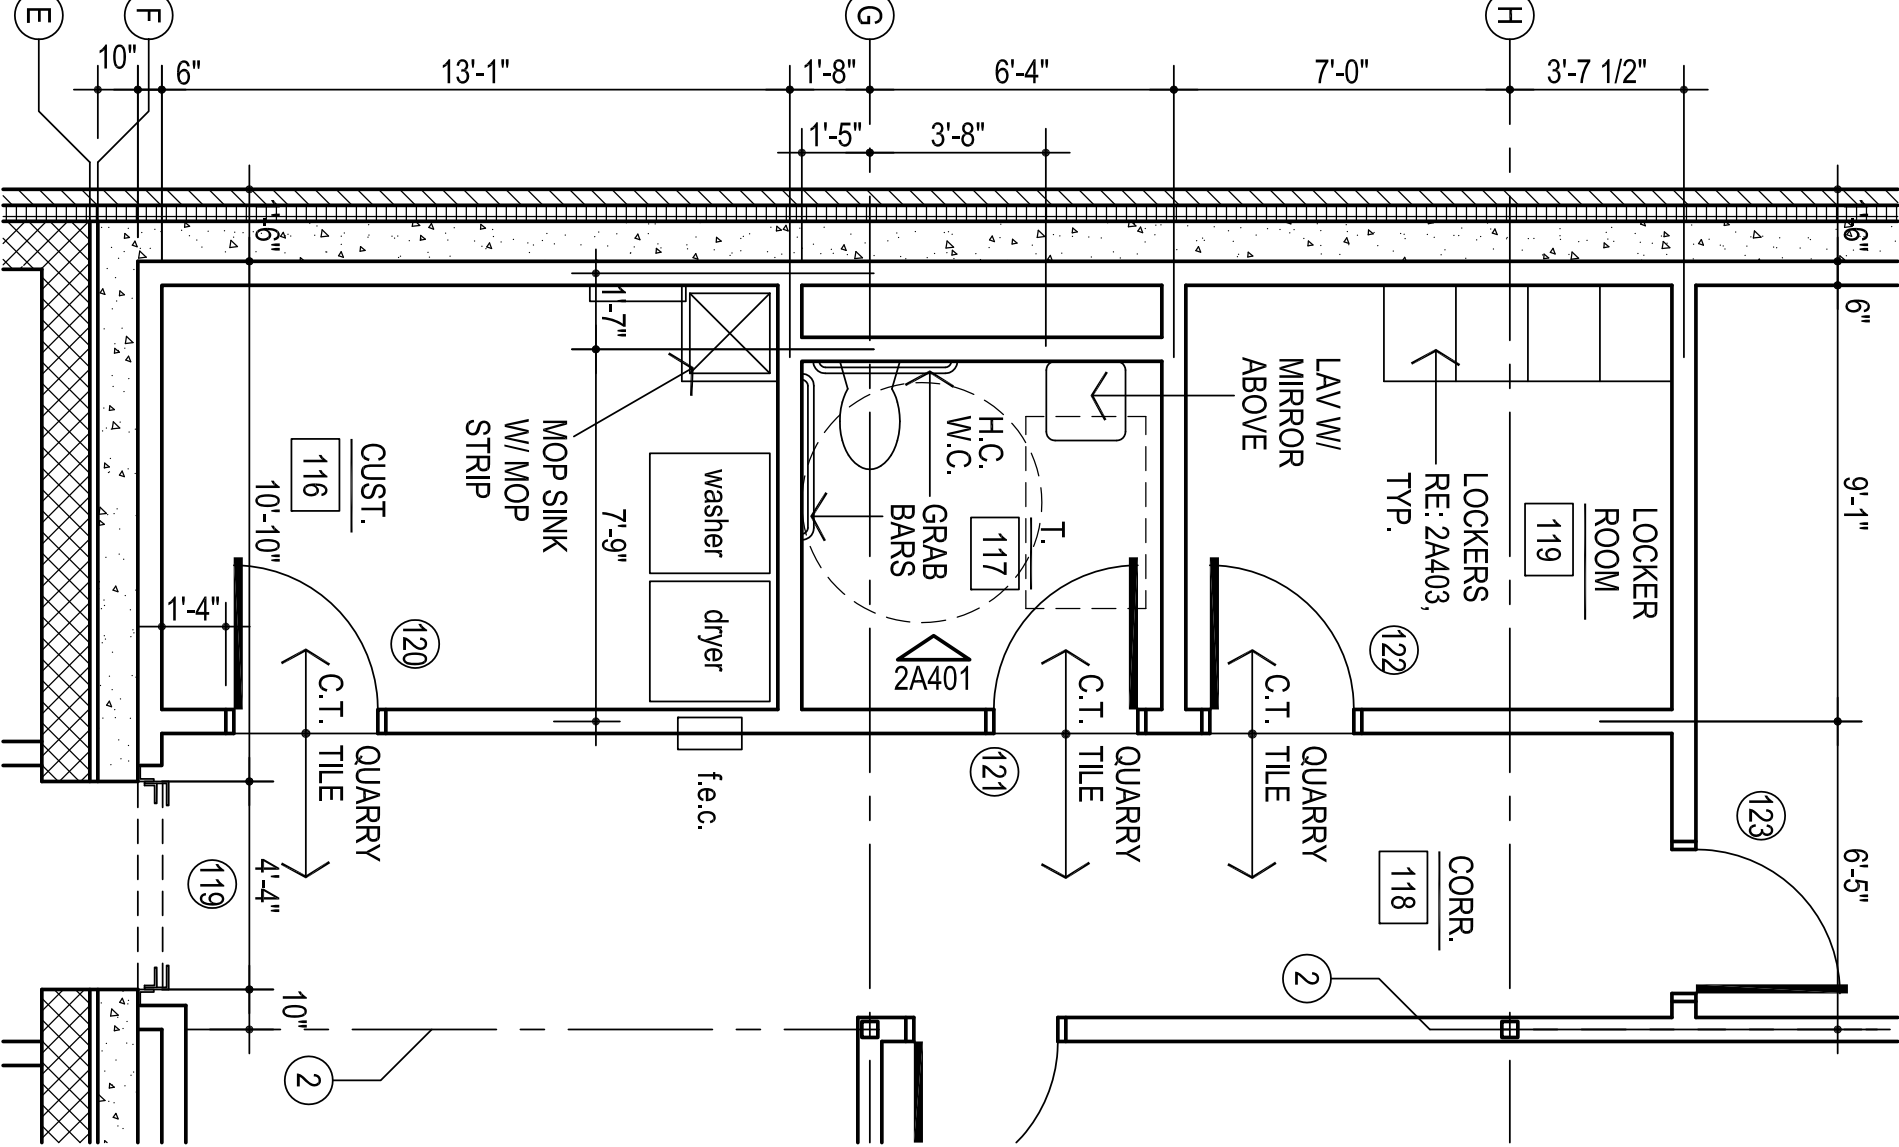


2
ENLARGED FLOOR PLAN ROOM # 116, 117, 118 & 119
1/4" = 1'-0"

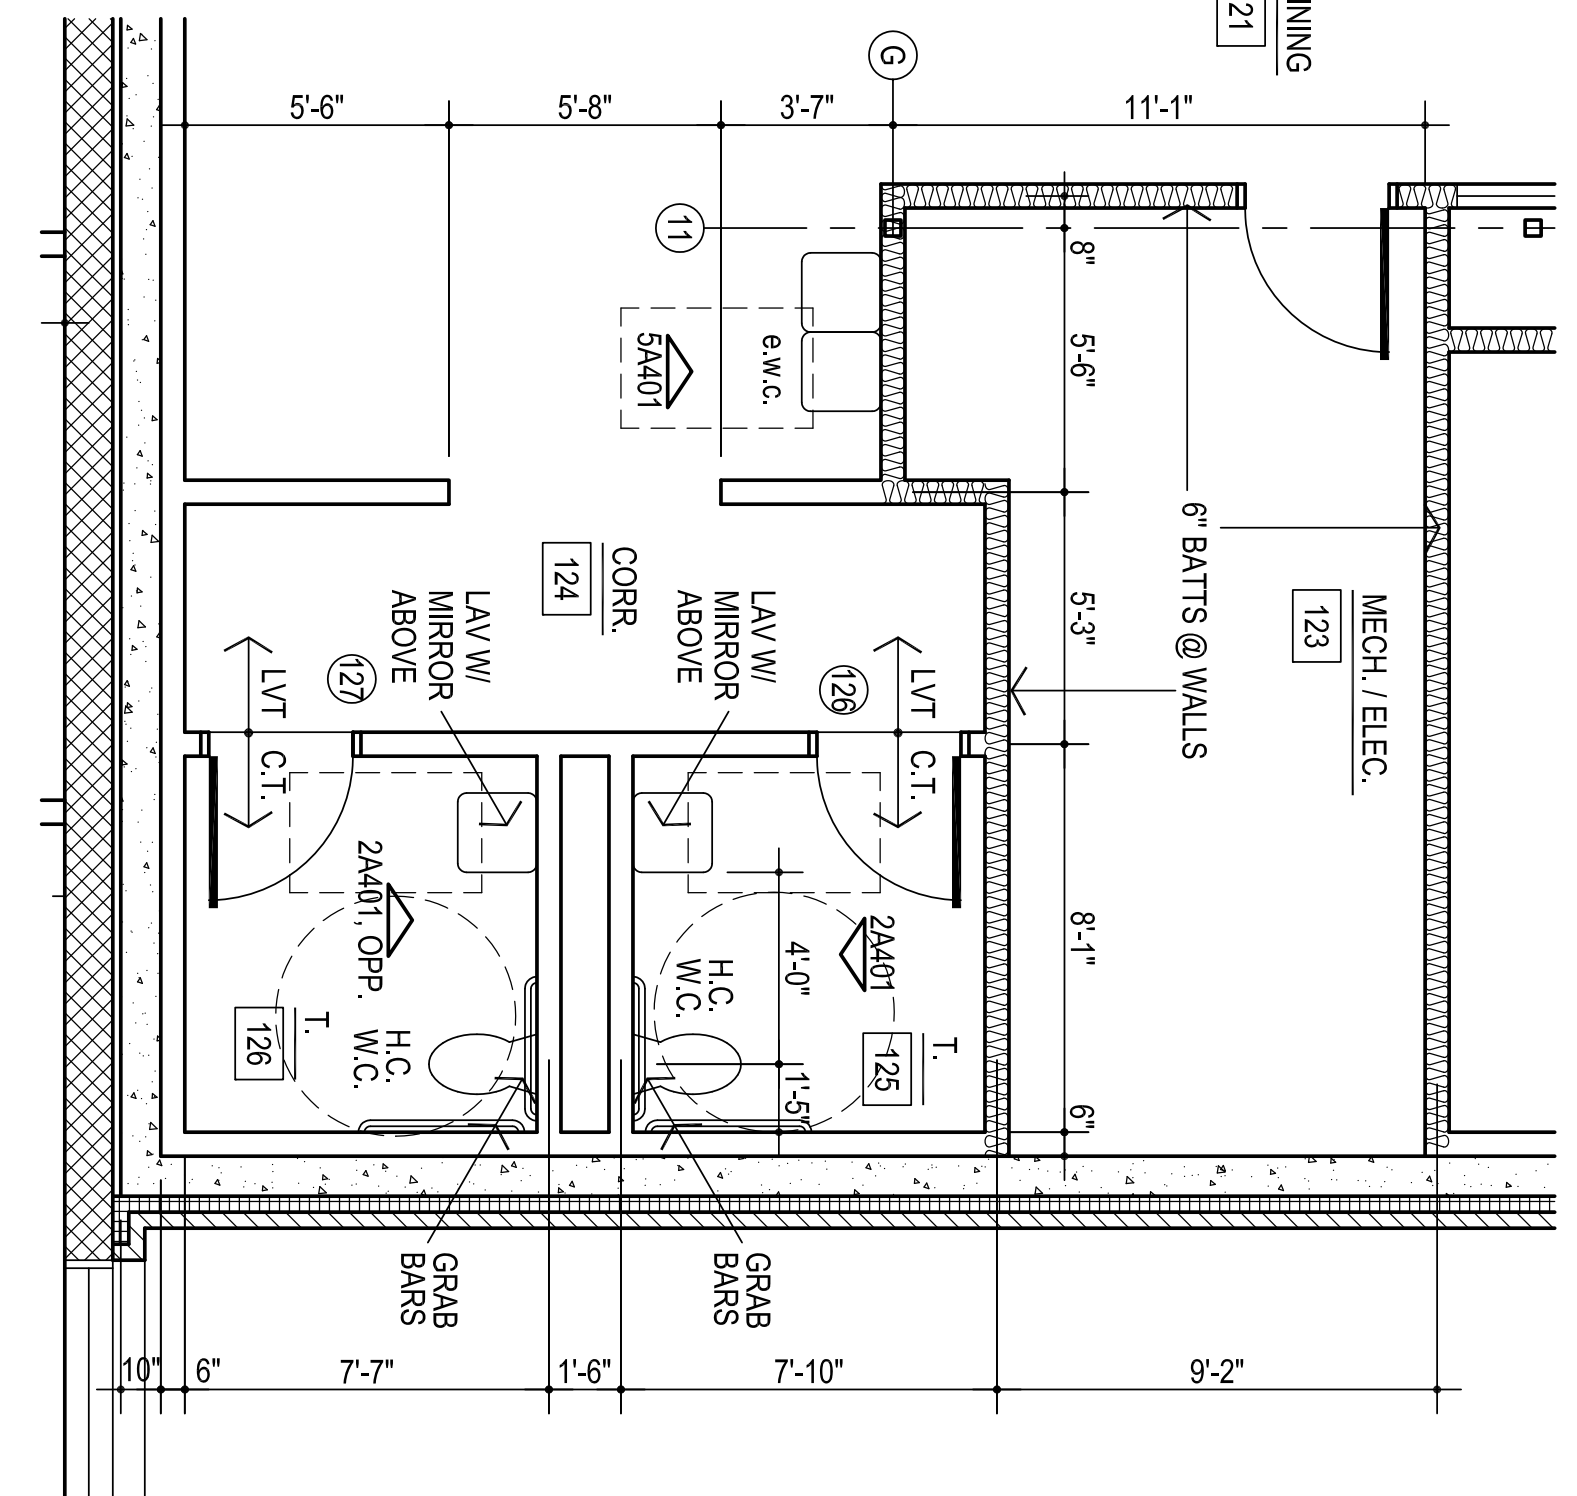


3
ENLARGED FLOOR PLAN
ROOM # 124, 125 & 126
1/4" = 1'-0"

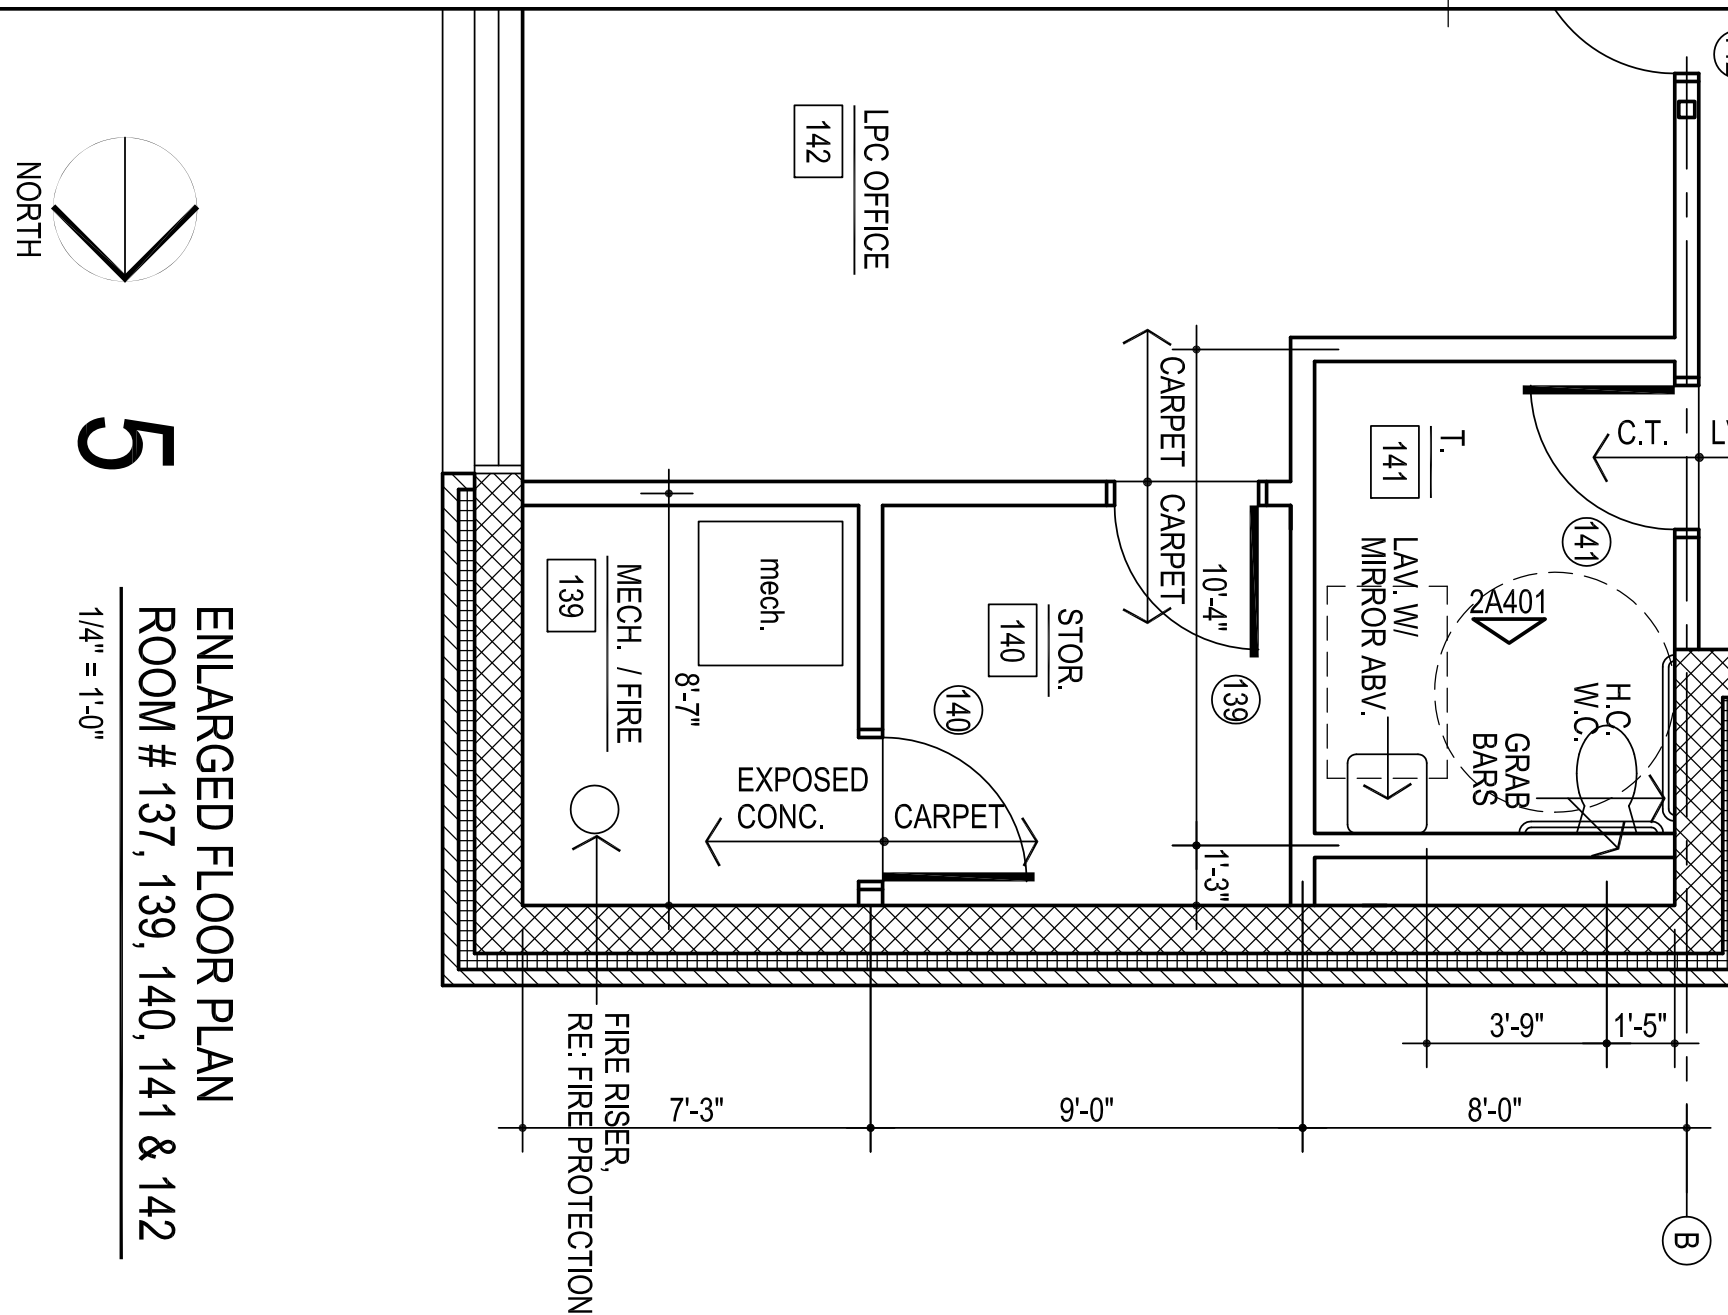


5
ENLARGED FLOOR PLAN
ROOM # 137, 139, 140, 141 & 142
1/4" = 1'-0"

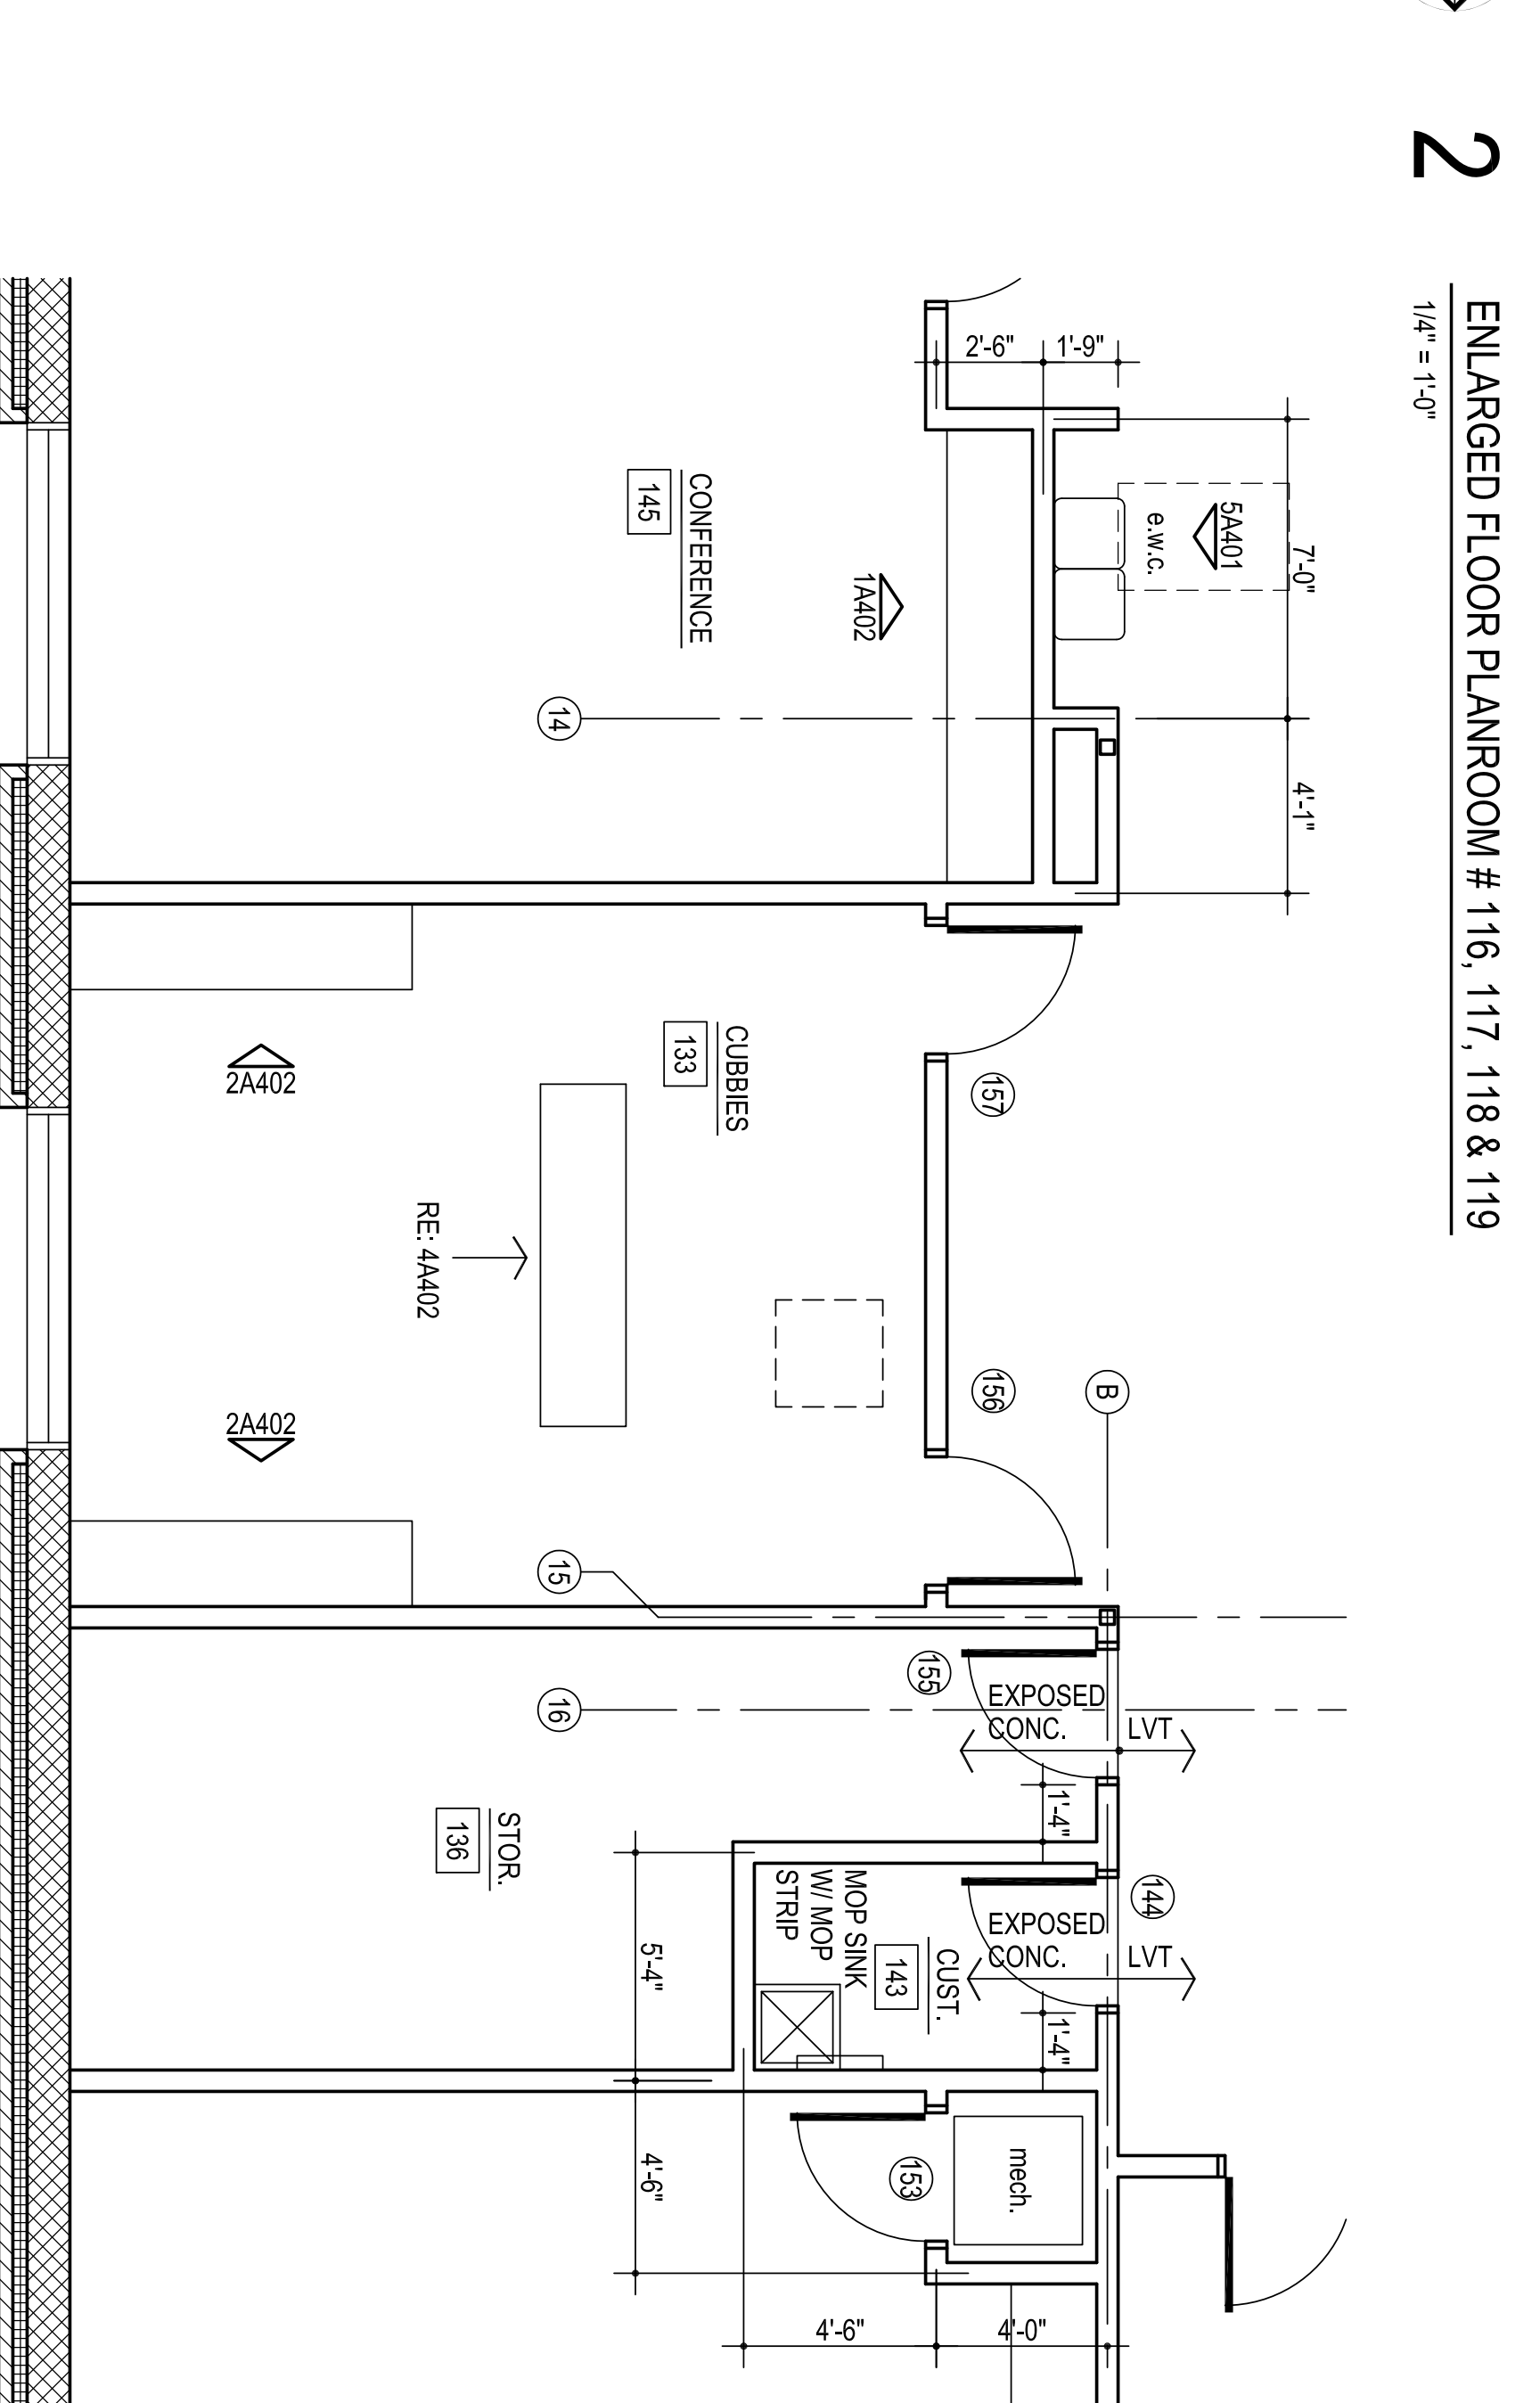

6
ENLARGED FLOOR PLAN ROOM # 133, 136, 143 & 145
1/4" = 1'-0"

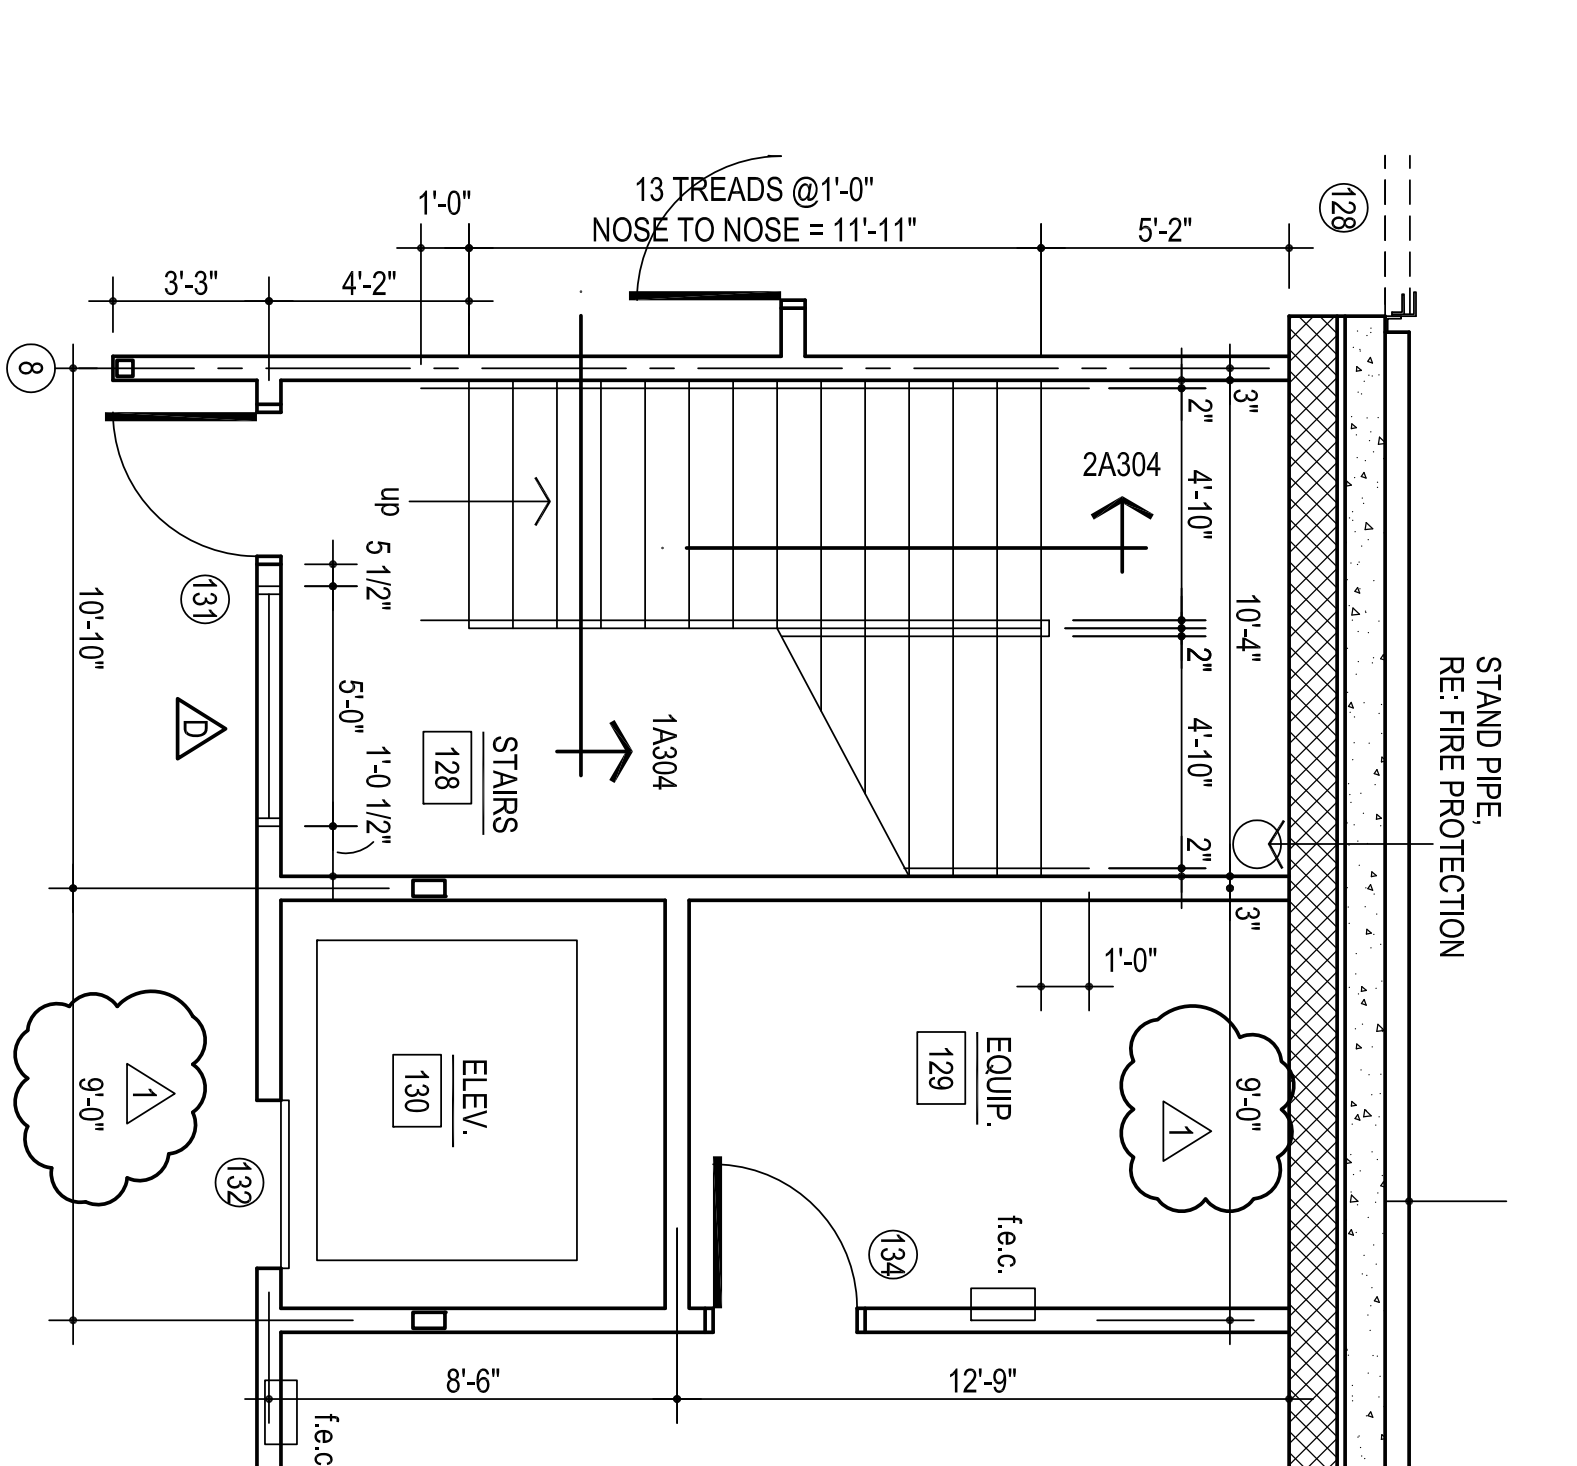

4
ENLARGED FLOOR PLAN
ROOM # 128, 129 & 130
1/4" = 1'-0"

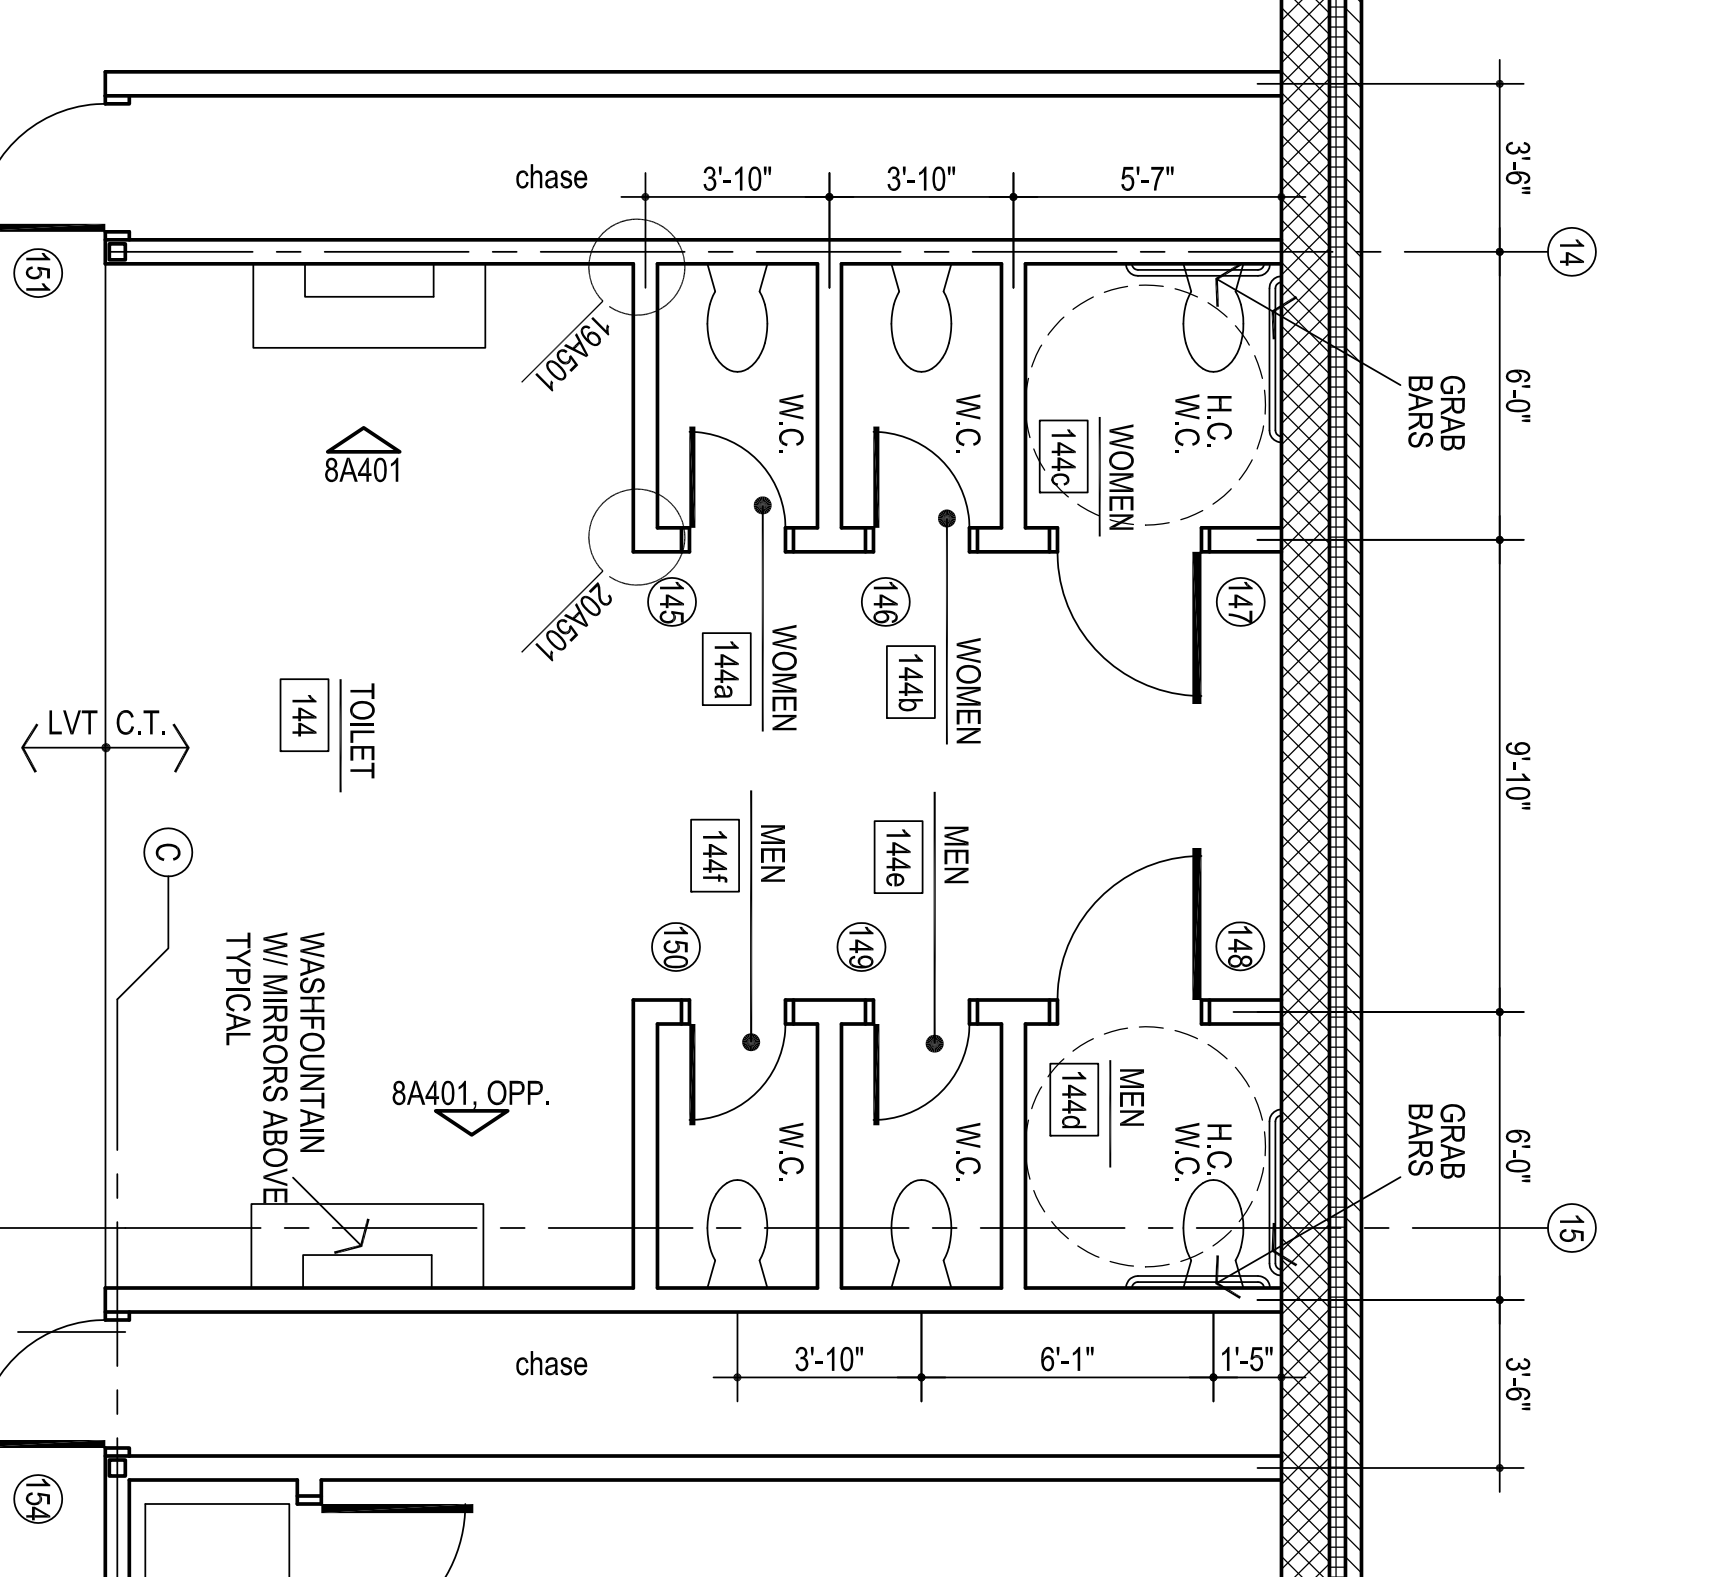

7
ENLARGED FLOOR PLAN ROOM # 144, 144a,
144b, 144c, 144d, 144e & 144f
1/4" = 1'-0"

MISCELLANEOUS NOTES:

1. F.E.C. - FIRE EXTINGUISHER AND CABINET
2. DO NOT SCALE DRAWINGS TO OBTAIN MATERIAL QUANTITIES. USE DRAWINGS WHICH ARE DIMENSIONED OR COORDINATE WITH EXISTING CONDITIONS &/OR ARCHITECT & ENGINEERS.
3. INTERIOR PARTITIONS ARE DIMENSIONED TO CENTER LINE

DEVOTES ROOM NAME

CLASSROOM

DEVOTES ROOM NUMBER

NORTH

6

1/4" = 1'-0"

NOTE: CONTRACTOR TO VERIFY THAT THE MOUNTING HEIGHTS OF ALL WALL MOUNTED FIXTURES (I.E. PLUMBING FIXTURES, GRAB BARS, MIRRORS, ETC.) MEET ALL APPLICABLE CODES & STANDARDS PRIOR TO INSTALLATION.

NORTH

7

1/4" = 1'-0"

313 S. E. 5th Street
MOORE, OK. 73160
405.735.3477
ACGP@theACGP.net
www.theACGP.net

CEDAR CREEK
CIVIL
KFC ENGINEERING
STRUCTURAL
SALAS O'BRIEN
MECHANICAL/ELECTRICAL

12/1/125

C6

dram by

MA

checked by

NOVEMBER 2025

date

revisions

<u>ADDENDUM #2</u>
<u>CB-4</u>

OLD SCHOOL REPLACEMENT


sheet no:

A108






SECOND FLOOR ENLARGED PLAN

OWNERSHIP USE OF DOCUMENTS:


AGP EXPRESSLY RESERVES ITS COPYRIGHT AND OTHER PROPERTY RIGHTS OF ALL PLANS AND DRAWINGS DESIGNED AND/OR PRODUCED. PLANS AND DRAWINGS ARE NOT TO BE REPRODUCED IN ANY FORM OR MANNER WITHOUT THE EXPRESSED WRITTEN CONSENT OF AGP.

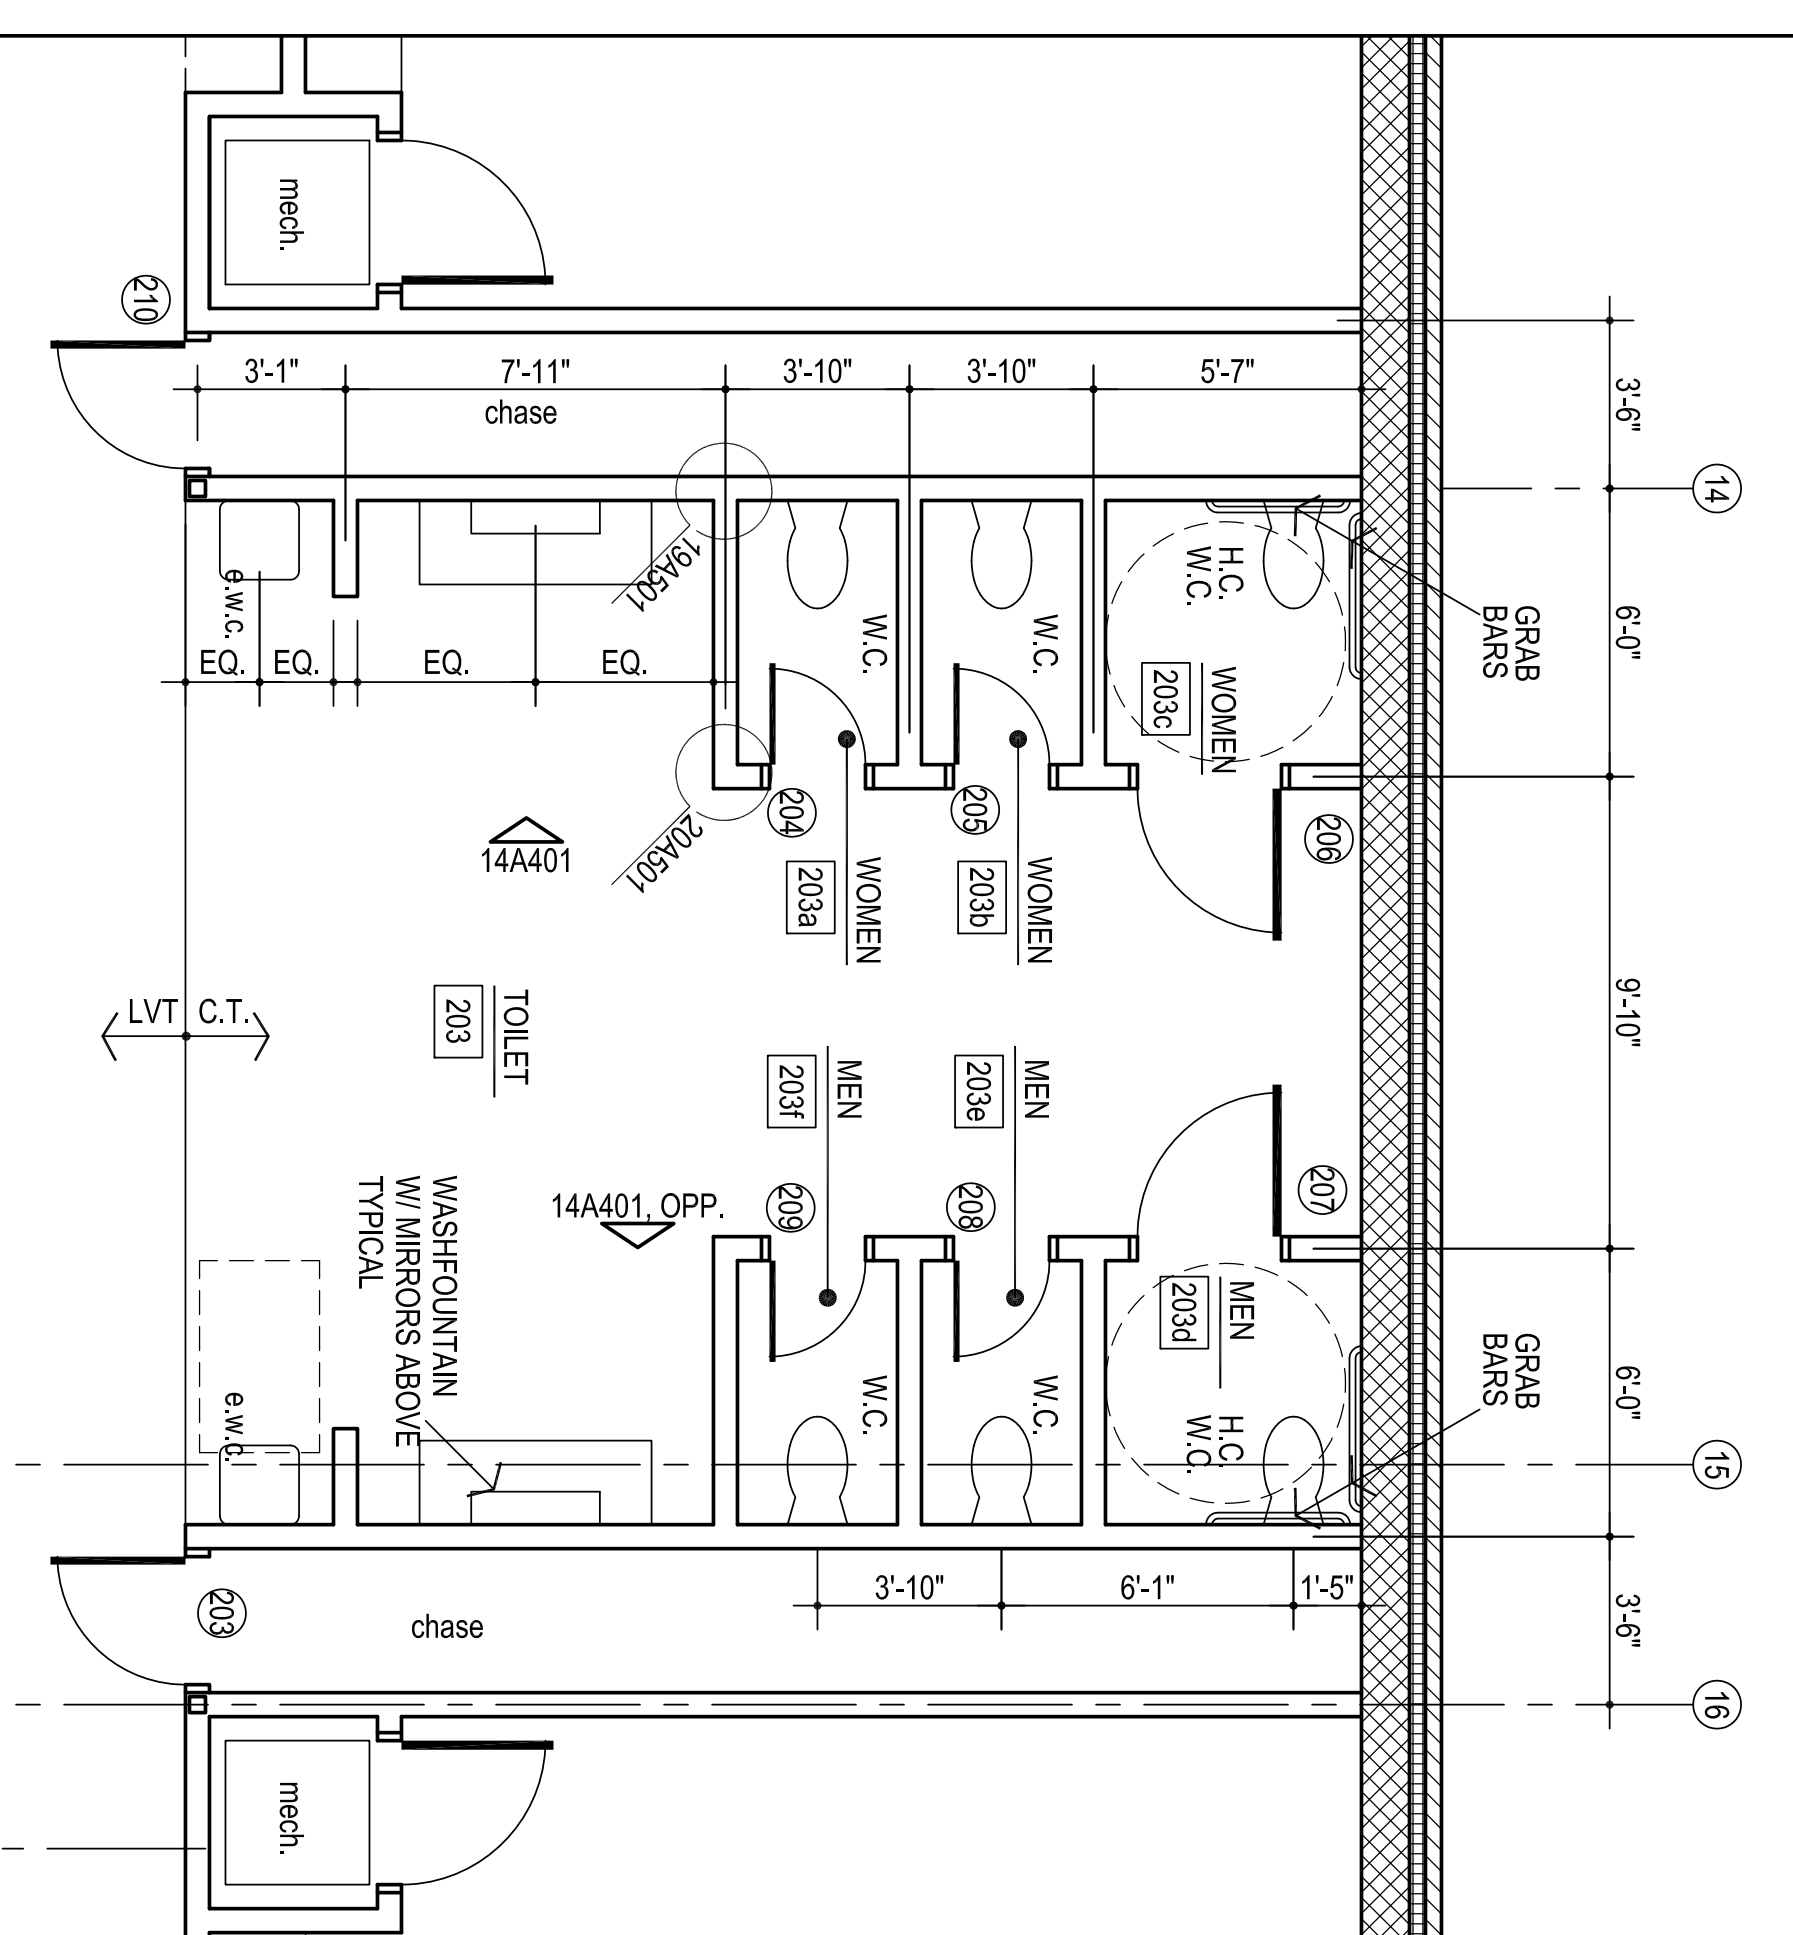


ENLARGED FLOOR PLAN
ROOM # 203, 203a, 203b, 204c, 204d, 204e & 204f

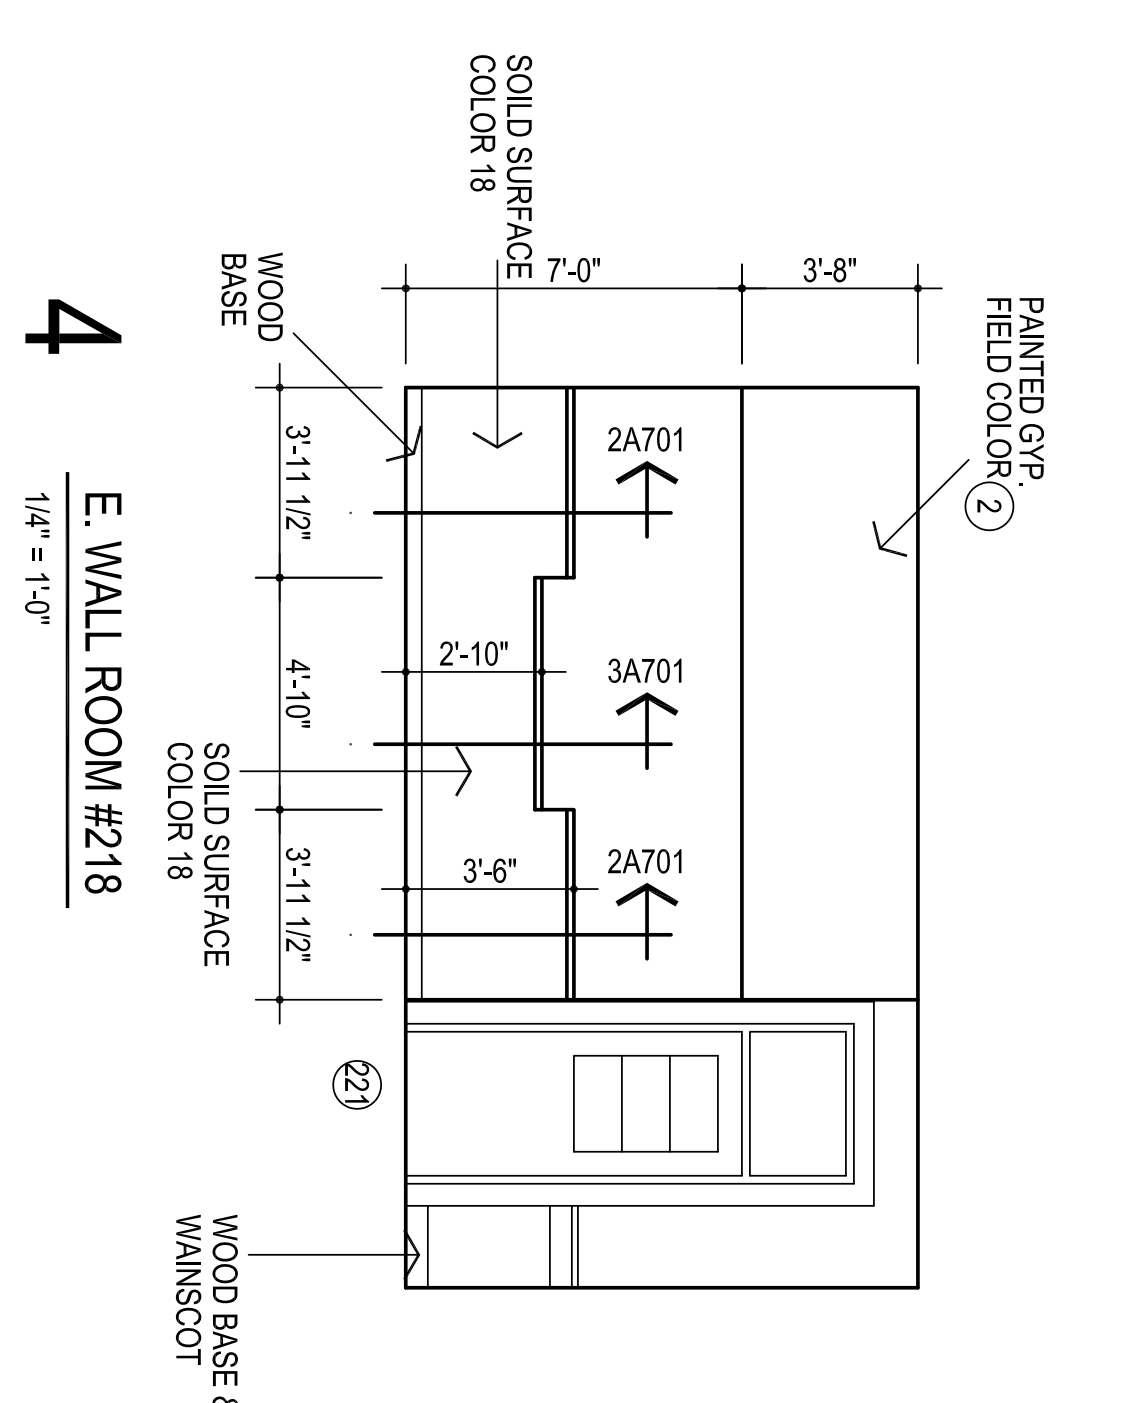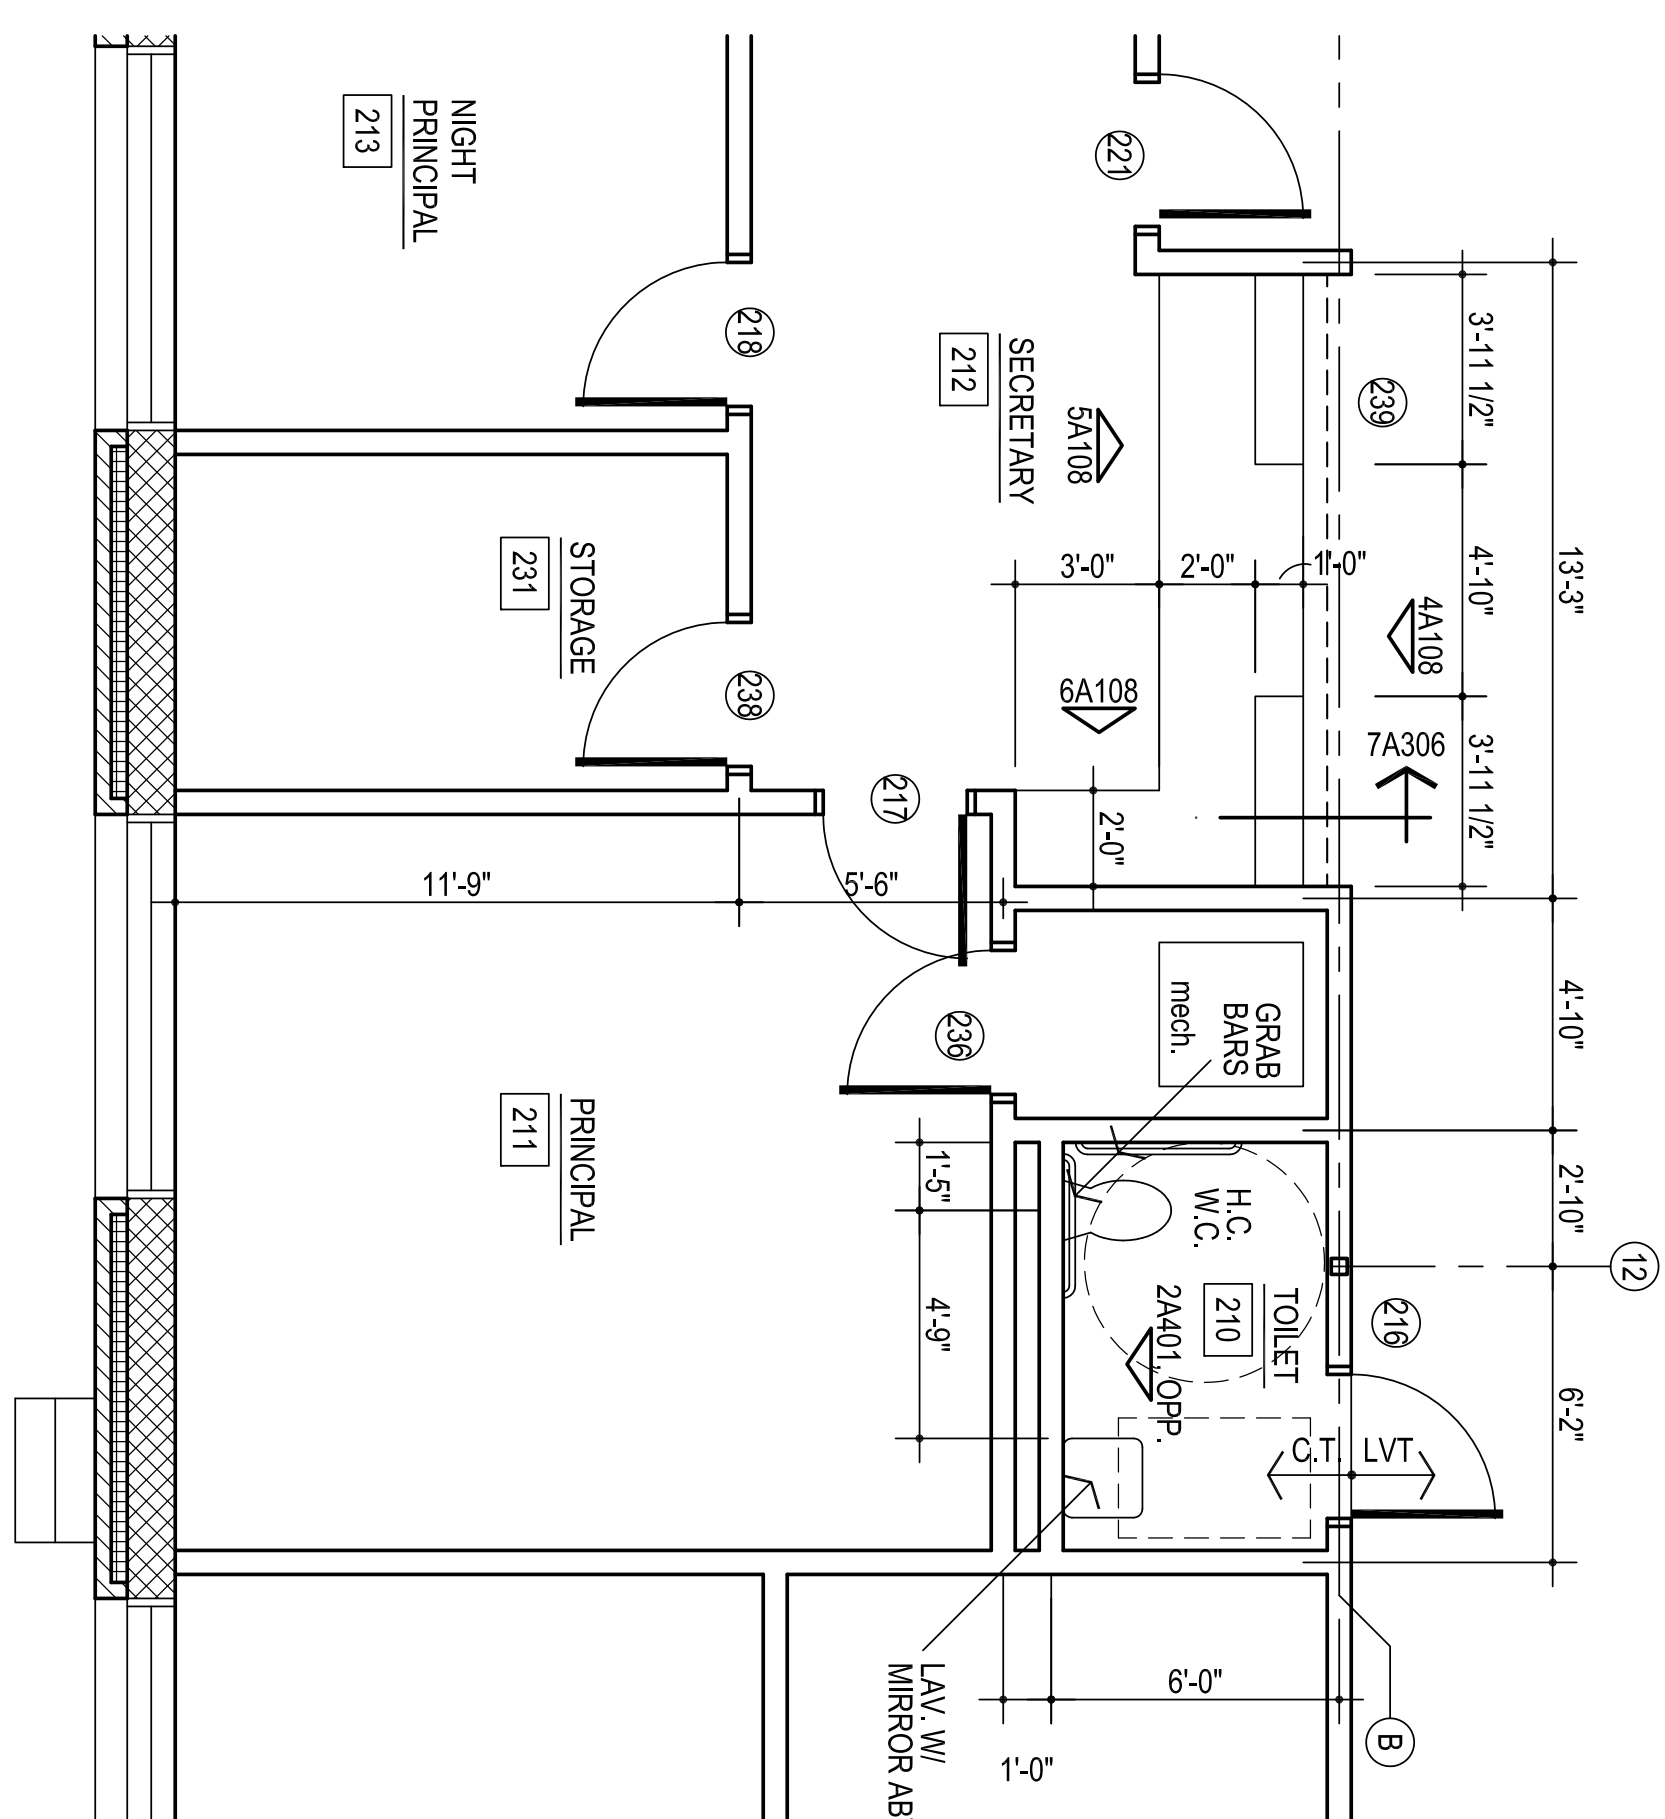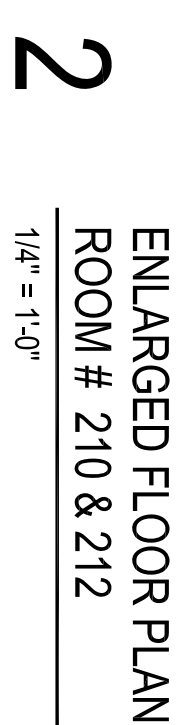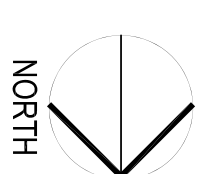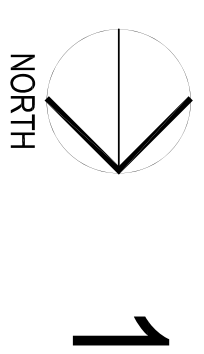

4
E. WALL ROOM #218
1/4" = 1'-0"

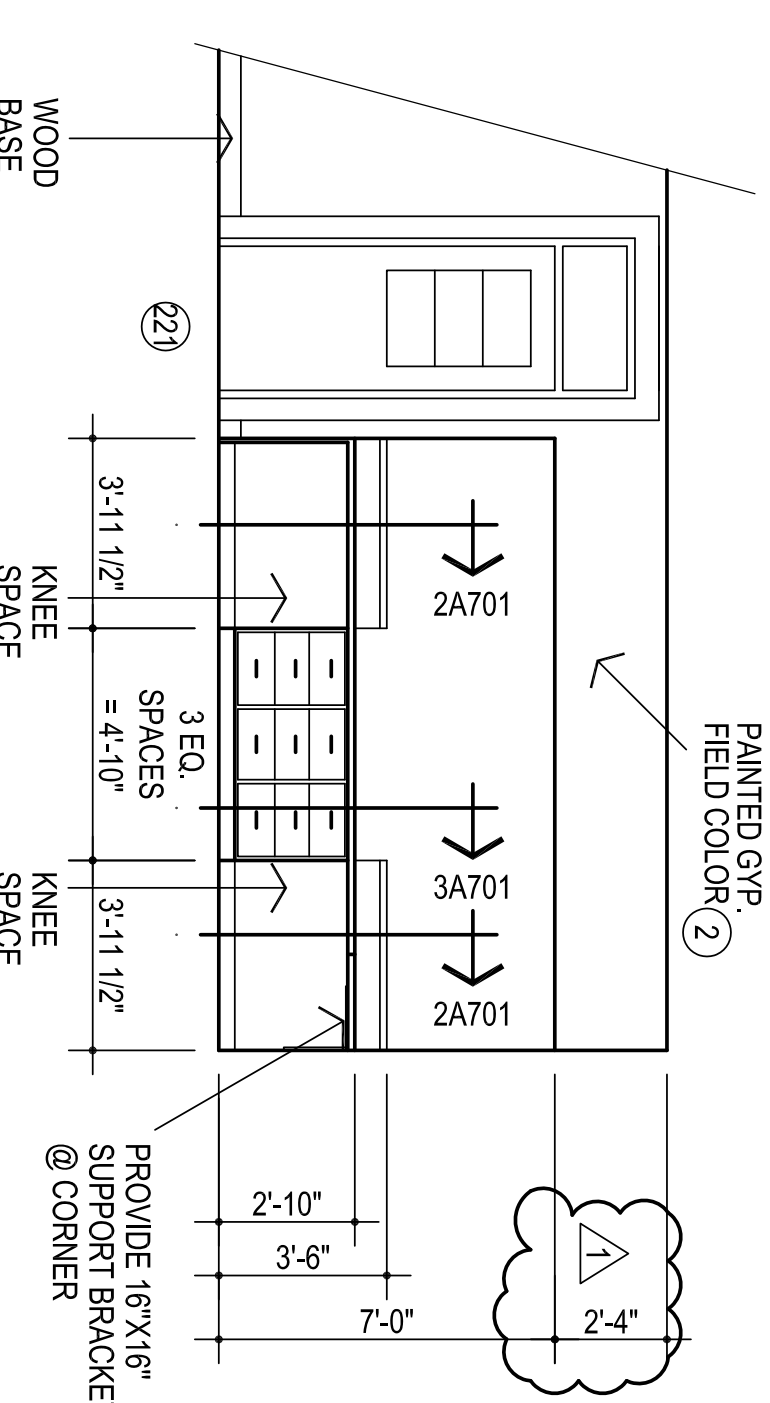

5
W. WALL ROOM #212
1/4" = 1'-0"

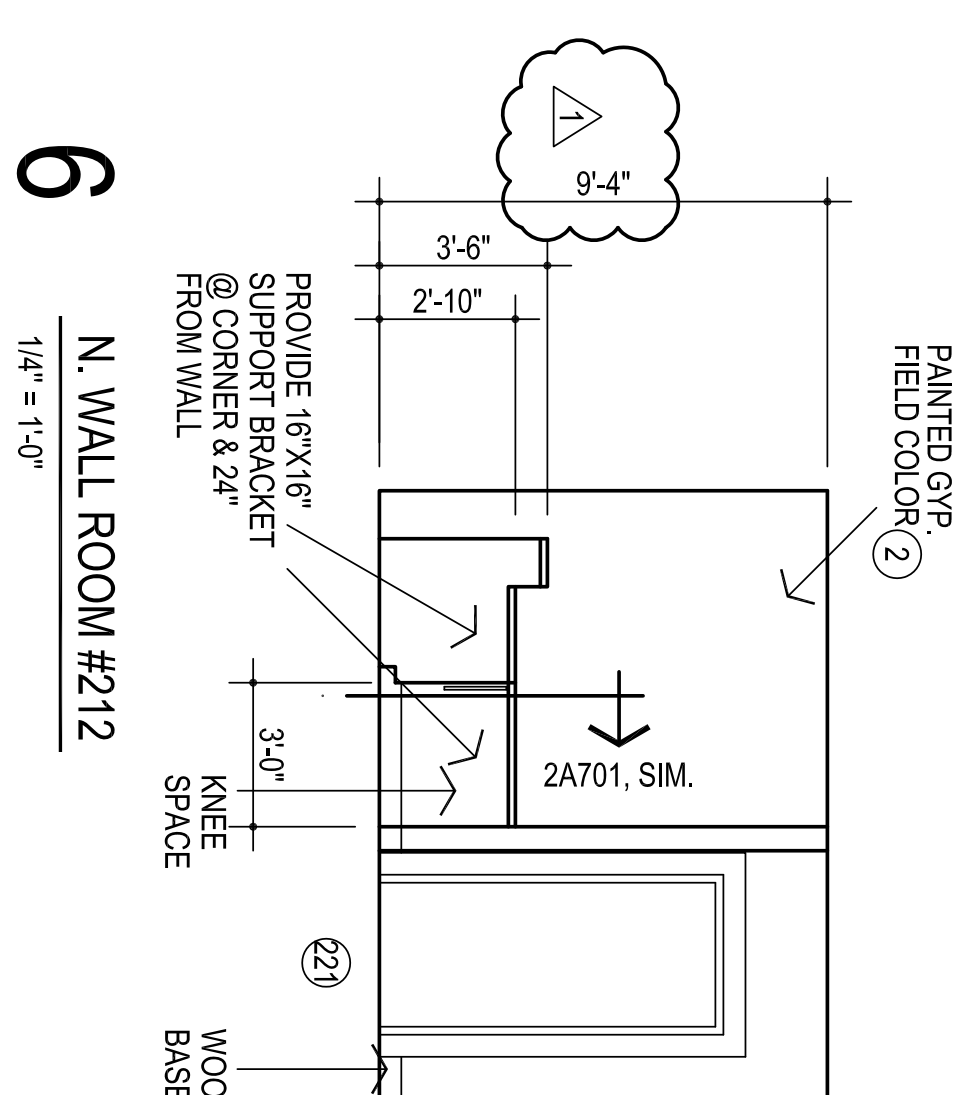


6
N. WALL ROOM #212
1/4" = 1'-0"

1. F.E.C. - FIRE EXTINGUISHER AND CABINET
2. DO NOT SCALE DRAWINGS TO OBTAIN MATERIAL QUANTITIES. USE DRAWINGS WHICH ARE DIMENSIONED OR COORDINATE W/ EXISTING CONDITIONS & OR ARCHITECT & ENGINEERS.
3. INTERIOR PARTITIONS ARE DIMENSIONED TO CENTER LINE


NOTE: CONTRACTOR TO VERIFY THAT THE MOUNTING HEIGHTS OF ALL WALL MOUNTED FIXTURES (I.E. PLUMBING FIXTURES GRAB BARS, MIRRORS, ETC.) MEET ALL APPLICABLE CODES & STANDARDS PRIOR TO INSTALLATION.

DENOTES ROOM NAME
 CLASSROOM
 102
 ROOM NUMBER
 (102)
 DENOTES DOOR NUMBER

STAND PIPE,
RE: FIRE PROTECTION

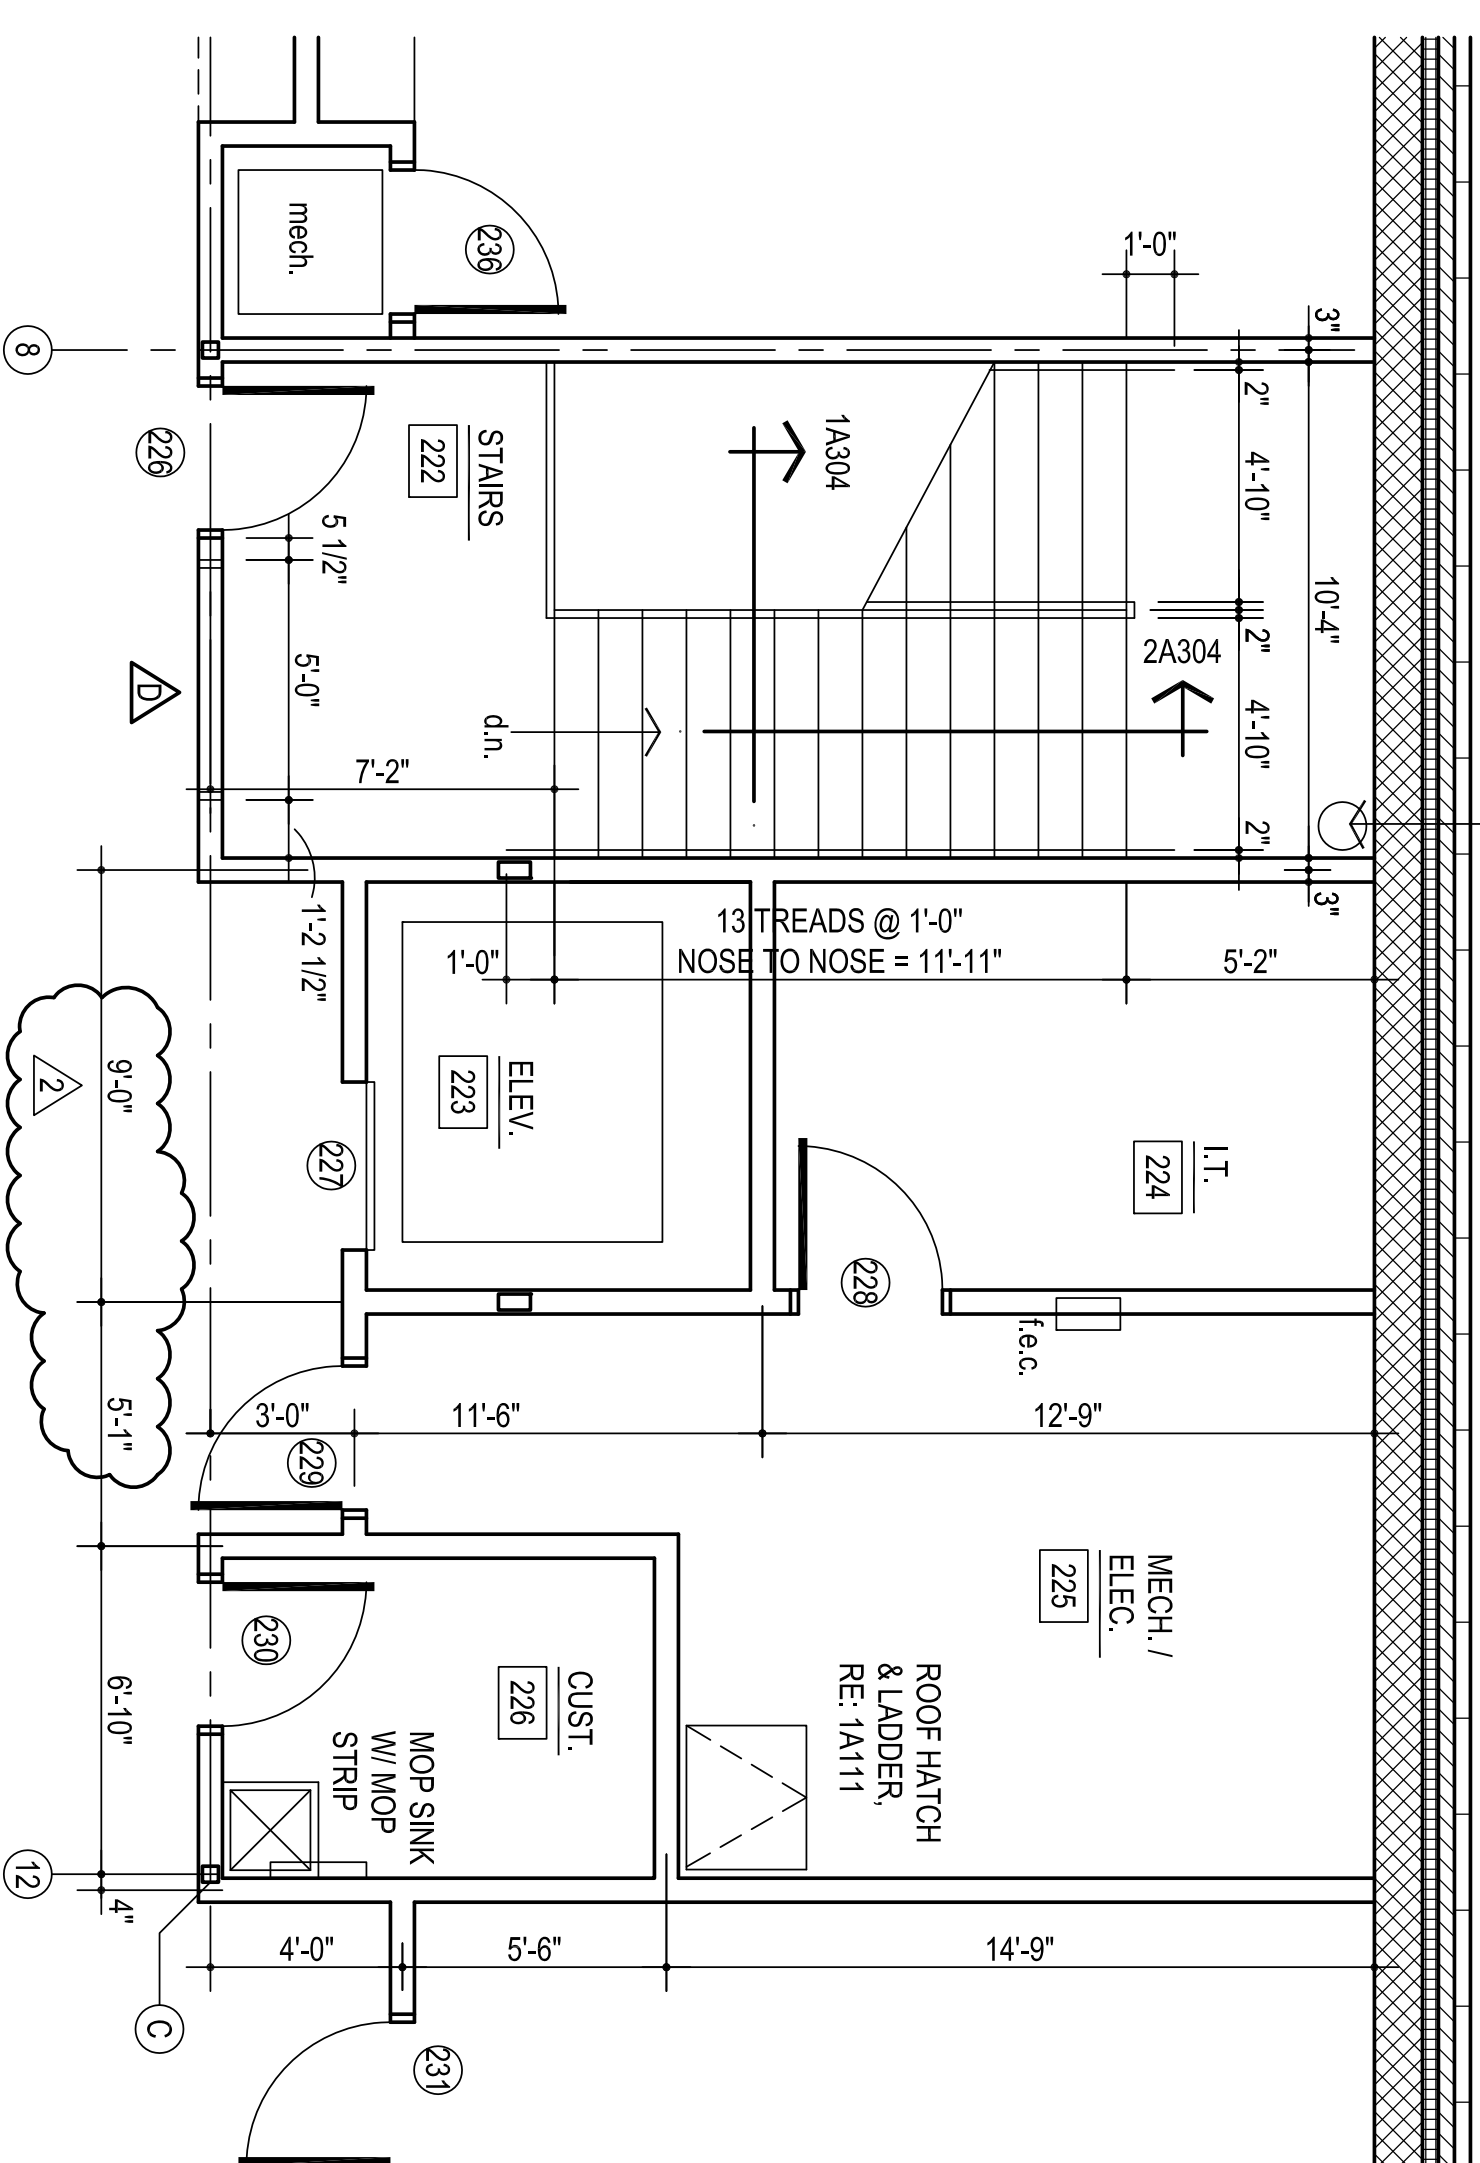


ENLARGED FLOOR PLAN
ROOM # 222, 223, 224, 225 & 226

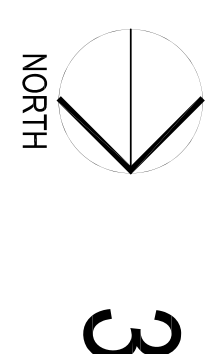



- GENERAL NOTES:
- REFER STRUCTURAL DRAWINGS FOR TOP OF FOOTING ELEVATIONS - PROVIDE ALL MATERIALS REQUIRED FOR WALL SYSTEM TO EXTEND TO TOP OF FOOTING
 - DO NOT SCALE DRAWINGS TO OBTAIN MATERIAL QUANTITIES. USE DRAWINGS WHICH ARE DIMENSIONED OR COORDINATE W/ EXISTING CONDITIONS &/OR ARCHITECT & ENGINEERS.
 - PROVIDE LABELING AS PER BC 703.7 MARKING AND IDENTIFICATION. BE LOCATED WITHIN 15 FEET (4572 MM) OF THE END OF EACH WALL AND AT INTERVALS NOT EXCEEDING 30 FEET (9144 MM) MEASURED HORIZONTALLY ALONG THE WALL OR PARTITION. INCLUDE LETTERING NOT LESS THAN 3 INCHES (76 MM) IN HEIGHT WITH A MINIMUM 3/8 INCH (.95 MM) STROKE IN A CONTRASTING COLOR (INCORPORATING THE SUGGESTED WORDING: "FIRE AND/OR SMOKE BARRIER - PROTECT ALL OPENINGS OR OTHER WORKING."
 - RE: SHEET A100 & A101 FOR PARTITIONS REQUIRED TO CLOSE-OUT TO BOTTOM OF DECKING OR STRUCTURE ABOVE.
 - AT ALL LOCATION WHERE WALLS NEED TO CLOSE-OUT, WRAP JOIST / BEAM W/ 5/8" FIRE RATED GYP. BD. ON WD. BLOCKING AS REQUIRED.
- CONT. MEMBRANE
FLASHING AND ROOFING
MEMBRANE
TYPICAL ROOF - ROOFING
SYSTEM ON 1/4" RECOVERY
BOARD ON 2 LAYERS OF
RIGID INSULATION (4" TOTAL)
ON METAL DECK
RE: STRUCTURAL

8

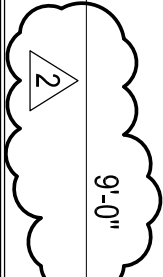

HOIST
BEAM
RE: STRUCTURAL

PROVIDE SLIP TRACK*
@ ROOF DECK /
STRUCTURE, TYP.

5/8" FIRE RATED
GYP BOARD
ON 3/8" MTL. STUDS
@ 16" O.C.

RE: 1, 2 & 3A303
FOR TYP. NOTES

STAIRS

HANDRAIL RE: SHEET A306
PAINT ALL EXPOSED
METAL HANDRAIL & MESH.

CONCRETE SLAB
RE: STRUCTURAL

5/8" FIRE RATED
GYP BOARD
EACH SIDE ON 6" MTL.
STUDS @ 16" O.C.

STAIRS

14 RAISERS = 7'-8"

14 RAISERS = 7'-8"

CLOSE-OUT UNDER STAIRS
W/ 5/8" GYP. BD. ON
3/8" MTL. STUDS @ 16" O.C.

2 LAYERS 5/8" FIRE
RATED GYP BOARD
ON 6" MTL. STUDS
@ 16" O.C.

CONCRETE SLAB
RE: STRUCTURAL

RE: STRUCT.

PROVIDE COMPACTED
ENGINEERED FILL
RE: STRUCTURAL

VAPOR
BARRIER

ELEVATOR PIT & SUMP
RE: STRUCTURAL

PROVIDE LABELING AS
PER BC 703.7 MARKING
AND IDENTIFICATION

11 LAYER 1" FIRE
RATED GYP BOARD
ON 6" MTL. STUDS
@ 16" O.C.

1 LAYER 1" FIRE
RATED GYP BOARD
ON 6" MTL. STUDS
@ 16" O.C.

2 LAYERS 5/8" FIRE
RATED GYP BOARD
ON 6" MTL. STUDS
@ 16" O.C.

MECH. / ELEC.

CONCRETE SLAB
RE: STRUCTURAL

VAPOR
BARRIER

C

D

TYPICAL ROOF - ROOFING
SYSTEM ON 1/4" RECOVERY
BOARD ON 2 LAYERS OF
RIGID INSULATION (4" TOTAL)
ON METAL DECK
RE: STRUCTURAL

CONT. MEMBRANE
FLASHING AND ROOFING
MEMBRANE

5/8" FIRE RATED
GYP BOARD ON
3/8" MTL. STUDS
@ 16" O.C.

PROVIDE LABELING AS
PER BC 703.7 MARKING
AND IDENTIFICATION

STAIRS

5/8" FIRE RATED
GYP BOARD EA.
SIDE ON 6" MTL.
STUDS @ 16" O.C.

MECH. / ELEC.

CONCRETE SLAB
RE: STRUCTURAL

PROVIDE SLIP TRACK*
@ ROOF DECK /
STRUCTURE, TYP.

RE: 1, 2 & 3A303
FOR TYP. NOTES

HANDRAIL RE: SHEET A306
PAINT ALL EXPOSED
METAL HANDRAIL & MESH.

5/8" FIRE RATED
GYP BOARD
EACH SIDE ON 6" MTL.
STUDS @ 16" O.C.

STAIRS

14 RISERS = 7'-8"

5'-2"

RUBBER TREADS
AND RISERS, TYP.

CLOSE-OUT UNDER STAIRS
W/ 5/8" GYP. BD. ON
3/8" MTL. STUDS @ 16" O.C.

RE: STRUCT WHERE
APPLICABLE

14 RAISERS = 7'-8"

FIN. FLR.

RE: STRUCT.

4A306 OPP.

2A306 OPP.

1A306 OPP.

1 WALL SECTION

1/2" = 1'-0"

2 WALL SECTION

1/2" = 1'-0"