




*Michael L. Abila*  
12/1/25



CG  
drawn by  
MA  
checked by  
NOVEMBER 2025  
date

revisions

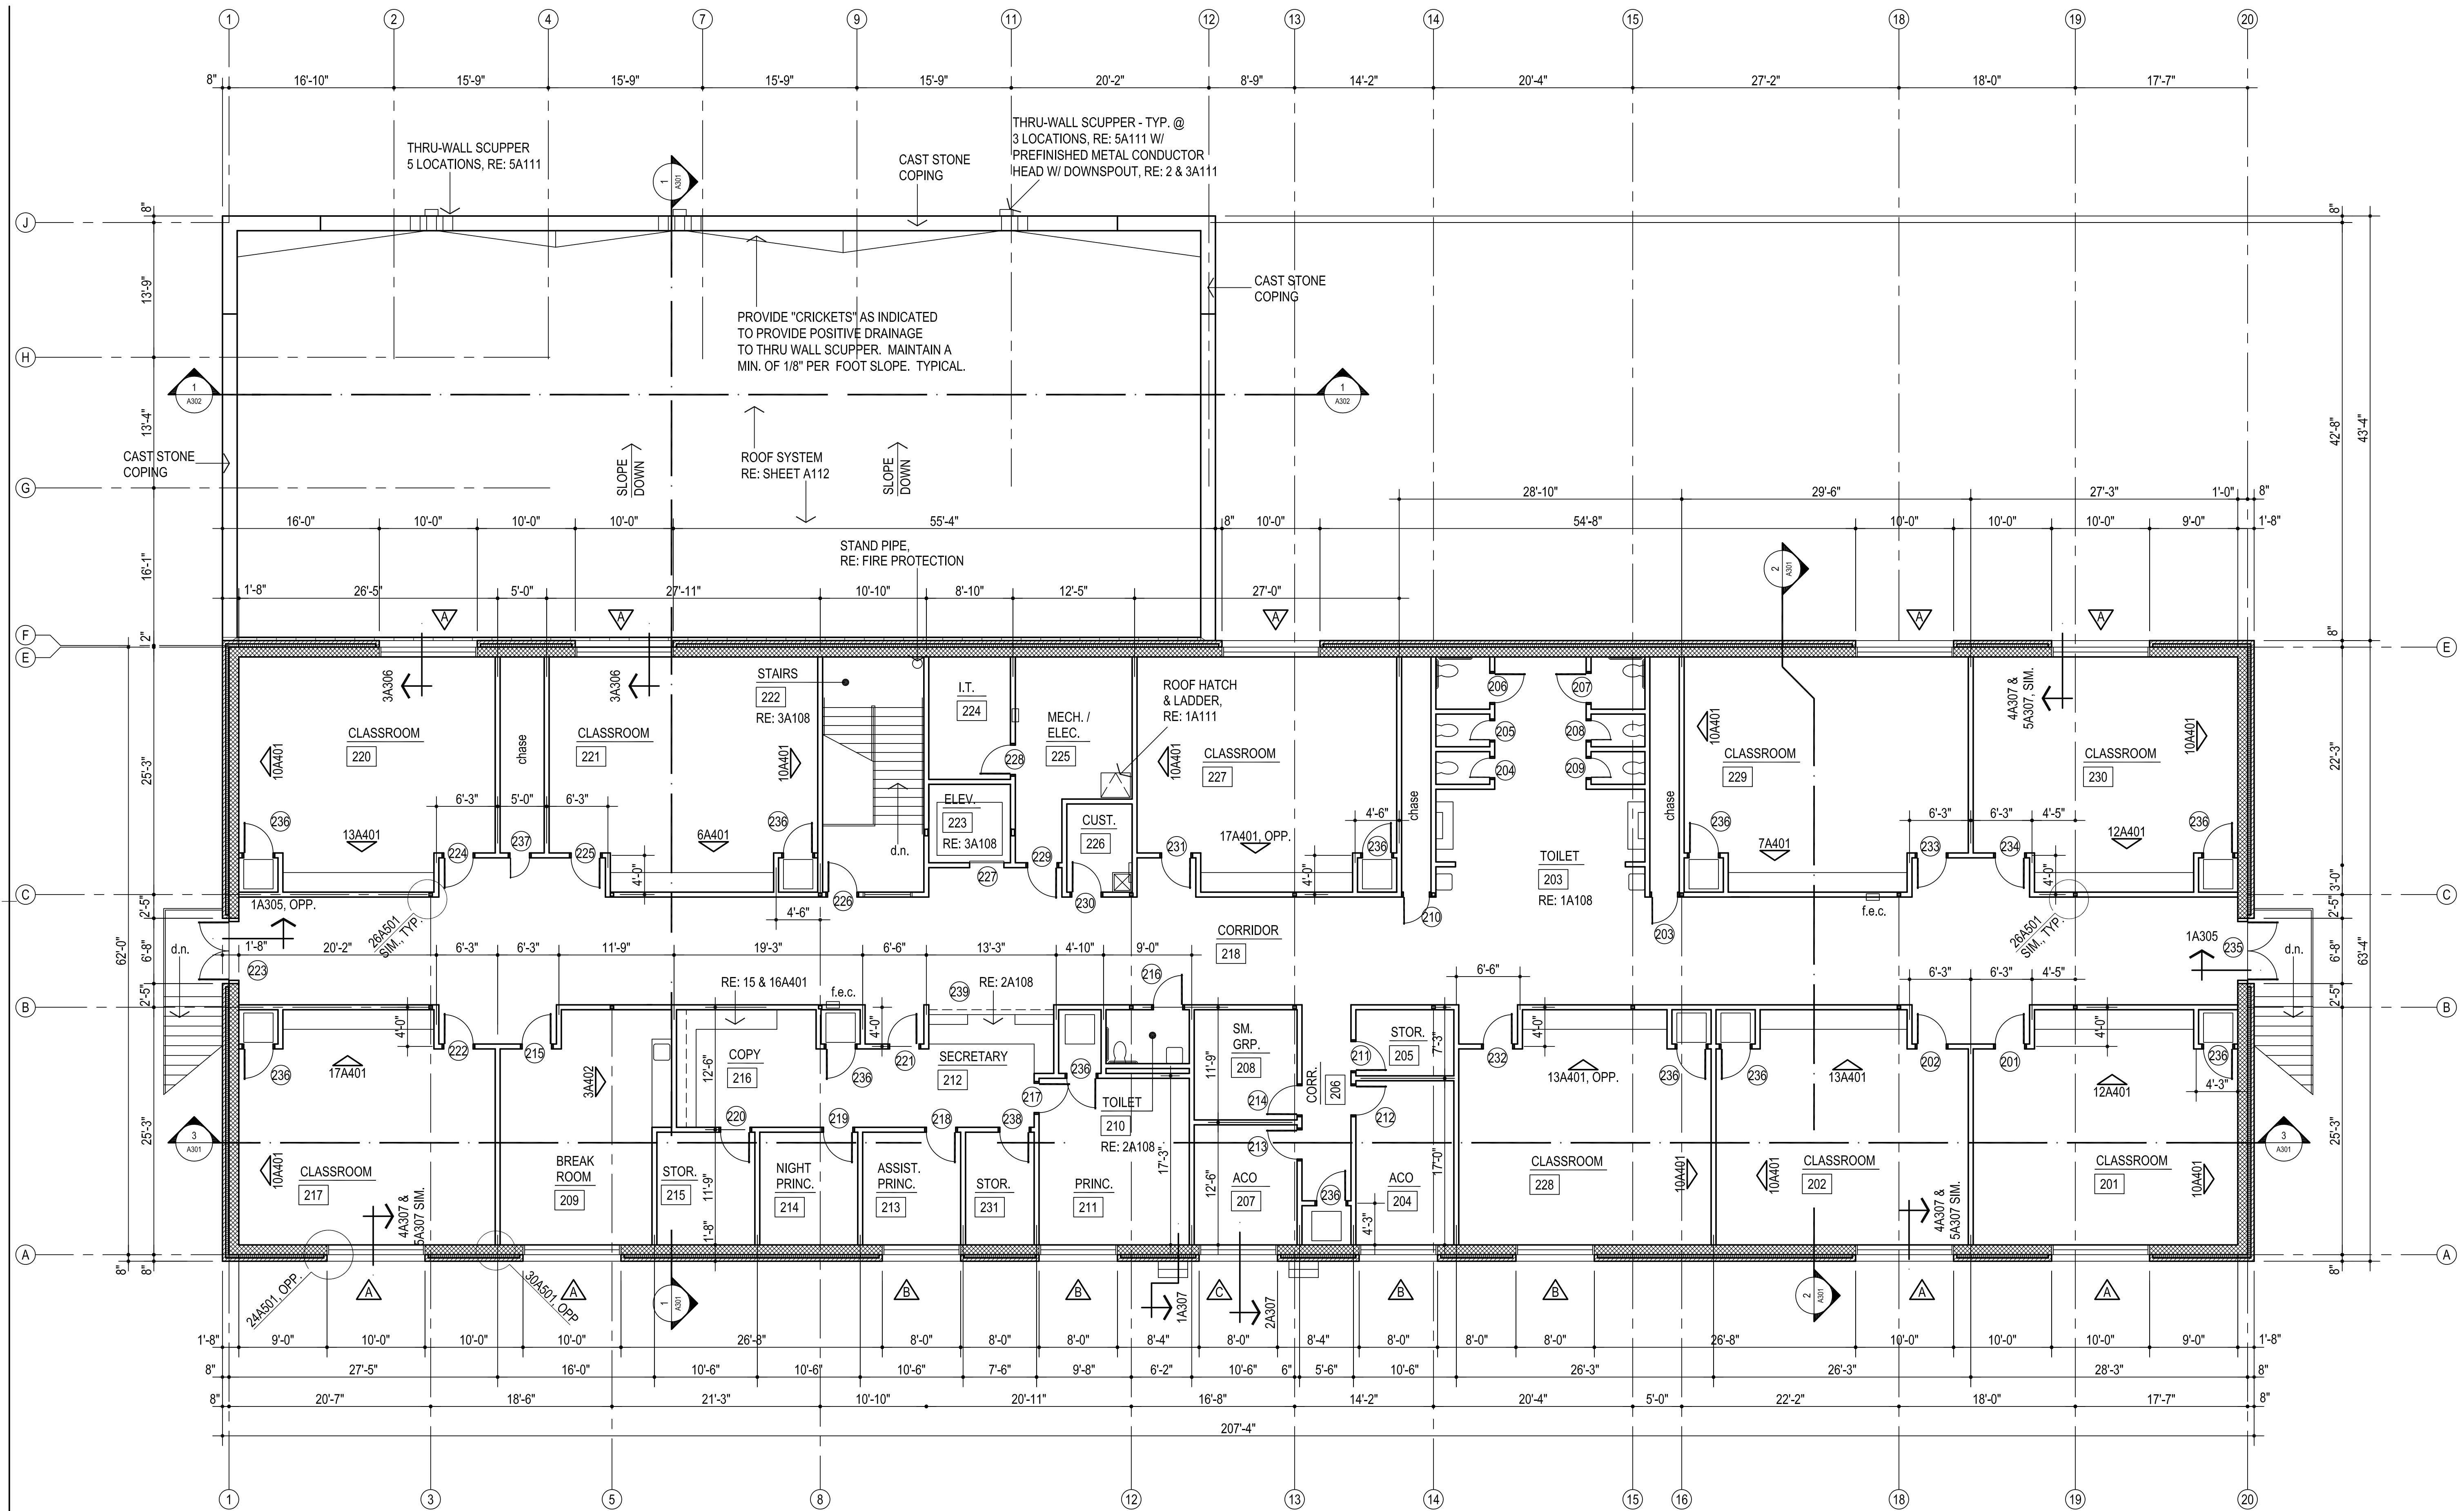

MISCELLANEOUS NOTES:

- F.E.C. - FIRE EXTINGUISHER AND CABINET
- DO NOT SCALE DRAWINGS TO OBTAIN MATERIAL QUANTITIES. USE DRAWINGS WHICH ARE DIMENSIONED OR COORDINATE W/ EXISTING CONDITIONS &/OR ARCHITECT & ENGINEERS.
- INTERIOR PARTITIONS ARE DIMENSIONED TO CENTER LINE

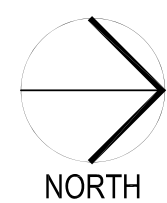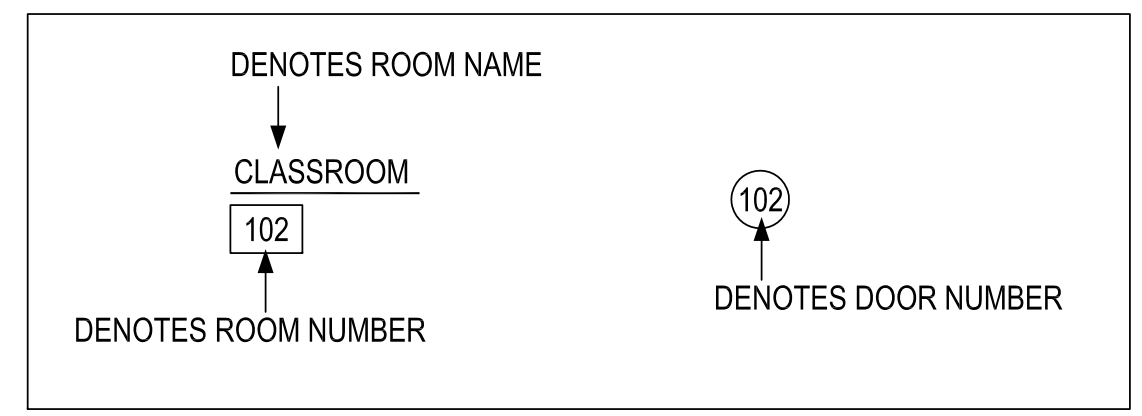

**1** SECOND FLOOR PLAN  
1/8" = 1'-0"