



PLANS, MAPS, SPECIFICATIONS, STUDIES AND REPORTS NOT CONTAINING A SEAL, IMPRINT ACCOMPANIED BY AN ORIGINAL SIGNATURE BY THE LICENSED PROFESSIONAL MAY HAVE BEEN FRAUDULENTLY ALTERED AND SHALL NOT BE CONSIDERED AN ORIGINAL COPY. ALL INFORMATION SHOULD BE DISREGARDED UNLESS VERIFIED BY THE PROFESSIONAL WHOSE SIGNATURE APPEARS BELOW.

COPYRIGHT PROTECTED
© 2025

ISSUE RECORD
DESCRIPTION DATE
ISSUE FOR PERMIT 06/22/2026

REVISION RECORD		
NO	DATE	REVISION

PROFESSIONAL SEAL



06/22/26

REMODEL

PROJECT NAME

1100 W. MAIN ST.
NORMAN, OK 73069

PROJECT NUMBER
26-0061

 
 
 
SHEET TITLE
REFLECTED CEILING
PLAN - MEZZANINE

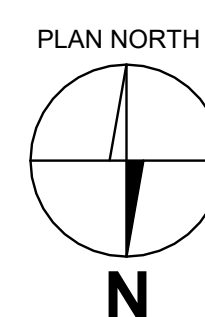
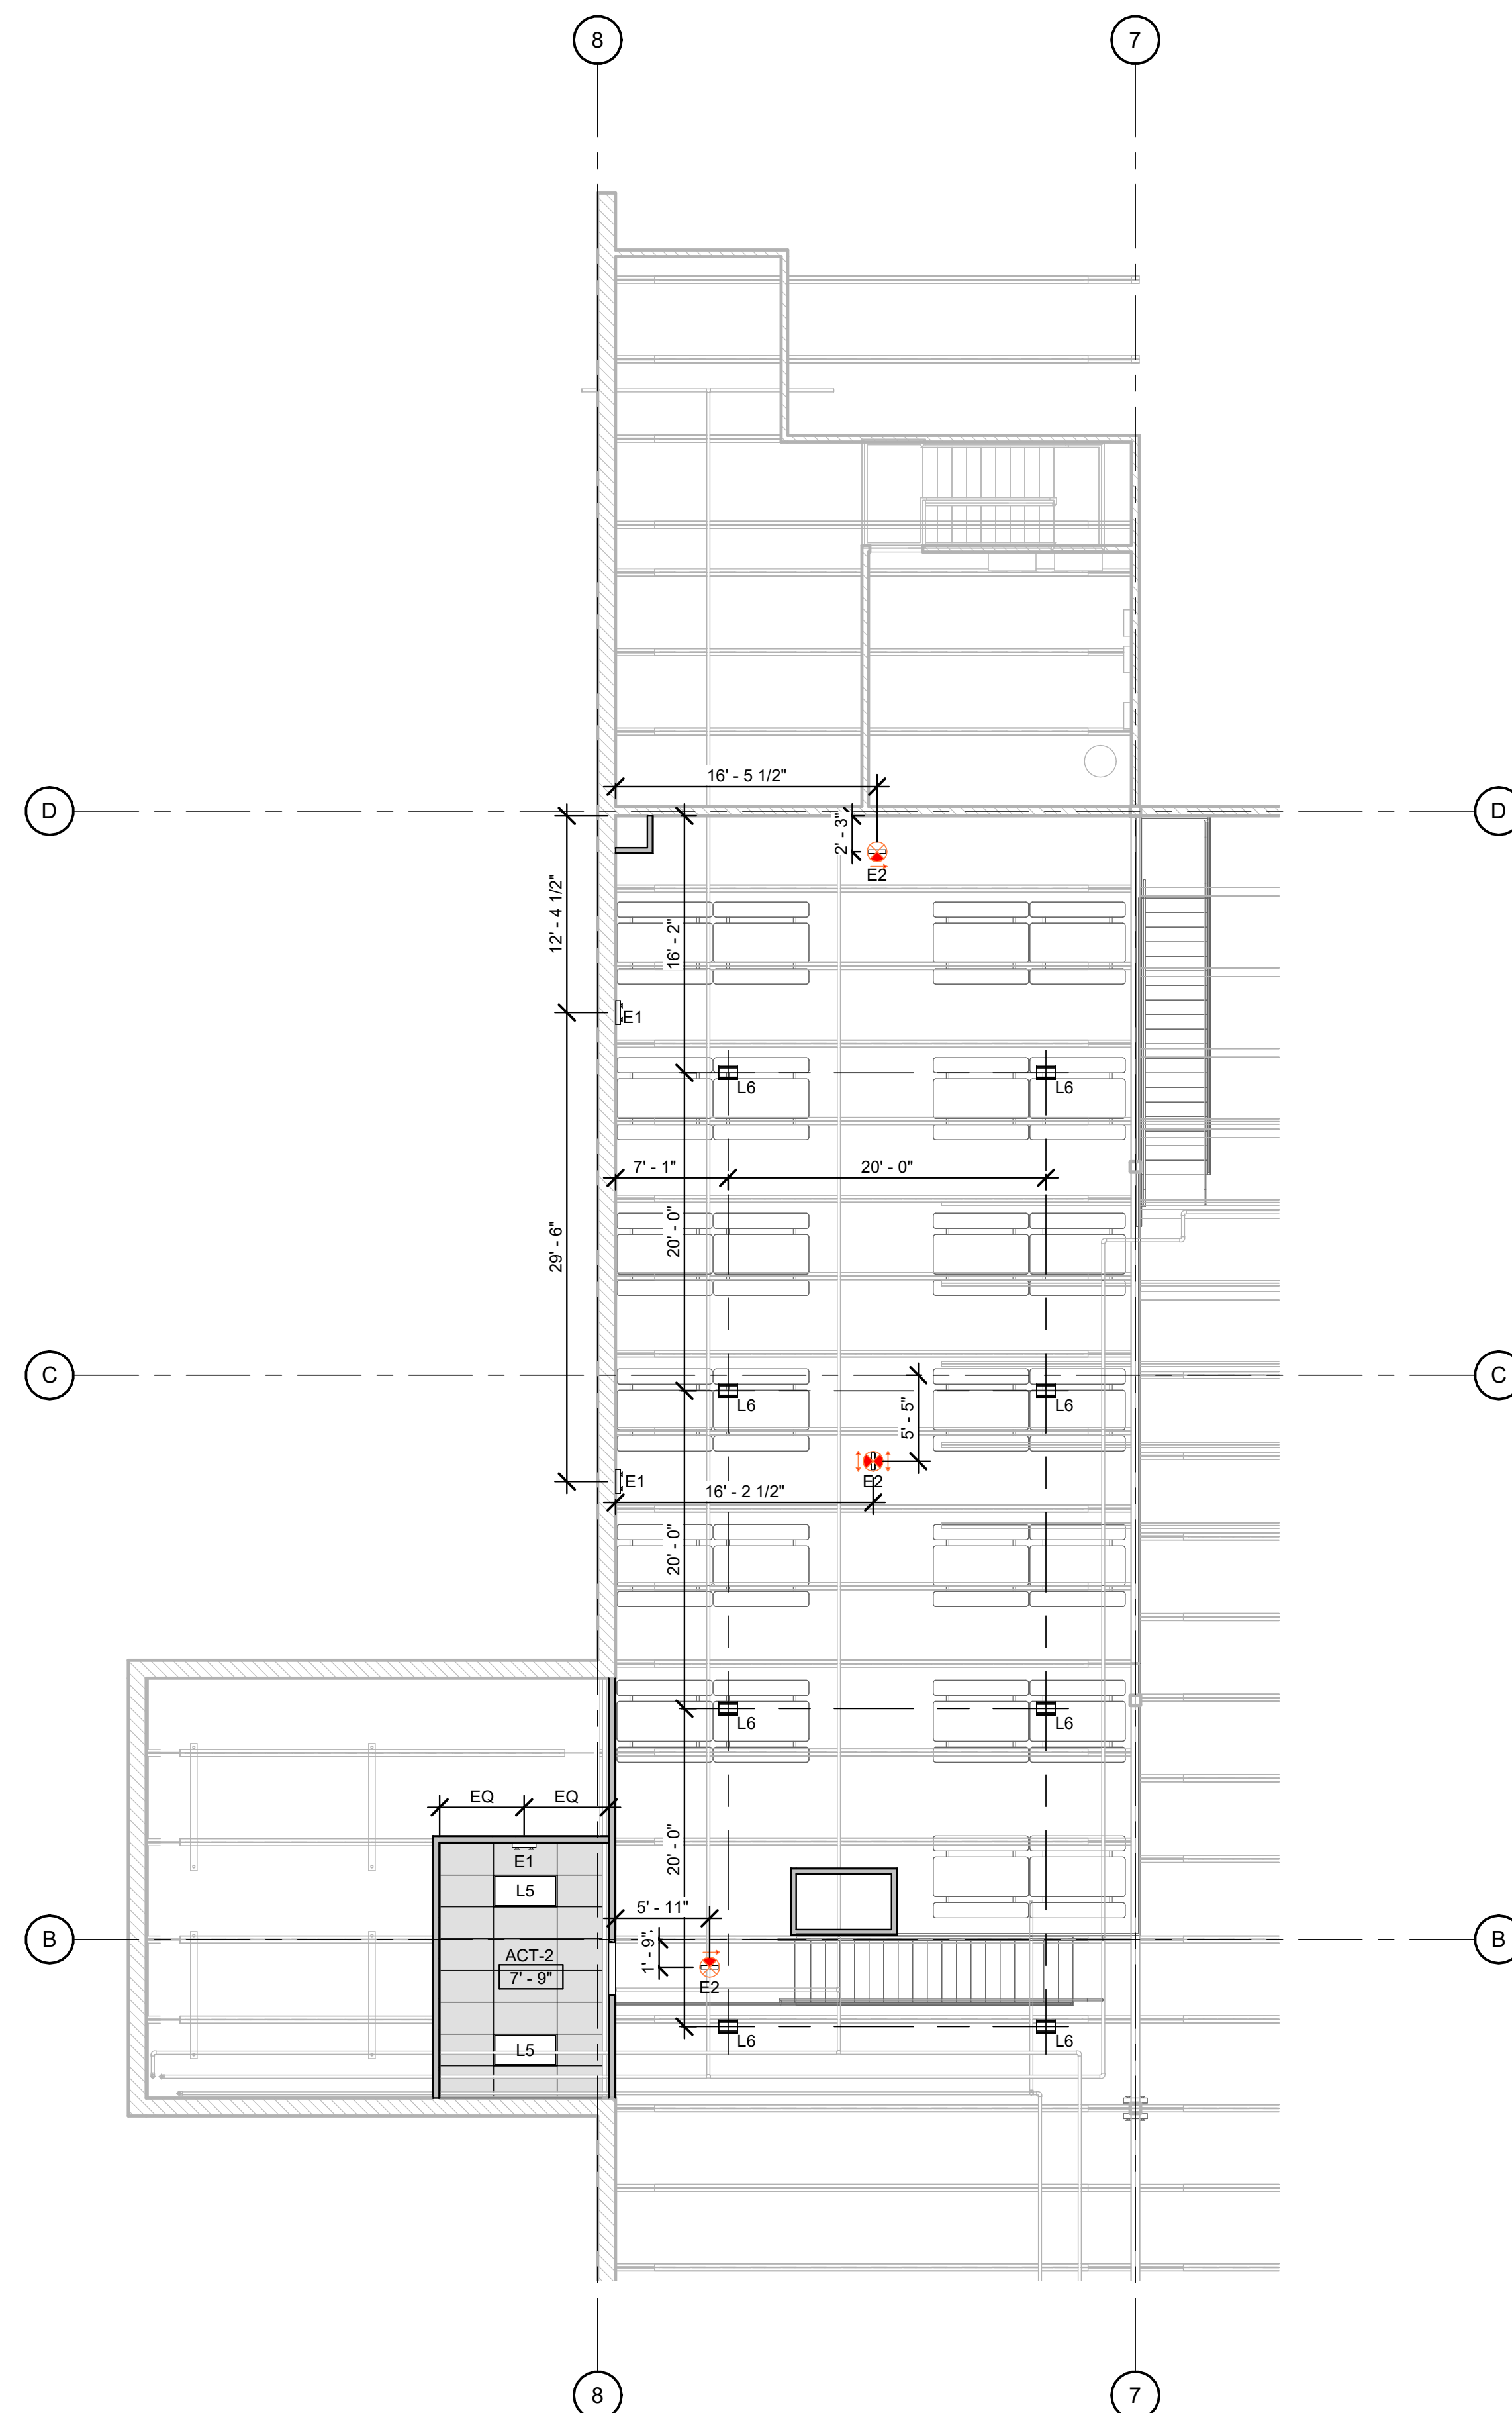
SHEET NUMBER

A132

MARK		CEILING FINISH SCHEDULE	CEILING LEGEND	REFLECTED CEILING PLAN NOTES
		DESCRIPTION		
CEILINGSS				
ACT-1		2'x4' ARMSTRONG TYPE FISSURED #1728 LAY-IN CEILING PANELS W/ PRELUDE ML 1510" GRID SYSTEM COLOR: WHITE, GRID: WHITE OR APPROVED EQUAL.	ACT-1: 2x4 SUSPENDED CEILING TILE	1. STUDY & COMPARE THE REFLECTED CEILING PLANS WITH THE MECH & ELEC DRAWINGS FOR LUMINAIRES, DIFFUSERS, & GRILLES. REPORT TO THE ARCHITECT ANY ERROR, INCONSISTENCY, OR OMISSION DISCOVERED. 2. IN THE EVENT OF INCONSISTENCIES BETWEEN ARCHITECTURAL & CONSULTANT PLANS, THE ARCHITECTURAL SHEET SHALL TAKE PRECEDENCE. REPORT DISCREPANCIES PRIOR TO PROCEEDING WITH AFFECTED WORK.
ACT-2		2'x4' ARMSTRONG SUSPENDED VINYL FACED GYP. BD. W/ T-BAR GRID AT KITCHEN AREAS OR PROVIDE EQUAL USG PRODUCT	ACT-2: 2x4 SUSPENDED VINYL FACED GYP BD	3. VERIFY & PROVIDE ACCESS PANELS OF APPROPRIATE SIZE & TYPE ARE INSTALLED IN GYPSUM BOARD CEILING/S OFFITS OR ANY OTHER NON-ACCESSIBLE TYPE CEILINGS OR OFFITS WHERE ACCESS, SERVICE OR ADJUSTMENT TO MEP ITEMS MAY BE REQUIRED.
GYP-1		GYPSUM WALLBOARD PAINT WHITE WITH SEMI-GLOSS FINISH	GYP-1: GYPSUM WALLBOARD PAINT WHITE WITH SEMI-GLOSS FINISH	4. ALL DIFFUSERS & ACCESS PANELS TO MATCH ADJACENT CEILING SURFACE. CONFIRM FINAL SELECTIONS WITH OWNER/ARCHITECT 5. SPRINKLER HEADS, DIFFUSERS, INCANDESCENT LUMINAIRES, & OTHER SURFACE-MOUNTED OR RECESSED CEILING ITEMS SHALL BE LOCATED IN THE CENTER OF THE CEILING PANELS, UNLESS NOTED OTHERWISE. 6. SEE MECHANICAL & ELECTRICAL DWGS FOR INFO & SPEC CONCERNING FIXTURES SHOWN ON THIS PLAN. 7. ANY LIGHT NOT DIMENSIONALLY LOCATED TO BE CENTERED IN THE CEILING TILE, CEILING AREA, OR ROOM AS APPLICABLE. ALL "CAN" TYPE FIXTURES TO BE MOUNTED IN THE CENTER OF THE CEILING TILES UNLESS NOTED OTHERWISE. 8. NEW FIRE ALARM SYSTEM TO BE INSTALLED PER NEW CONFIGURATION REQUIREMENTS & TO COMPLY WITH ALL LOCAL CODES & BUILDING REQUIREMENTS. 9. ALL PENDANT & HIGH-BAY LIGHT FIXTURES TO BE SUSPENDED FROM ALL THREAID & UNISTRUT AT 12" BELOW BOTTOM OF ROOF JOISTS U.N.O. EXPOSED ALLTHREAID & UNISTRUT TO BE PAINTED BLACK. 10. COORDINATE WITH OWNER'S VENDOR/REP FOR SECURITY SYSTEM REQUIREMENTS. 11. CENTER ACOUSTIC CEILING SYSTEM GRID WITHIN EACH ROOM, UNLESS NOTED OTHERWISE. 12. NO CUT TILES LESS THAN 3". 13. SEE MECHANICAL AND ELECTRICAL SHEETS FOR HVAC DEVICE AND LIGHT FIXTURE SPECIFICATIONS. 14. CONCEALED INSULATION TO HAVE A FLAME SPREAD RATING OF 25 OR LESS & A SMOKE DEVELOPMENT RATING OF 450 OR LESS PER ISO 720.2 15. MATERIALS WITHIN PLENUMS SHALL BE NONCOMBUSTIBLE OR SHALL BE IN COMPLIANCE WITH THE APPLICABLE REQUIREMENTS IN SECTIONS 602.3.1 THROUGH 602.3.10 PER IMC 602.3. 16. SEE ELECTRICAL DRAWINGS FOR SWITCHING AND CIRCUIT INFORMATION. 17. COORDINATE FINAL LIGHTING FIXTURE AND HVAC DEVICE LOCATION WITH ELECTRICAL AND MECHANICAL DRAWINGS. 18. ALL CEILING HEIGHTS AND MATERIALS EXISTING & NEW TO BE VERIFIED IN THE FIELD BY THE G.C.
FIRE SPRINKLER NOTE FIRE SPRINKLERS ARE A DEFERRED SUBMITTAL. FIRE SPRINKLER CONTRACTOR TO PROVIDE CAGES ABOVE ALL SPORT COURTS, IE. BASKETBALL & DODGEBALL, ETC. SPRINKLER CONTRACTOR TO COORDINATE W/ OWNER FOR ADDITIONAL CAGE LOCATIONS.				

LIGHT FIXTURE LEGEND

	L2 RECESSED CAN DOWNLIGHT MANUFACTURER: HALO MODEL: LT7C68R55B
	L3 3" SHALLOW CYLINDER LED MANUFACTURER: PORTLAND MODEL #: LERS56C-30-D010 ECM4C-3035-9730-LB-SC3-SMRC6P
	L4 2x4 RECESSED LED FLAT PANEL MANUFACTURER: METALUX MODEL #: 24CGT4540C PROVIDE "EW10LCP" FOR EMERGENCY FIXTURES
	L5 2x4 RECESSED LED FLAT PANEL MANUFACTURER: METALUX MODEL #: 24CGT5540C PROVIDE "EW10LCP" FOR EMERGENCY FIXTURES
	L6 SUSPENDED HIGH-BAY LIGHT FIXTURE MANUFACTURER: METALUX MODEL #: LHBS-1824-UNV-LB4050-U
	L7 2x4 LED TROFFER MANUFACTURER: METALUX MODEL: 24GR-S4-G-2-LDS-4200-F1-UNV- L840-CD PROVIDE SUSPENDED MOUNTING KIT
	COM EMERGENCY EGRESS EXIT SIGN COMBO MANUFACTURER: SURELITES MODEL: APXTRG
	E1 LED EMERGENCY EGRESS MANUFACTURER: SURELITES MODEL: APEL
	E2 EXIT SIGN (DIRECTIONAL) MANUFACTURER: SURELITES MODEL: APXTRG
	E3 EXTERIOR EMERGENCY EGRESS MANUFACTURER: SURELITES MODEL: APXTRG



1 REFLECTED CEILING PLAN - MEZZANINE
SCALE: 1/8" = 1'-0"