




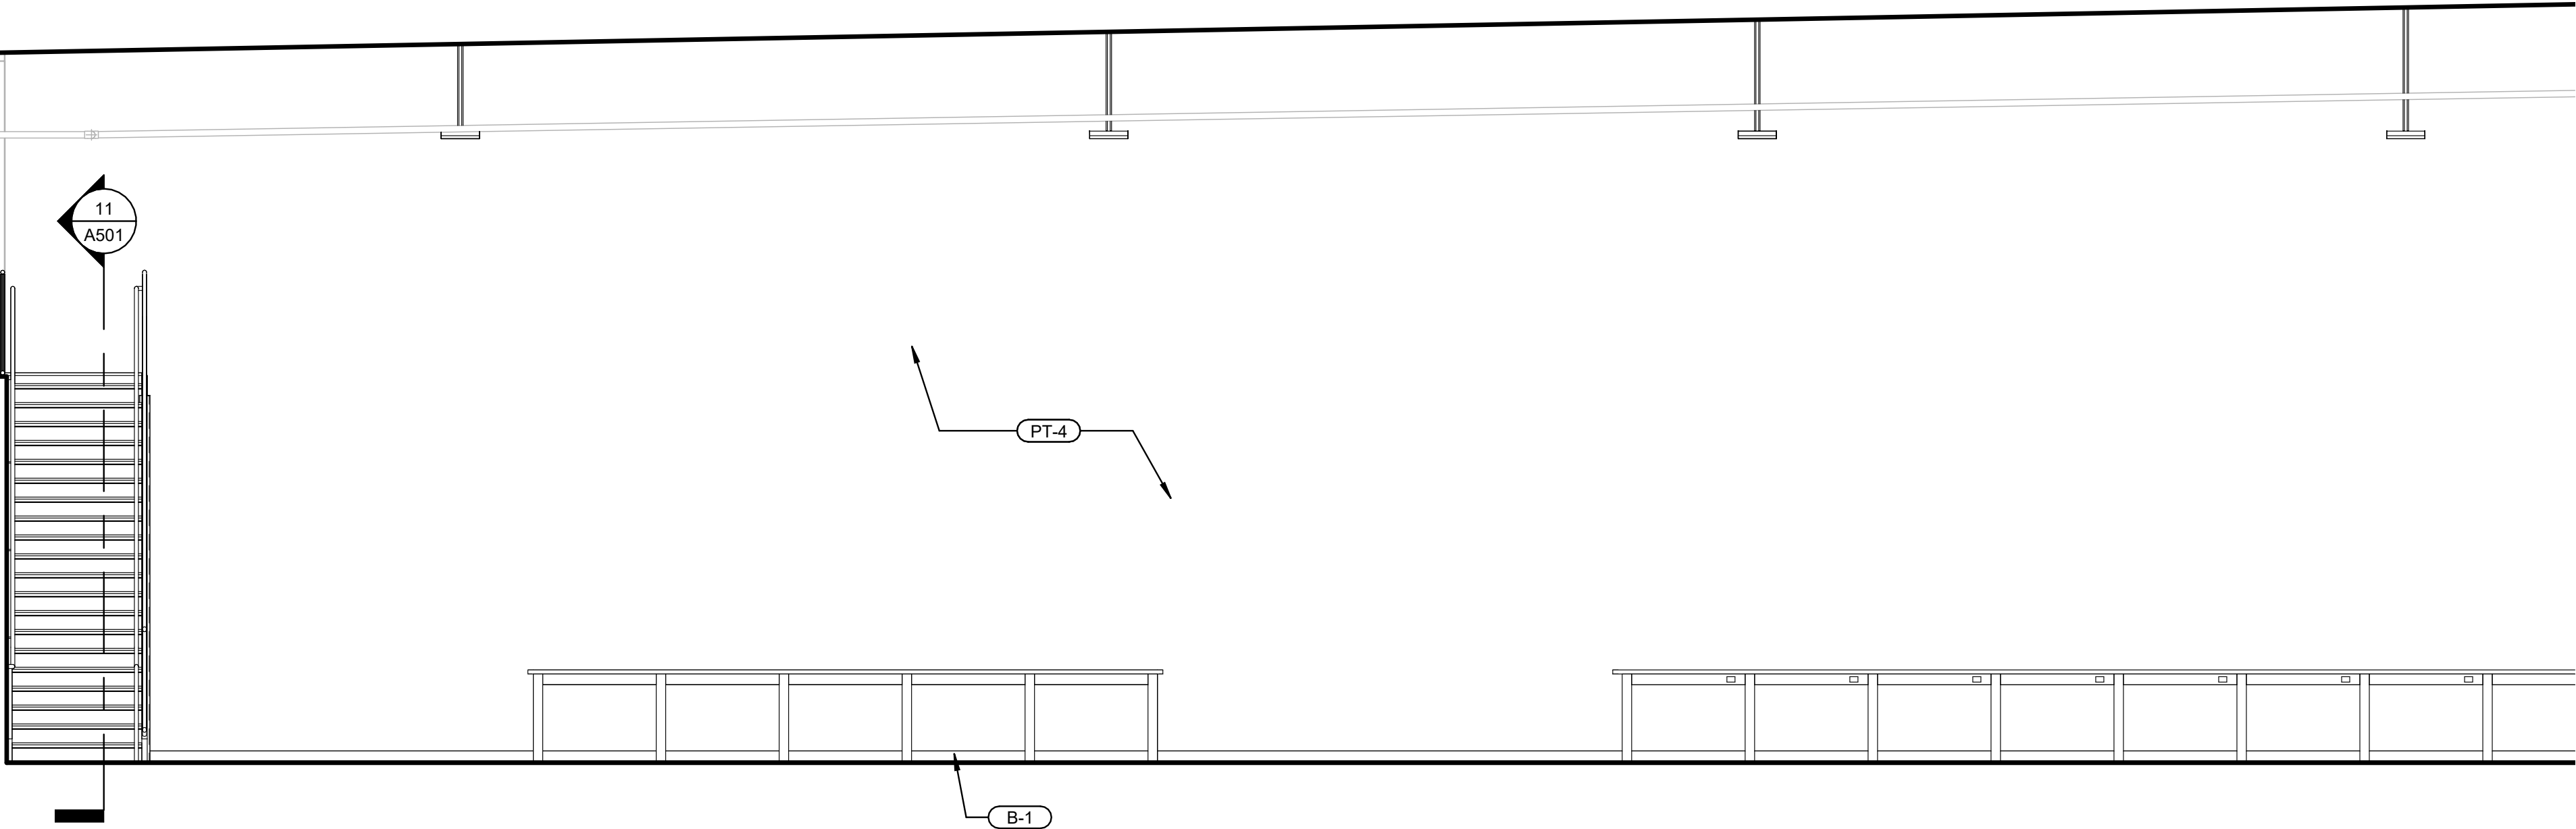

1 EXERCISE
SCALE: 1/4" = 1'-0"

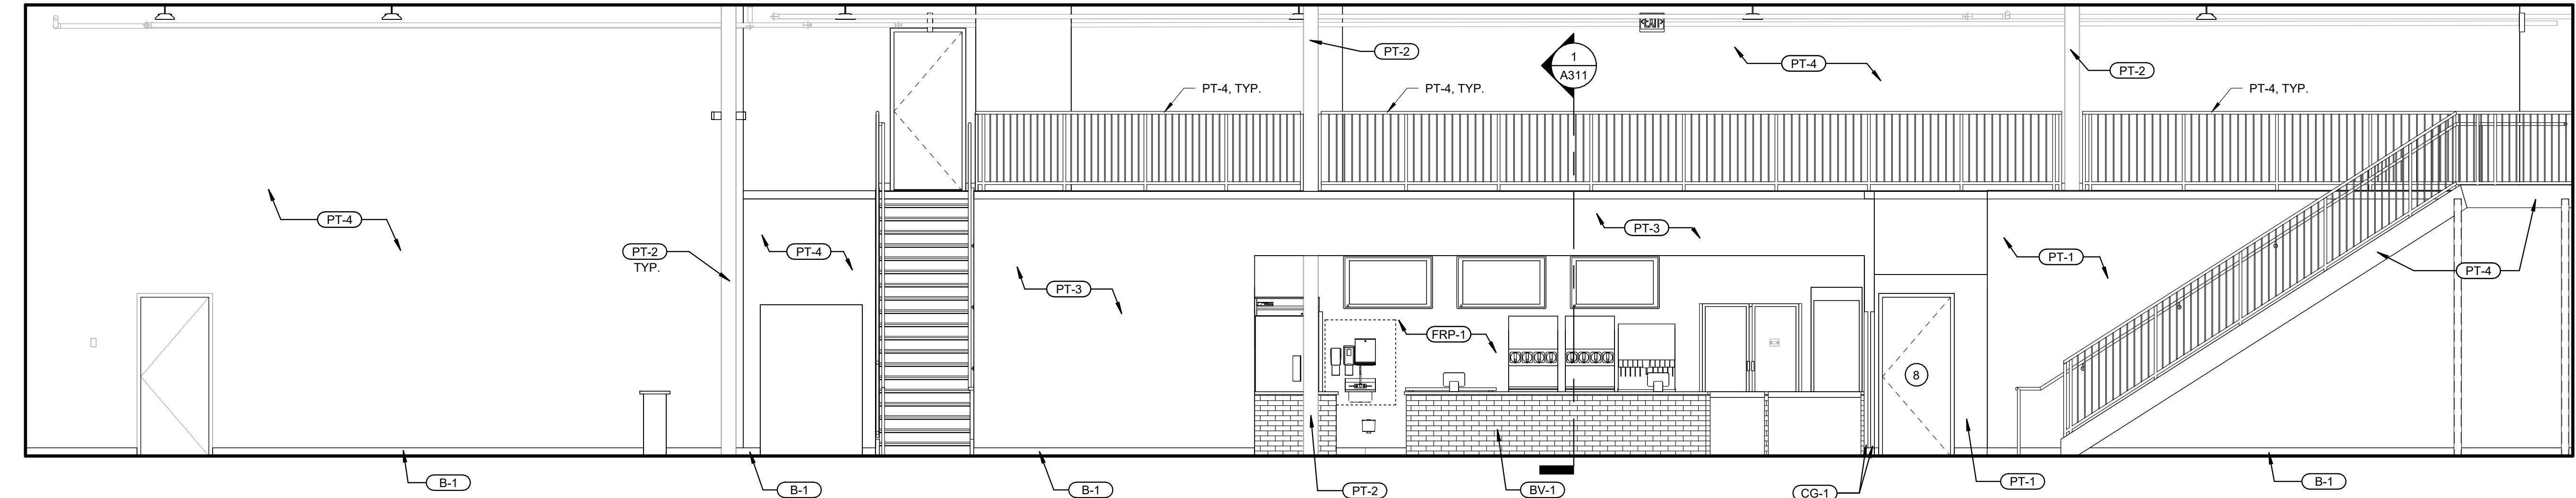

2 EXERCISE
SCALE: 1/4" = 1'-0"

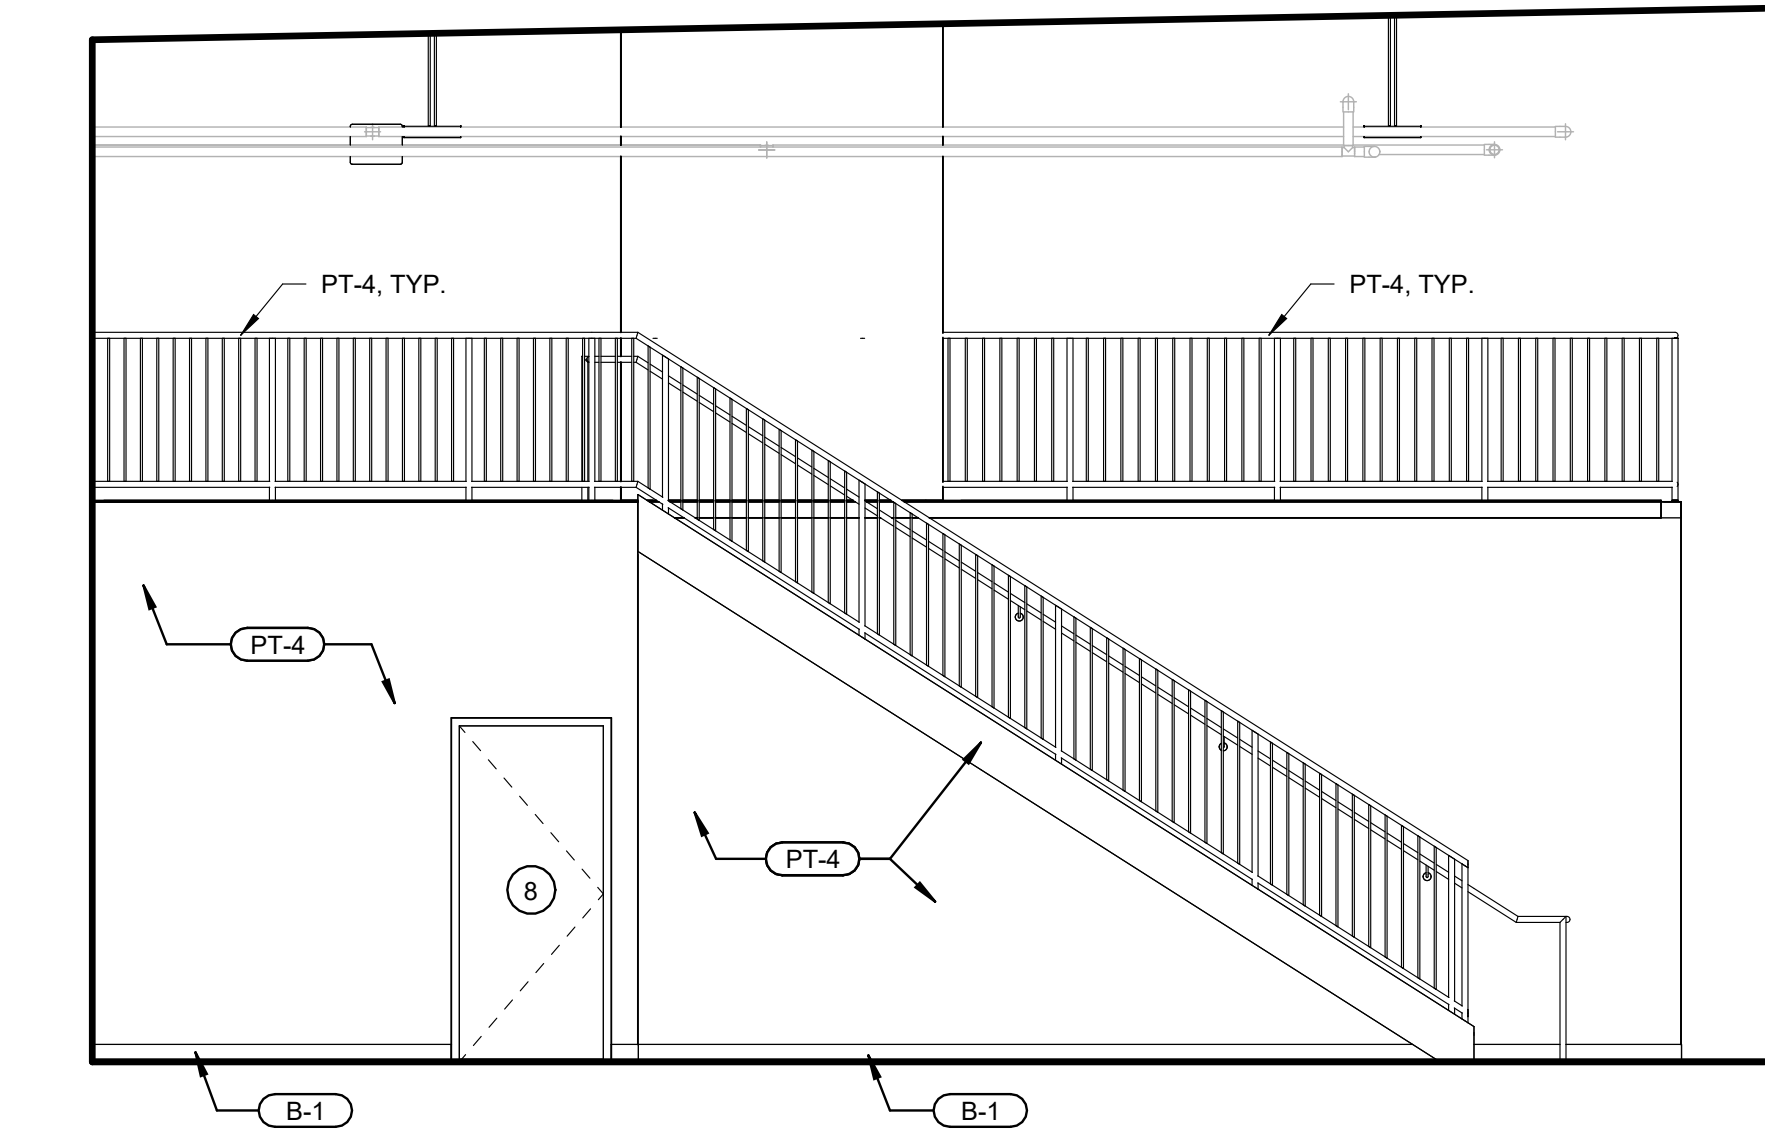

3 EXERCISE
SCALE: 1/4" = 1'-0"

INTERIOR ELEVATION GENERAL NOTES		FINISH SCHEDULE	
		MARK	DESCRIPTION
1. REFER TO SHEET A401 FOR EQUIPMENT & MEP SHEETS FOR ELECTRICAL.		B-1	4" COVED RUBBER BASE
2. WATERPROOF MEMBRANE TO EXTEND 12" ACROSS FLOOR & 12" AFF UP WALL AT NEW WALLS WHERE SHOWN. REFER TO FINISH FLOOR PLAN. USE VULKEM 360NF OR APPROVED EQUAL.		B-2	NOTES: PROVIDED BY GC, INSTALLED BY GC OWNER TO PROVIDE SPECIFICATION
3. WATERPROOF MEMBRANE MUST BE INSPECTED & APPROVED BY OWNER'S REPRESENTATIVE PRIOR TO INSTALLATION OF FINISHES.			4" TILE BASE
4. GENERAL CONTRACTOR MUST MAINTAIN ACCESS TO ALL CLEANOUTS.			TO MATCH T-3
5. ALL WALL GROUT LINES TO ALIGN WITH FLOOR TILE GROUT LINES WHERE APPLICABLE.			CUT AS REQUIRED
6. TYPICAL GYP WALLS TO BE A LEVEL 4 SMOOTH FINISH UNO.			NOTES: PROVIDED BY GC, INSTALLED BY GC REFER TO DETAIL 3/A401 (VERIFY)
7. FRP-01 TO BE INSTALLED TO 10'-0" A.F.F. UNO. IT IS TO BE INSTALLED WITH VERTICAL SEAMS & TOP CORNER TRIM PIECES AS REQUIRED OR RECOMMENDED BY MANUFACTURER.		CEILINGS	
8. REFER TO FINISH FLOOR PLAN & ENLARGED DETAILS FOR ADDITIONAL LOCATIONS OF PAINT, STONE, TILE, WALLCOVERING, &/OR SPECIAL FEATURE.		ACT-1	2'x4' ARMSTRONG FINE FISSURED #1729 LAY-IN CEILING PANELS W/ PRELUDE ML 15/16" GRID SYSTEM
9. PROVIDE MATCHING CAULK AT THE FOLLOWING AREAS:		ACT-2	2'x4' ARMSTRONG SUSPENDED VINYL FACED GYP. BD. W/ T-BAR GRID AT KITCHEN AREAS OR PROVIDE EQUAL USG PRODUCT
• DOORS FRAMES TO WALL, CEILING, &/OR FLOOR		GYP-1	GYP. WALLBOARD
• PLUMBING FIXTURES TO WALL & FLOOR			PAINT WHITE WITH SEMI-GLOSS FINISH
• FLOOR BASE TO DOOR FRAME		CORNER GUARD	
• CEILING GRID TO WALL		CG-1	2"x2"x72" PVC CORNER GUARDS FROM TOP OF BASE
10. REFER TO FINISH FLOOR PLAN & INTERIOR ELEVATIONS FOR PATTERNS &/OR DIRECTION OF FINISH MATERIAL DETAILS			COLOR: WHITE
11. SCHLUTER TRIM: REFER TO INTERIOR FINISH SCHEDULE & DETAILS		FLOORING	
12. G.C. TO PROVIDE PLYWOOD BLOCKING FOR ALL WALL MOUNTED EQUIPMENT, ARTWORK, & MILLWORK AS REQUIRED		EVA-1	ENGINEERED INTERLOCKING TILE
13. REFER TO RCP FOR LIGHT FIXTURE TYPES & BOTTOM OF FIXTURE HEIGHTS		PC-1	NOTES: PROVIDED BY OWNER, INSTALLED BY GC OWNER TO PROVIDE SPECIFICATION
14. ART WORK BY OWNER. G.C. TO COORDINATE INSTALL.		RF-1	PAINTED CONCRETE
15. GC TO FIELD VERIFY ALL PAINT COLORS W/ OWNER BEFORE ORDERING PAINT.			BLACK EPOXY PAINT
		SC-1	5 MM THICK RUBBER FLOORING
			ADHESIVE
		T-3	MANUFACTURER: MAPEI
			PRODUCT: ULTRABOND ECO 980
			RUBBER FLOOR SUPPLIED BY OWNER
			ADHESIVE BY GC, INSTALLED BY GC
			PAINTED CONCRETE
			BLACK EPOXY PAINT
			MANUFACTURER: FLORIDA TILE
			PRODUCT #: NY2LA
			SIZE: 12"x24"
			NAME: RIVERSIDE STEEL
			GROUT
			MANUFACTURER: MAPEI
			PRODUCT: UCP
			COLOR: 5022 PEWTER
		PAINT	
		PT-1	COLOR: BLUE CHIP
			MANUFACTURER: SHERWIN WILLIAMS
			PAINT MATCH #: SW6959
			FINISH: EGGSHELL
			ALTERNATES TO MATCH SHERWIN WILLIAMS #: PPG, BENJAMIN MOORE
		PT-2	COLOR: CONFIDENT YELLOW
			MANUFACTURER: SHERWIN WILLIAMS
			PAINT MATCH #: SW6911
			FINISH: SATIN
			ALTERNATES TO MATCH SHERWIN WILLIAMS #: PPG, BENJAMIN MOORE
		PT-3	COLOR: EXUBERANT PINK
			MANUFACTURER: SHERWIN WILLIAMS
			PAINT MATCH #: SW 6480
			FINISH: EGGSHELL
			ALTERNATES TO MATCH SHERWIN WILLIAMS #: PPG, BENJAMIN MOORE
		PT-4	COLOR: BLACK
			MANUFACTURER: SHERWIN WILLIAMS
			PAINT MATCH #: PPG BX50Y + 12 1/2
			FINISH: EGGSHELL
			ALTERNATES TO MATCH SHERWIN WILLIAMS #: PPG, BENJAMIN MOORE
		PT-7	COLOR: MINDFUL GRAY
			MANUFACTURER: SHERWIN WILLIAMS
			PAINT MATCH #: SW7016
			FINISH: EGGSHELL
			ALTERNATES TO MATCH SHERWIN WILLIAMS #: PPG, BENJAMIN MOORE
		PLASTIC LAMINATE	
		PL-1	PRODUCT: WILSONART PLASTIC LAMINATE
			COLOR: DESIGNER WHITE D354
			NOTES: CABINETS
		PL-2	PRODUCT: WILSONART PLASTIC LAMINATE
			COLOR: DOVE GREY D92
			NOTES: COUNTERTOPS
		PL-3	WHITE MELAMINE
			NOTES: ADJUSTABLE SHELVING
		WALLS	
		BV-1	BRICK VENEER
			FURNISHED BY OWNER, INSTALLED BY GC
			MORTAR
			MANUFACTURER: VERSABOND #2
			NAME: THIN-SET MORTAR
		FRP-1	MANUFACTURER: MARLITE
			COLOR: WHITE
			PATTERN: SUBWAY TILE PATTERN
		FRP-2	MANUFACTURER: MARLITE
			COLOR: WHITE
			PATTERN: PEBBLED
		SS-1	STAINLESS STEEL
			STANDARD MILL 20 GA "FLAT"
			PROVIDE STAINLESS TRANSITIONS
			AS REQUIRED
		T-1	PRODUCT: CANVAS MERINGUE II POLISHED CERAMIC TILE
			SKU: 100655299
			SIZE: 3"x12"
			COLOR: WHITE
			GROUT
			PRODUCT: MAPEI 5027 SILVER ULTRACOLOR PLUS FA
			GROUT
			SKU: 100221316
			COLOR: SILVER
			GROUT LINE: 1/8"
		WOOD	
			MAPLE STAINED
			NOTES: WOOD DOOR FOR OFFICE, CLOSET, JANITOR ETC

16775 ADDISON ROAD, SUITE 500
ADDISON, TX 75001
PH: (469) 960-2322

PLANS, MAPS, SPECIFICATIONS, STUDIES AND REPORTS NOT CONTAINING A SEAL IMPRINT ACCOMPANIED BY AN ORIGINAL SIGNATURE BY THE LICENSED PROFESSIONAL MAY HAVE BEEN FRAUDULENTLY ALTERED AND SHALL NOT BE CONSIDERED AN ORIGINAL COPY. ALL INFORMATION SHOULD BE DISREGARDED UNLESS VERIFIED BY THE PROFESSIONAL WHOSE SIGNATURE APPEARS BELOW. COPYRIGHT PROTECTED © 2025

ISSUE RECORD
DESCRIPTION DATE
ISSUE FOR PERMIT 06/22/2026

REVISION RECORD
NO | DATE | REVISION

PROFESSIONAL SEAL
STATE OF OKLAHOMA
JENNIFER L. HENNING
NO. 447-235
DALLAS, TEXAS
LICENSED ARCHITECT
06/22/26

REMODEL

PROJECT NAME

PROJECT NUMBER
26-0061

SHEET TITLE
INTERIOR ELEVATIONS

SHEET NUMBER
A213