




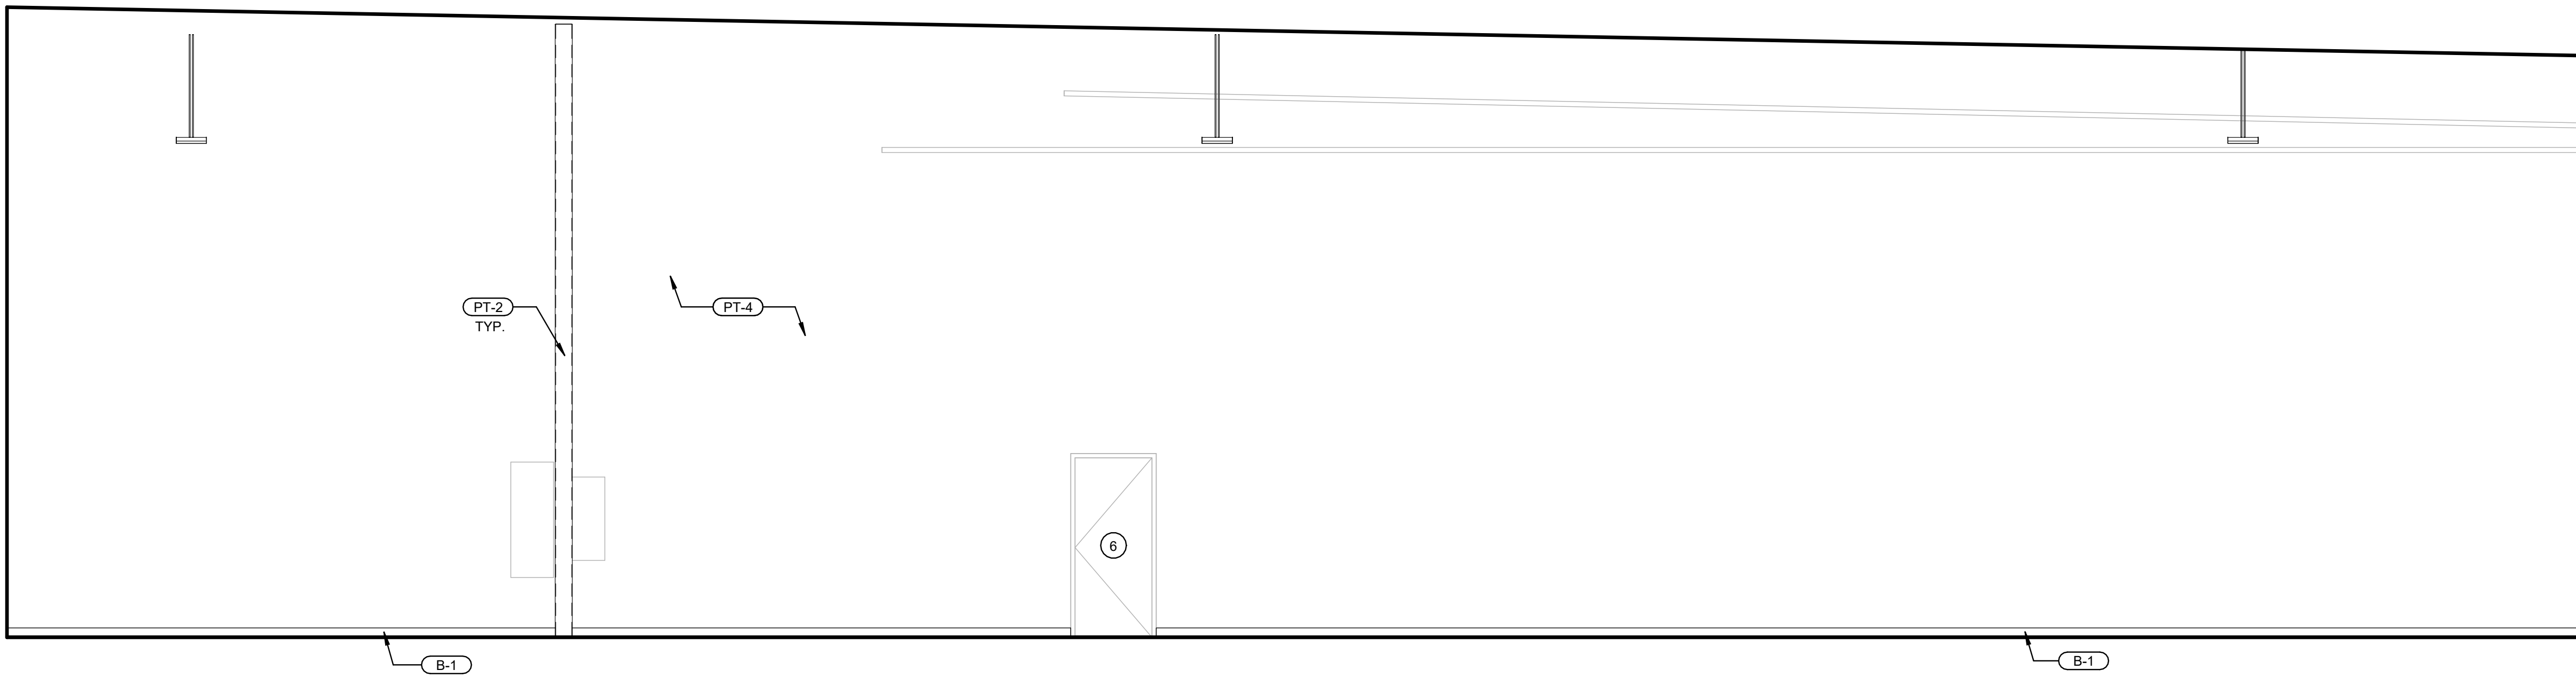


1 EXERCISE
SCALE: 1/4" = 1'-0"

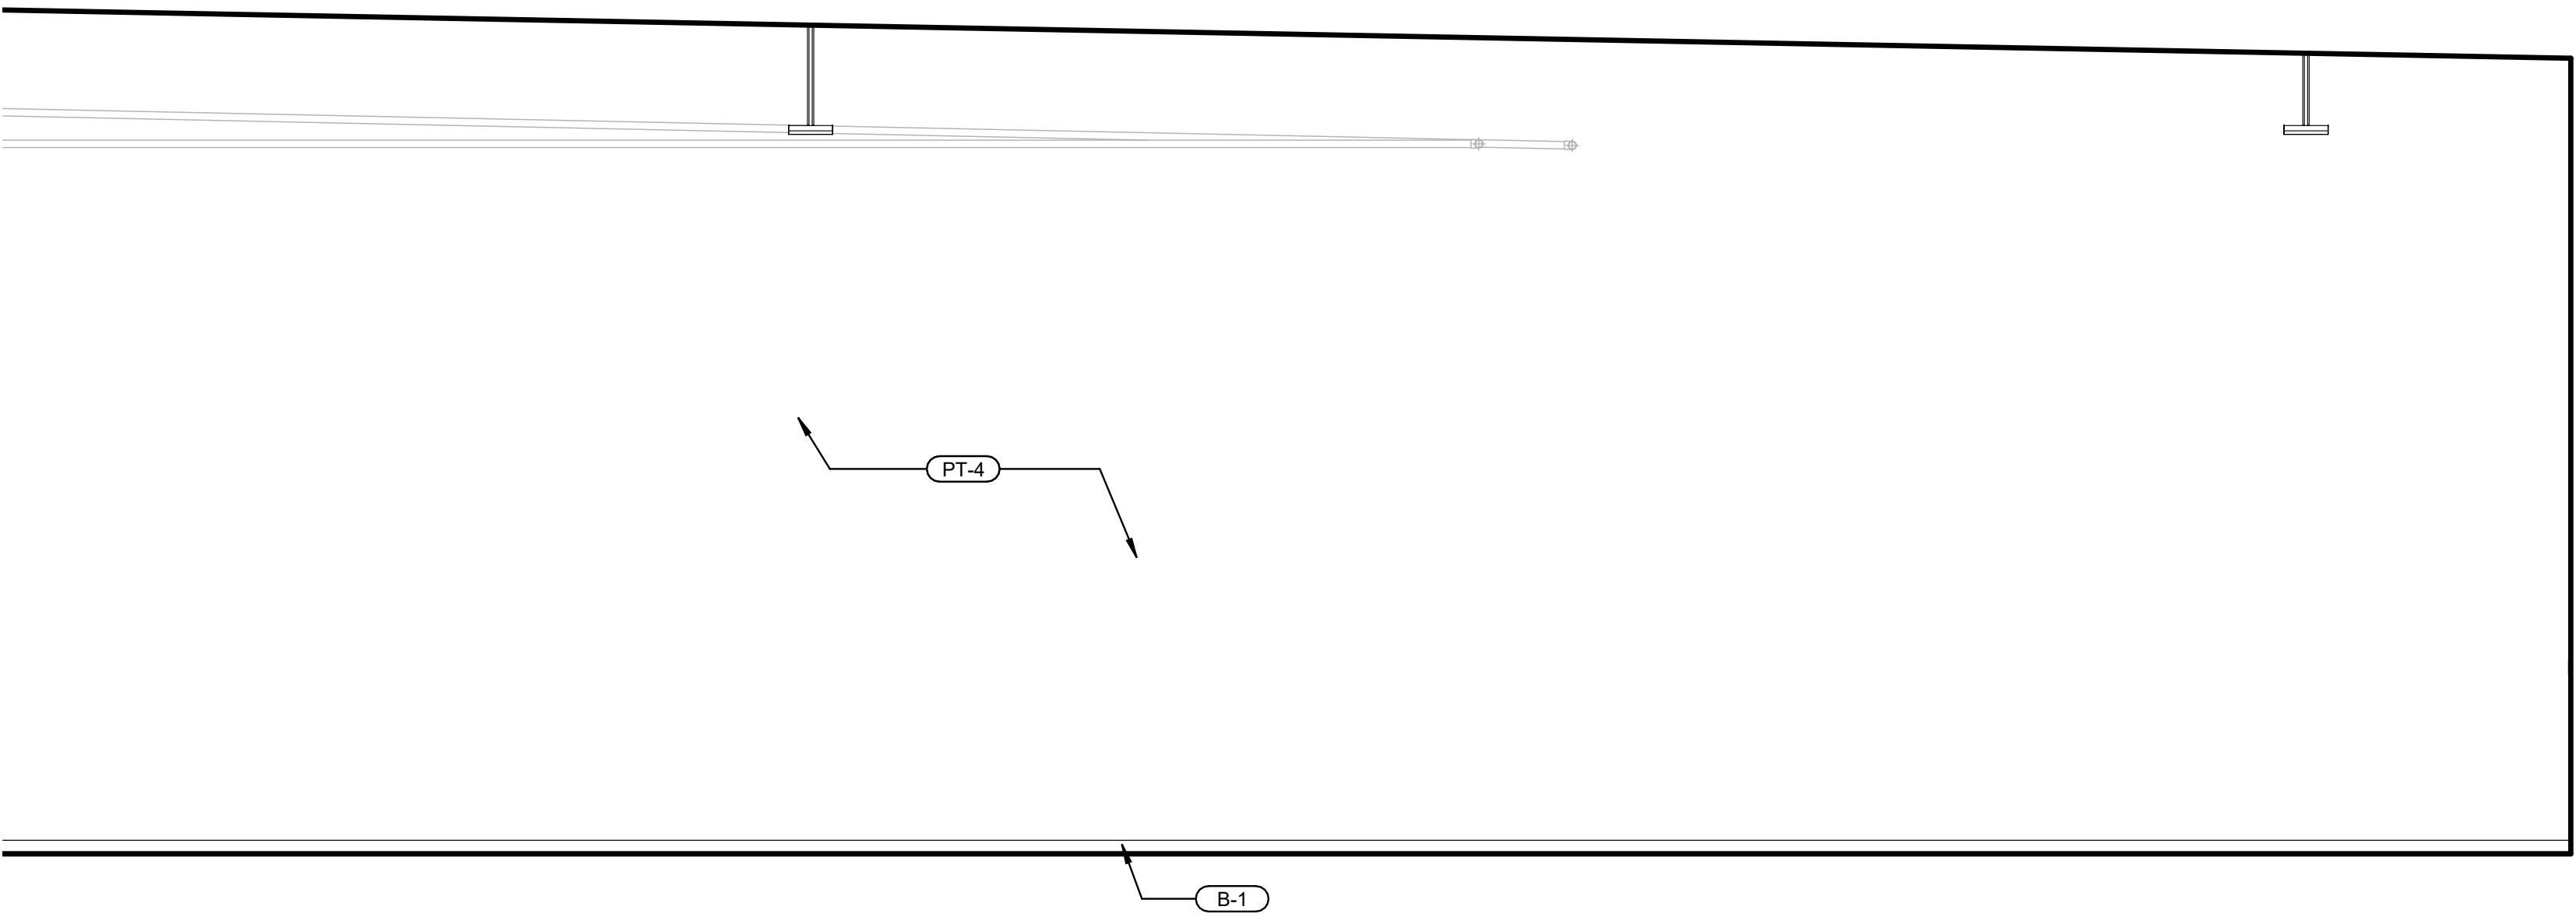


2 EXERCISE
SCALE: 1/4" = 1'-0"

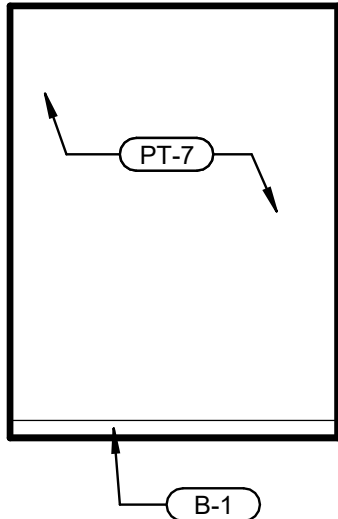


3 OFFICE
SCALE: 1/4" = 1'-0"

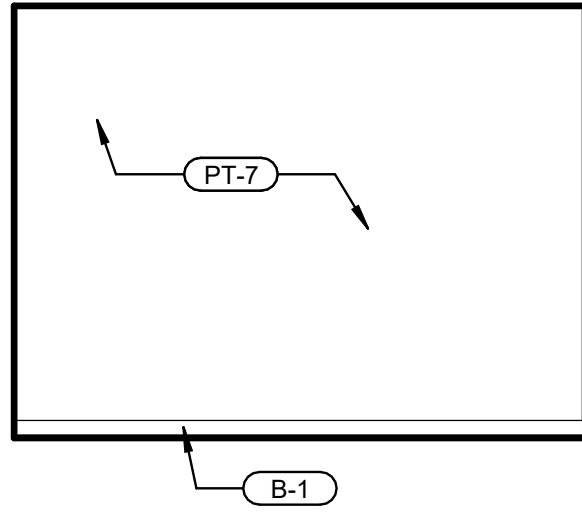


4 OFFICE
SCALE: 1/4" = 1'-0"

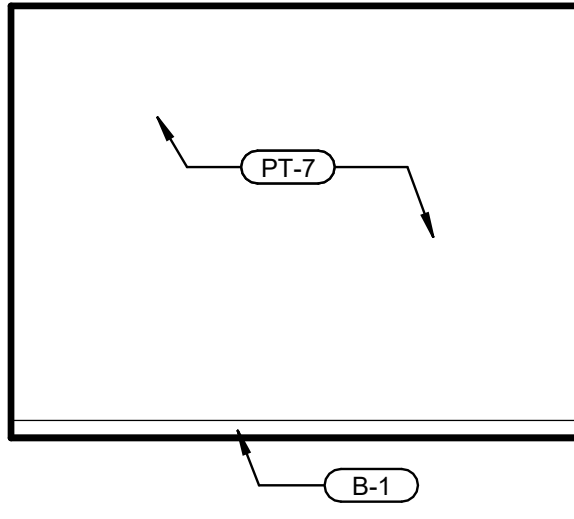


5 OFFICE
SCALE: 1/4" = 1'-0"

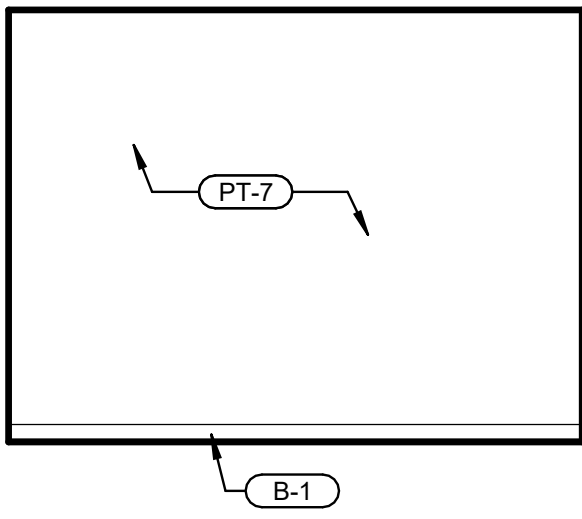


6 OFFICE
SCALE: 1/4" = 1'-0"

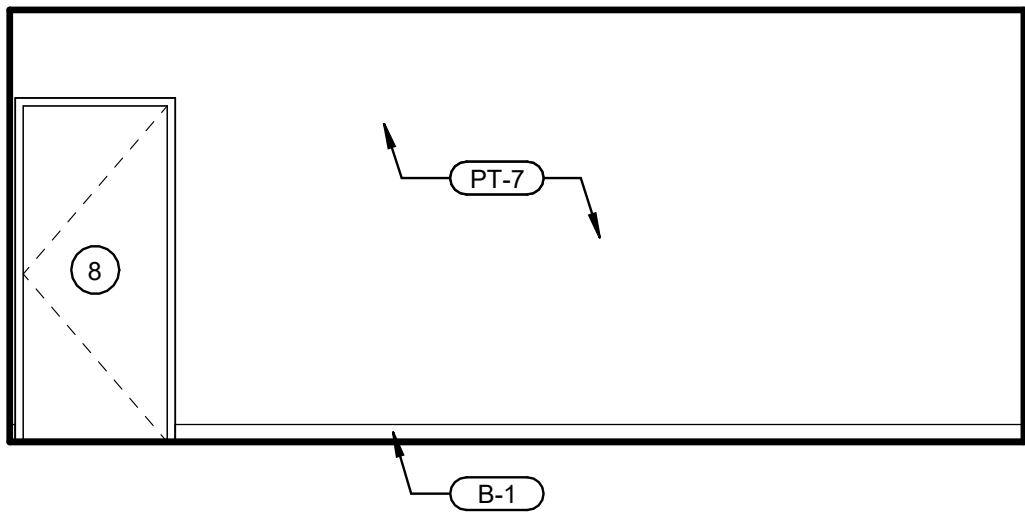


7 STORAGE
SCALE: 1/4" = 1'-0"

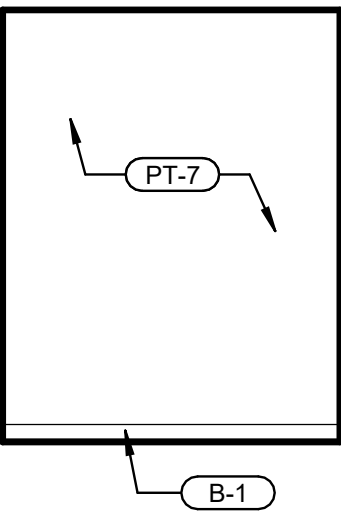


8 STORAGE
SCALE: 1/4" = 1'-0"

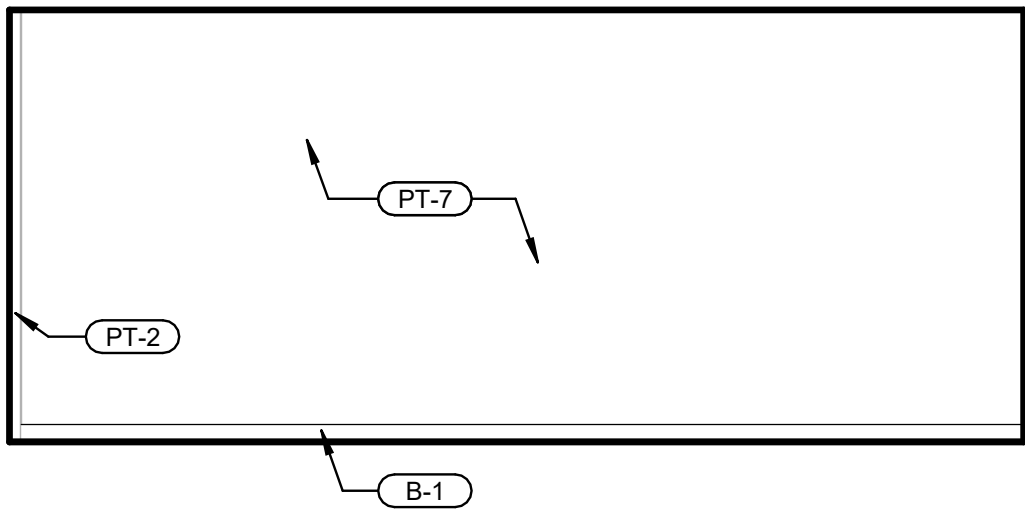


9 STORAGE
SCALE: 1/4" = 1'-0"

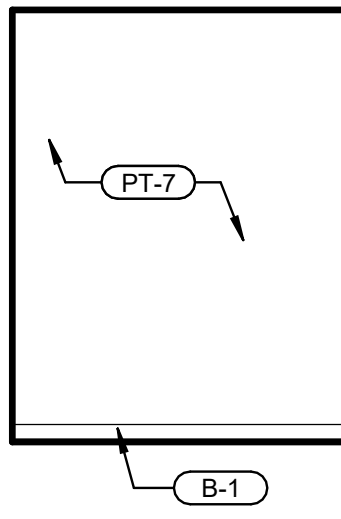


10 STORAGE
SCALE: 1/4" = 1'-0"

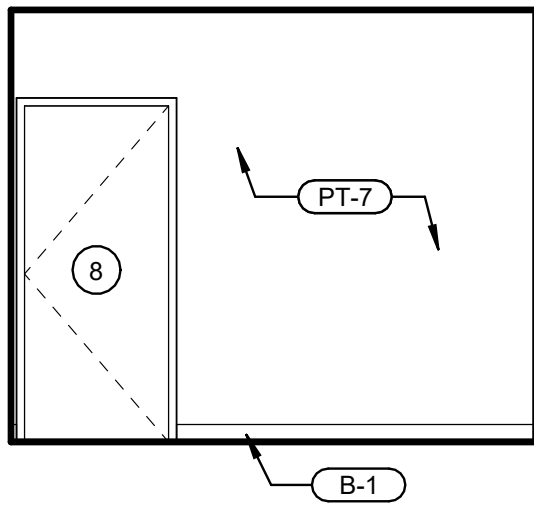


11 BREAK
SCALE: 1/4" = 1'-0"

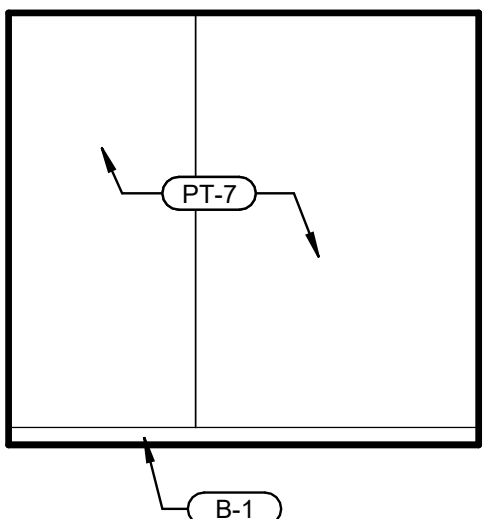


12 BREAK
SCALE: 1/4" = 1'-0"

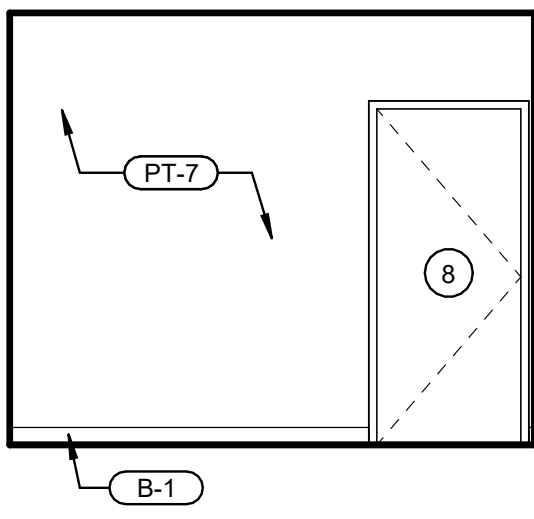


13 BREAK
SCALE: 1/4" = 1'-0"

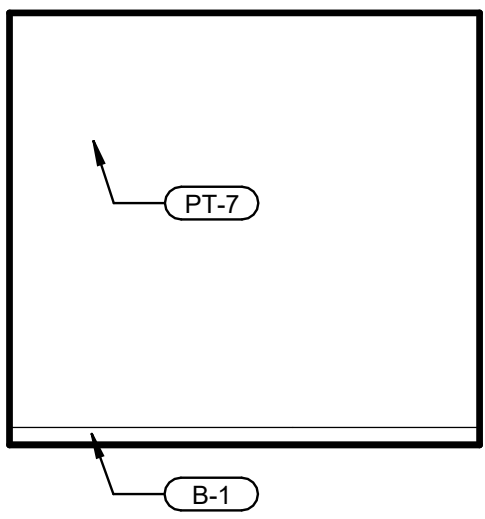


14 BREAK
SCALE: 1/4" = 1'-0"

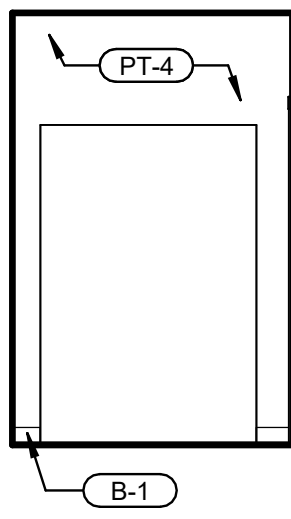


15 EXIT
SCALE: 1/4" = 1'-0"

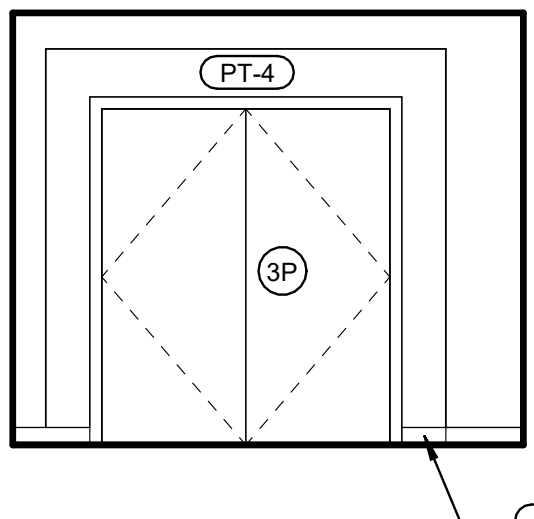

16 EXIT
SCALE: 1/4" = 1'-0"

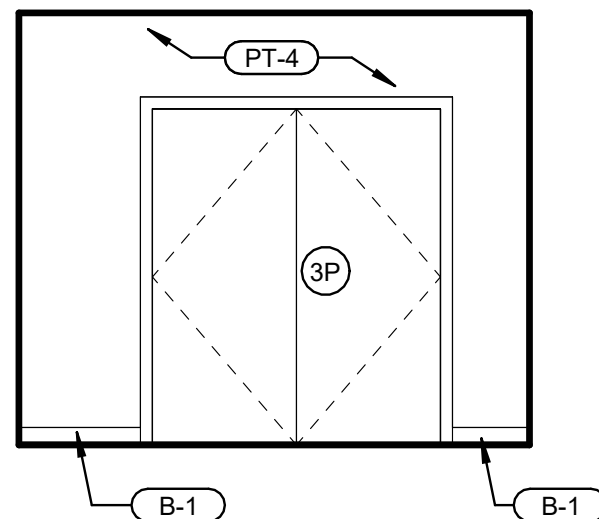

17 EXIT
SCALE: 1/4" = 1'-0"

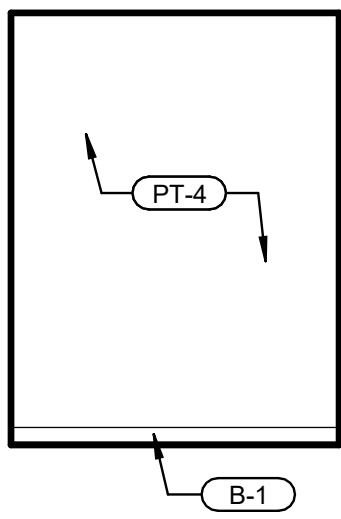

18 EXIT
SCALE: 1/4" = 1'-0"

INTERIOR ELEVATION GENERAL NOTES	
1.	REFER TO SHEET A401 FOR EQUIPMENT & MEP SHEETS FOR ELECTRICAL.
2.	WATERPROOF MEMBRANE TO EXTEND 12" ACROSS FLOOR & 12" UP WALL AT NEW WALLS WHERE SHOWN. REFER TO FINISH FLOOR PLAN. USE VULKEM 360NF OR APPROVED EQUAL.
3.	WATERPROOF MEMBRANE MUST BE INSPECTED & APPROVED BY OWNER'S REPRESENTATIVE PRIOR TO INSTALLATION OF FINISHES.
4.	GENERAL CONTRACTOR MUST MAINTAIN ACCESS TO ALL CLEANOUTS.
5.	ALL WALL GROUT LINES TO ALIGN WITH FLOOR TILE GROUT LINES WHERE APPLICABLE.
6.	TYPICAL GYP WALLS TO BE A LEVEL 4 SMOOTH FINISH UNO.
7.	FRP-01 TO BE INSTALLED TO 10'-0" A.F.F. UNO. IT IS TO BE INSTALLED WITH VERTICAL SEAMS & TOP CORNER TRIM PIECES AS REQUIRED OR RECOMMENDED BY MANUFACTURER.
8.	REFER TO FINISH FLOOR PLAN & ENLARGED DETAILS FOR ADDITIONAL LOCATIONS OF PAINT, STONE, TILE, WALLCOVERING, & OR SPECIAL FEATURE.
9.	PROVIDE MATCHING CAULK AT THE FOLLOWING AREAS: • DOORS FRAMES TO WALL, CEILING, & OR FLOOR • PLUMBING FIXTURES TO WALL & FLOOR • FLOOR BASE TO DOOR FRAME • CEILING GRID TO WALL
10.	REFER TO FINISH FLOOR PLAN & INTERIOR ELEVATIONS FOR PATTERNS & OR DIRECTION OF FINISH MATERIAL.
11.	SCHLUTER TRIM: REFER TO INTERIOR FINISH SCHEDULE & DETAILS
12.	G.C. TO PROVIDE PLYWOOD BLOCKING FOR ALL WALL MOUNTED EQUIPMENT, ARTWORK, & MILLWORK AS REQUIRED
13.	REFER TO RCP FOR LIGHT FIXTURE TYPES & BOTTOM OF FIXTURE HEIGHTS
14.	ART WORK BY OWNER. G.C. TO COORDINATE INSTALL.
15.	G.C. TO FIELD VERIFY ALL PAINT COLORS W/ OWNER. BEFORE ORDERING PAINT.

FINISH SCHEDULE	
MARK	DESCRIPTION
BASES	
B-1	4" COVED RUBBER BASE COLOR: BLACK NOTES: PROVIDED BY GC, INSTALLED BY GC OWNER TO PROVIDE SPECIFICATION
B-2	4" TILE BASE TO MATCH T-3 CUT AS REQUIRED NOTES: PROVIDED BY GC, INSTALLED BY GC REFER TO DETAIL 3/A401 (VERIFY)
CEILINGS	
ACT-1	2'x4' ARMSTRONG FINE FISSURED #1729 LAY-IN CEILING PANELS W/ PRELUDE ML 15/16" GRID SYSTEM COLOR: WHITE GRID: WHITE OR APPROVED EQUAL
ACT-2	2'x4' ARMSTRONG SUSPENDED VINYL FACED GYP. BD. W/ T-BAR GRID AT KITCHEN AREAS OR PROVIDE EQUAL USG PRODUCT
GYP-1	GYP-SUM WALLBOARD PAINT WHITE WITH SEMI-GLOSS FINISH
CORNER GUARD	
CG-1	2"x2"x72" PVC CORNER GUARDS FROM TOP OF BASE COLOR: WHITE OWNER TO PROVIDE SPECIFICATION
FLOORING	
EVA-1	ENGINEERED INTERLOCKING TILE NOTES: PROVIDED BY OWNER, INSTALLED BY GC OWNER TO PROVIDE SPECIFICATION
PC-1	PAINTED CONCRETE BLACK EPOXY PAINT
RF-1	5 MM THICK RUBBER FLOORING MANUFACTURER: MAPEI PRODUCT: ULTRABOND ECO 880 RUBBER FLOOR SUPPLIED BY OWNER ADHESIVE BY GC, INSTALLED BY GC
SC-1	PAINTED CONCRETE BLACK EPOXY PAINT
T-3	MANUFACTURER: FLORIDA TILE PRODUCT #: NY2LA SIZE: 12"x24" NAME: RIVERSIDE STEEL GROUT MANUFACTURER MAPEI PRODUCT: UCP COLOR: 5002 PEWTER
PAINT	
PT-1	COLOR: BLUE CHIP MANUFACTURER: SHERWIN WILLIAMS PAINT MATCH #: SW6959 FINISH: EGGSHELL ALTERNATES TO MATCH SHERWIN WILLIAMS #: PPG, BENJAMIN MOORE
PT-2	COLOR: CONFIDENT YELLOW MANUFACTURER: SHERWIN WILLIAMS PAINT MATCH #: SW6911 FINISH: SATIN ALTERNATES TO MATCH SHERWIN WILLIAMS #: PPG, BENJAMIN MOORE
PT-3	COLOR: EXUBERANT PINK MANUFACTURER: SHERWIN WILLIAMS PAINT MATCH #: SW 6480 FINISH: EGGSHELL ALTERNATES TO MATCH SHERWIN WILLIAMS #: PPG, BENJAMIN MOORE
PT-4	COLOR: BLACK MANUFACTURER: SHERWIN WILLIAMS PAINT MATCH #: PPG BX50Y + 12 1/2 FINISH: EGGSHELL ALTERNATES TO MATCH SHERWIN WILLIAMS #: PPG, BENJAMIN MOORE
PT-7	COLOR: MINDFUL GRAY MANUFACTURER: SHERWIN WILLIAMS PAINT MATCH #: SW7016 FINISH: EGGSHELL ALTERNATES TO MATCH SHERWIN WILLIAMS #: PPG, BENJAMIN MOORE
PLASTIC LAMINATE	
PL-1	PRODUCT: WILSONART PLASTIC LAMINATE COLOR: DESIGNER WHITE D354 NOTES: CABINETS
PL-2	PRODUCT: WILSONART PLASTIC LAMINATE COLOR: DOVE GREY D92 NOTES: COUNTERTOPS
PL-3	WHITE MELAMINE NOTES: ADJUSTABLE SHELVING
WALLS	
BV-1	BRICK VENEER FURNISHED BY OWNER, INSTALLED BY GC MORTAR MANUFACTURER: VERSABOND #2 NAME: THIN-SET MORTAR
FRP-1	MANUFACTURER: MARLITE COLOR: WHITE PATTERN: SUBWAY TILE PATTERN
FRP-2	MANUFACTURER: MARLITE COLOR: WHITE PATTERN: PEBBLED
SS-1	STAINLESS STEEL STANDARD MILL 20 GA "FLAT" PROVIDE STAINLESS TRANSITIONS AS REQUIRED
T-1	PRODUCT: CANVAS MERINGUE II POLISHED CERAMIC TILE SKU: 100655299 SIZE: 3"x12" COLOR: WHITE GROUT PRODUCT: MAPEI 5027 SILVER ULTRACOLOR PLUS FA GROUT SKU: 100221316 COLOR: SILVER GROUT LINE: 1/8"
WOOD	
	MAPLE STAINED NOTES: WOOD DOOR FOR OFFICE, CLOSET, JANITOR ETC

16775 ADDISON ROAD, SUITE 500
ADDISON, TX 75001
PH: (469) 960-2322

PLANS, MAPS, SPECIFICATIONS, STUDIES AND REPORTS NOT CONTAINING A SEAL IMPRINT ACCOMPANIED BY AN ORIGINAL SIGNATURE BY THE LICENSED PROFESSIONAL MAY HAVE BEEN FRAUDULENTLY ALTERED AND SHALL NOT BE CONSIDERED AN ORIGINAL COPY. ALL INFORMATION SHOULD BE DISREGARDED UNLESS VERIFIED BY THE PROFESSIONAL WHOSE SIGNATURE APPEARS BELOW. COPYRIGHT PROTECTED © 2025

ISSUE RECORD
DESCRIPTION DATE
ISSUE FOR PERMIT 06/22/2026

REVISION RECORD
NO | DATE | REVISION

PROFESSIONAL SEAL

REMODEL

PROJECT NAME

1100 W. MAIN ST.
NORMAN, OK 73069

PROJECT NUMBER
26-0061

SHEET TITLE
INTERIOR ELEVATIONS

SHEET NUMBER
A214