




INTERIOR ELEVATION GENERAL NOTES		FINISH SCHEDULE	
		MARK	DESCRIPTION
1. REFER TO SHEET A401 FOR EQUIPMENT & MEP SHEETS FOR ELECTRICAL. 2. WATERPROOF MEMBRANE TO EXTEND 12" ACROSS FLOOR & 12" AFF UP WALL AT NEW WALLS WHERE SHOWN. REFER TO FINISH FLOOR PLAN. USE VULKEM 360NF OR APPROVED EQUAL. 3. WATERPROOF MEMBRANE MUST BE INSPECTED & APPROVED BY OWNER'S REPRESENTATIVE PRIOR TO INSTALLATION OF FINISHES. 4. GENERAL CONTRACTOR MUST MAINTAIN ACCESS TO ALL CLEANOUTS. 5. ALL WALL GROUT LINES TO ALIGN WITH FLOOR TILE GROUT LINES WHERE APPLICABLE. 6. TYPICAL GYP WALLS TO BE A LEVEL 4 SMOOTH FINISH UNO. 7. FRP-01 TO BE INSTALLED TO 10'-0" A.F.F. UNO. IT IS TO BE INSTALLED WITH VERTICAL SEAMS & TOP/CORNER TRIM PIECES AS REQUIRED OR RECOMMENDED BY MANUFACTURER. 8. REFER TO FINISH FLOOR PLAN & ENLARGED DETAILS FOR ADDITIONAL LOCATIONS OF PAINT, STONE, TILE, WALLCOVERING, &/OR SPECIAL FEATURE. 9. PROVIDE MATCHING CAULK AT THE FOLLOWING AREAS: • DOORS FRAMES TO WALL, CEILING, &/OR FLOOR • PLUMBING FIXTURES TO WALL & FLOOR • FLOOR BASE TO DOOR FRAME • CEILING GRID TO WALL 10. REFER TO FINISH FLOOR PLAN & INTERIOR ELEVATIONS FOR PATTERNS &/OR DIRECTION OF FINISH MATERIAL. 11. SCHLUTER TRIM. REFER TO INTERIOR FINISH SCHEDULE & DETAILS 12. G.C. TO PROVIDE PLYWOOD BLOCKING FOR ALL WALL MOUNTED EQUIPMENT, ARTWORK, & MILLWORK AS REQUIRED 13. REFER TO RCP FOR LIGHT FIXTURE TYPES & BOTTOM OF FIXTURE HEIGHTS 14. ART WORK BY OWNER. G.C. TO COORDINATE INSTALL. 15. GC TO FIELD VERIFY ALL PAINT COLORS W/ OWNER BEFORE ORDERING PAINT.		BASES	
		B-1	4" COVED RUBBER BASE COLOR: BLACK NOTES: PROVIDED BY GC, INSTALLED BY GC OWNER TO PROVIDE SPECIFICATION
		B-2	4" TILE BASE TO MATCH T-3 CUT AS REQUIRED NOTES: PROVIDED BY GC, INSTALLED BY GC REFER TO DETAIL 3/A401 (VERIFY)
		CEILINGS	
		ACT-1	2'x4' ARMSTRONG FINE FISSURED #1729 LAY-IN CEILING PANELS W/ PRELUDE ML 15/16" GRID SYSTEM COLOR: WHITE GRID. WHITE OR APPROVED EQUAL
		ACT-2	2'x4' ARMSTRONG SUSPENDED VINYL FACED GYP. BD. W/ T-BAR GRID AT KITCHEN AREAS OR PROVIDE EQUAL USG PRODUCT
		GYP-1	GYPSUM WALLBOARD PAINT WHITE WITH SEMI-GLOSS FINISH
		CORNER GUARD	
		CG-1	2"x2"x72" PVC CORNER GUARDS FROM TOP OF BASE COLOR: WHITE OWNER TO PROVIDE SPECIFICATION
		FLOORING	
		EVA-1	ENGINEERED INTERLOCKING TILE NOTES: PROVIDED BY OWNER, INSTALLED BY GC OWNER TO PROVIDE SPECIFICATION
		PC-1	PAINTED CONCRETE BLACK EPOXY PAINT
		RF-1	6 MM THICK RUBBER FLOORING ADHESIVE: MANUFACTURER: MAPEI PRODUCT: ULTRABOND ECO 980 RUBBER FLOOR SUPPLIED BY OWNER ADHESIVE BY GC. INSTALLED BY GC
		SC-1	PAINTED CONCRETE BLACK EPOXY PAINT
		T-3	MANUFACTURER: FLORIDA TILE PRODUCT #: NY2LA SIZE: 12"x24" NAME: RIVERSIDE STEEL GROUT: MANUFACTURER: MAPEI PRODUCT: UCP COLOR: 5002 PEWTER
		PAINT	
		PT-1	COLOR: BLUE CHIP MANUFACTURER: SHERWIN WILLIAMS PAINT MATCH #: SW6959 FINISH: EGGSHELL ALTERNATES TO MATCH SHERWIN WILLIAMS #: PPG, BENJAMIN MOORE
		PT-2	COLOR: CONFIDENT YELLOW MANUFACTURER: SHERWIN WILLIAMS PAINT MATCH #: SW6911 FINISH: SATIN ALTERNATES TO MATCH SHERWIN WILLIAMS #: PPG, BENJAMIN MOORE
		PT-3	COLOR: EXUBERANT PINK MANUFACTURER: SHERWIN WILLIAMS PAINT MATCH #: SW 6480 FINISH: EGGSHELL ALTERNATES TO MATCH SHERWIN WILLIAMS #: PPG, BENJAMIN MOORE
		PT-4	COLOR: BLACK MANUFACTURER: SHERWIN WILLIAMS PAINT MATCH #: PPG: BX50Y + 12 1/2 FINISH: EGGSHELL ALTERNATES TO MATCH SHERWIN WILLIAMS #: PPG, BENJAMIN MOORE
		PT-7	COLOR: MINDFUL GRAY MANUFACTURER: SHERWIN WILLIAMS PAINT MATCH #: SW7016 FINISH: EGGSHELL ALTERNATES TO MATCH SHERWIN WILLIAMS #: PPG, BENJAMIN MOORE
		PLASTIC LAMINATE	
		PL-1	PRODUCT: WILSONART PLASTIC LAMINATE COLOR: DESIGNER WHITE D354 NOTES: CABINETS
		PL-2	PRODUCT: WILSONART PLASTIC LAMINATE COLOR: DOVE GREY D92 NOTES: COUNTERTOPS
		PL-3	WHITE MELAMINE NOTES: ADJUSTABLE SHELVING
		WALLS	
		BV-1	BRICK VENEER FURNISHED BY OWNER. INSTALLED BY GC MORTAR: MANUFACTURER: VERSABOND #2 NAME: THIN-SET MORTAR
		FRP-1	MANUFACTURER: MARLITE COLOR: WHITE PATTERN: SUBWAY TILE PATTERN
		FRP-2	MANUFACTURER: MARLITE COLOR: WHITE PATTERN: PEBBLED
		SS-1	STAINLESS STEEL STANDARD MILL 20 GA "FLAT" PROVIDE STAINLESS TRANSITIONS AS REQUIRED
		T-1	PRODUCT: CANVAS MERINGUE II POLISHED CERAMIC TILE SKU: 100655299 SIZE: 3"x12" COLOR: WHITE GROUT: PRODUCT: MAPEI 5027 SILVER ULTRACOLOR PLUS FA SKU: 100221316 COLOR: SILVER GROUT LINE: 1/8"
		WOOD	
			MAPLE STAINED NOTES: WOOD DOOR FOR OFFICE, CLOSET, JANITOR ETC

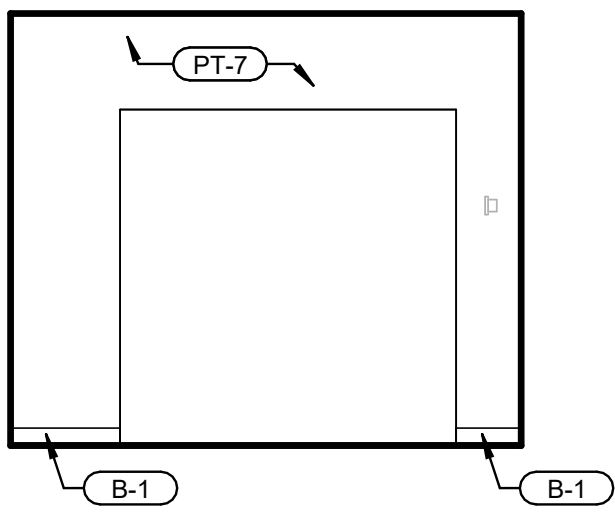


1 CORRIDOR
SCALE: 1/4" = 1'-0"

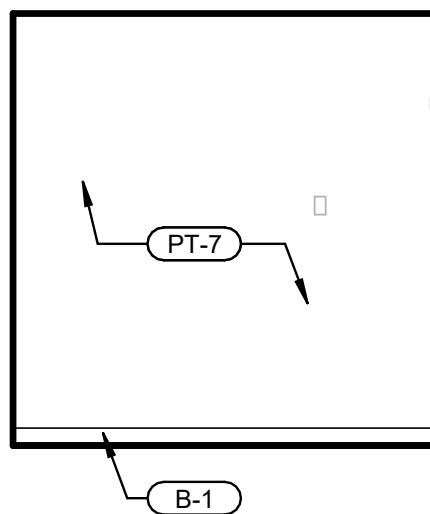


2 CORRIDOR
SCALE: 1/4" = 1'-0"

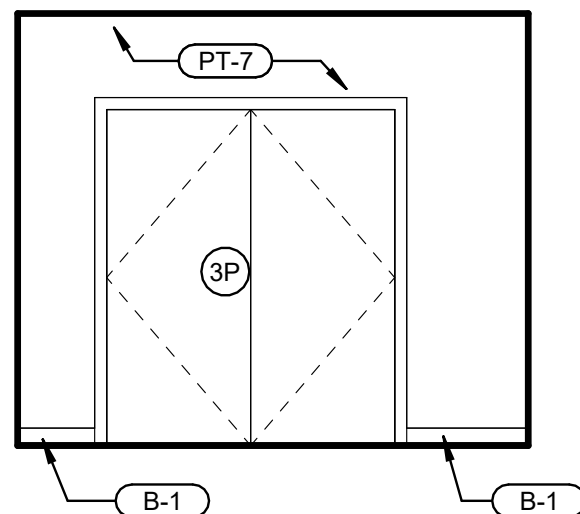


3 CORRIDOR
SCALE: 1/4" = 1'-0"

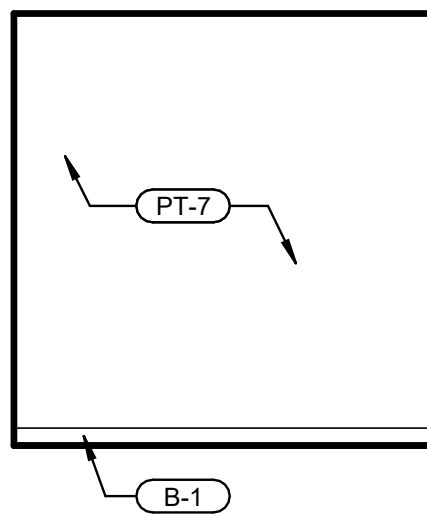


4 CORRIDOR
SCALE: 1/4" = 1'-0"

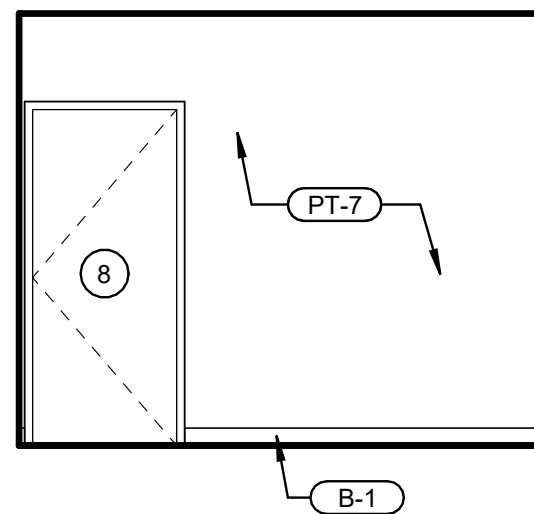


5 STORAGE
SCALE: 1/4" = 1'-0"

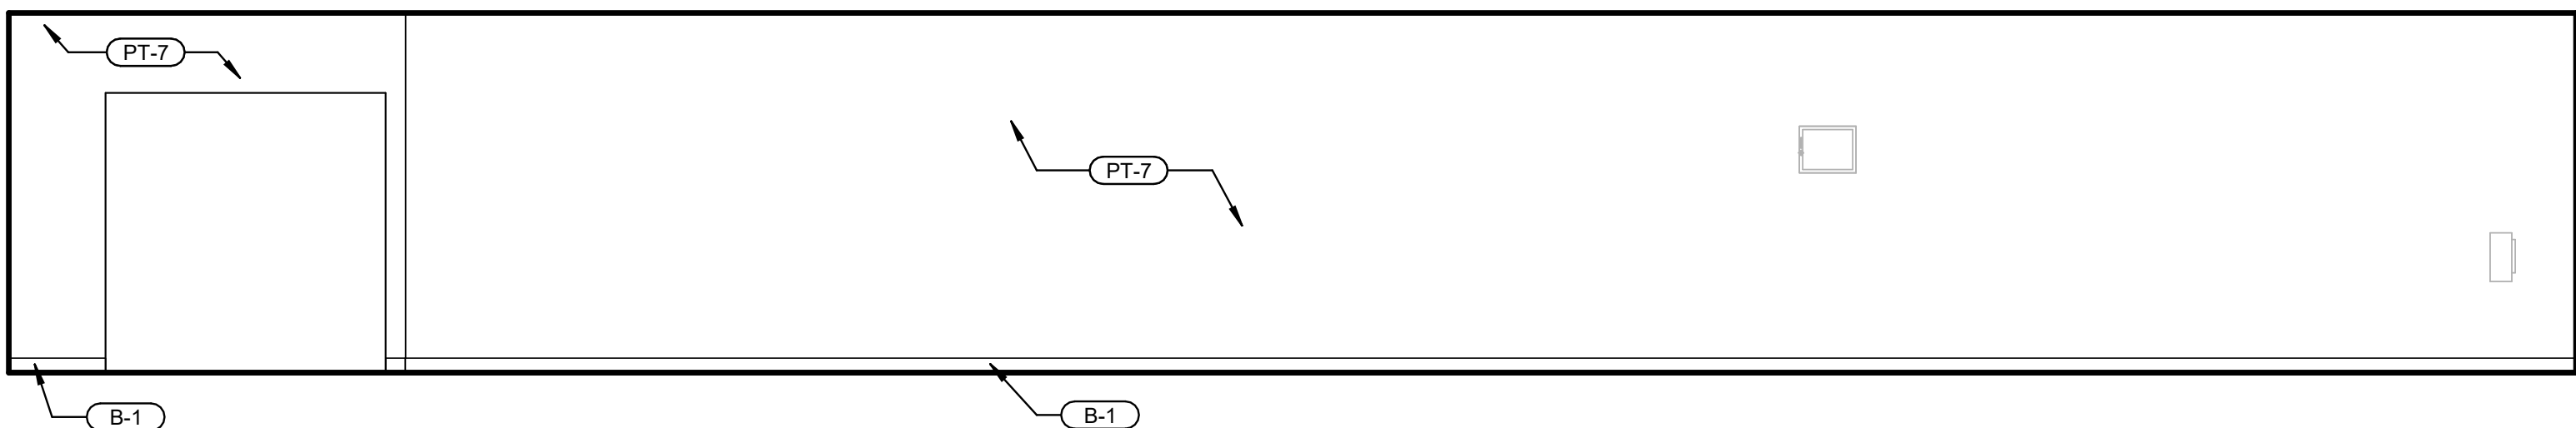


6 STORAGE
SCALE: 1/4" = 1'-0"

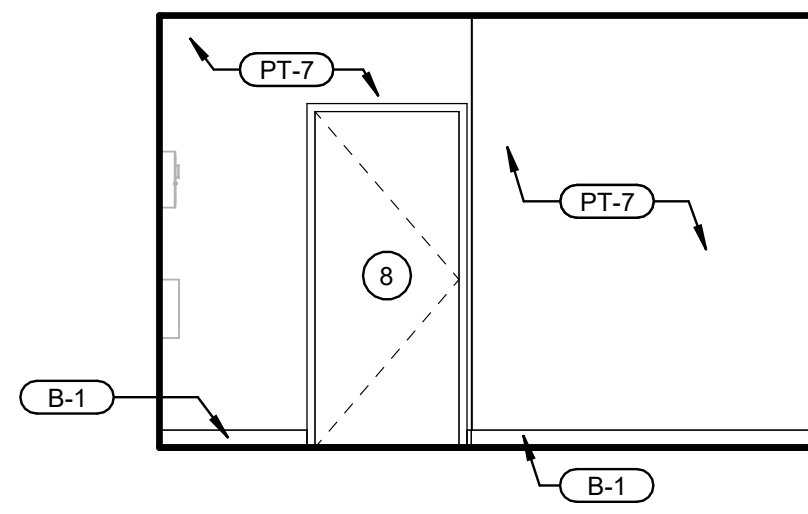


7 STORAGE
SCALE: 1/4" = 1'-0"

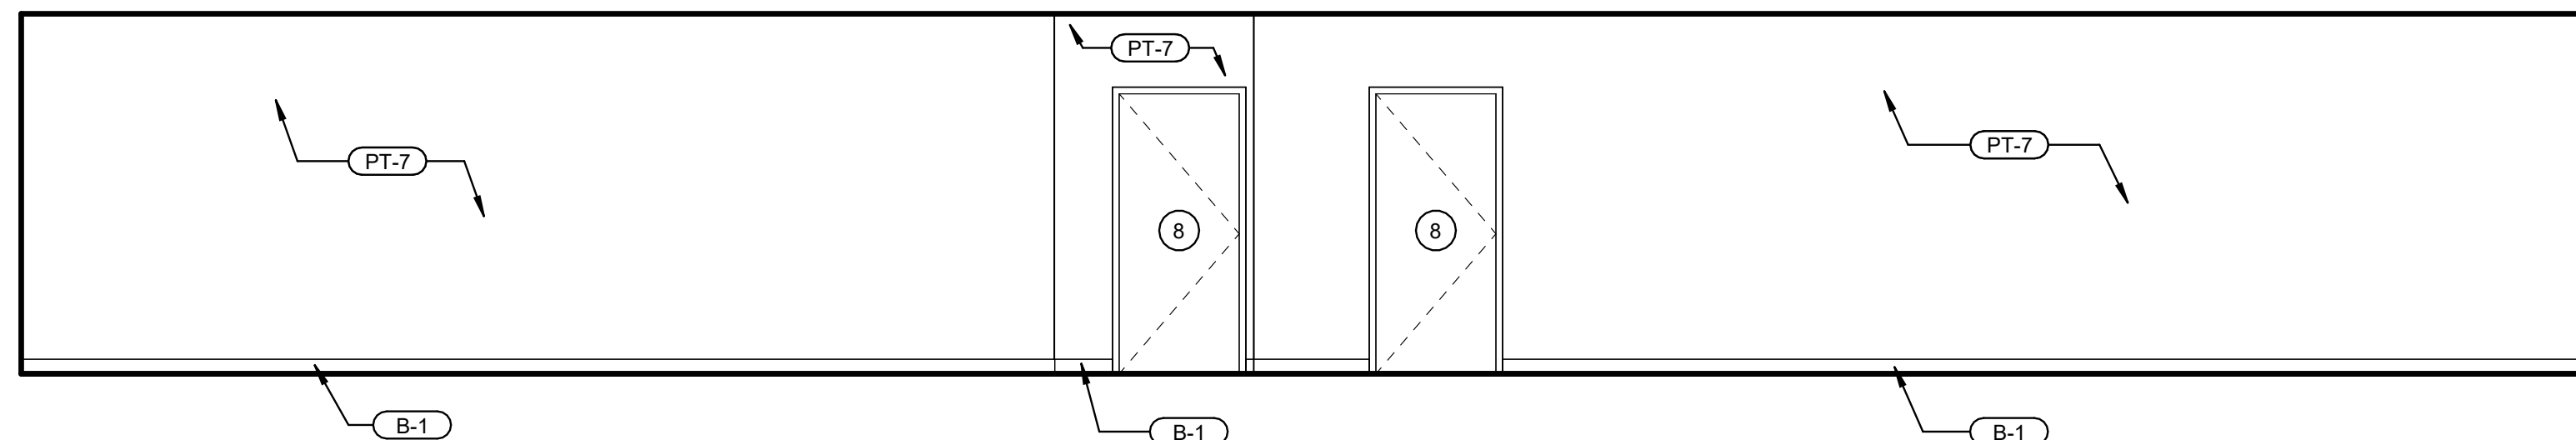


8 STORAGE
SCALE: 1/4" = 1'-0"

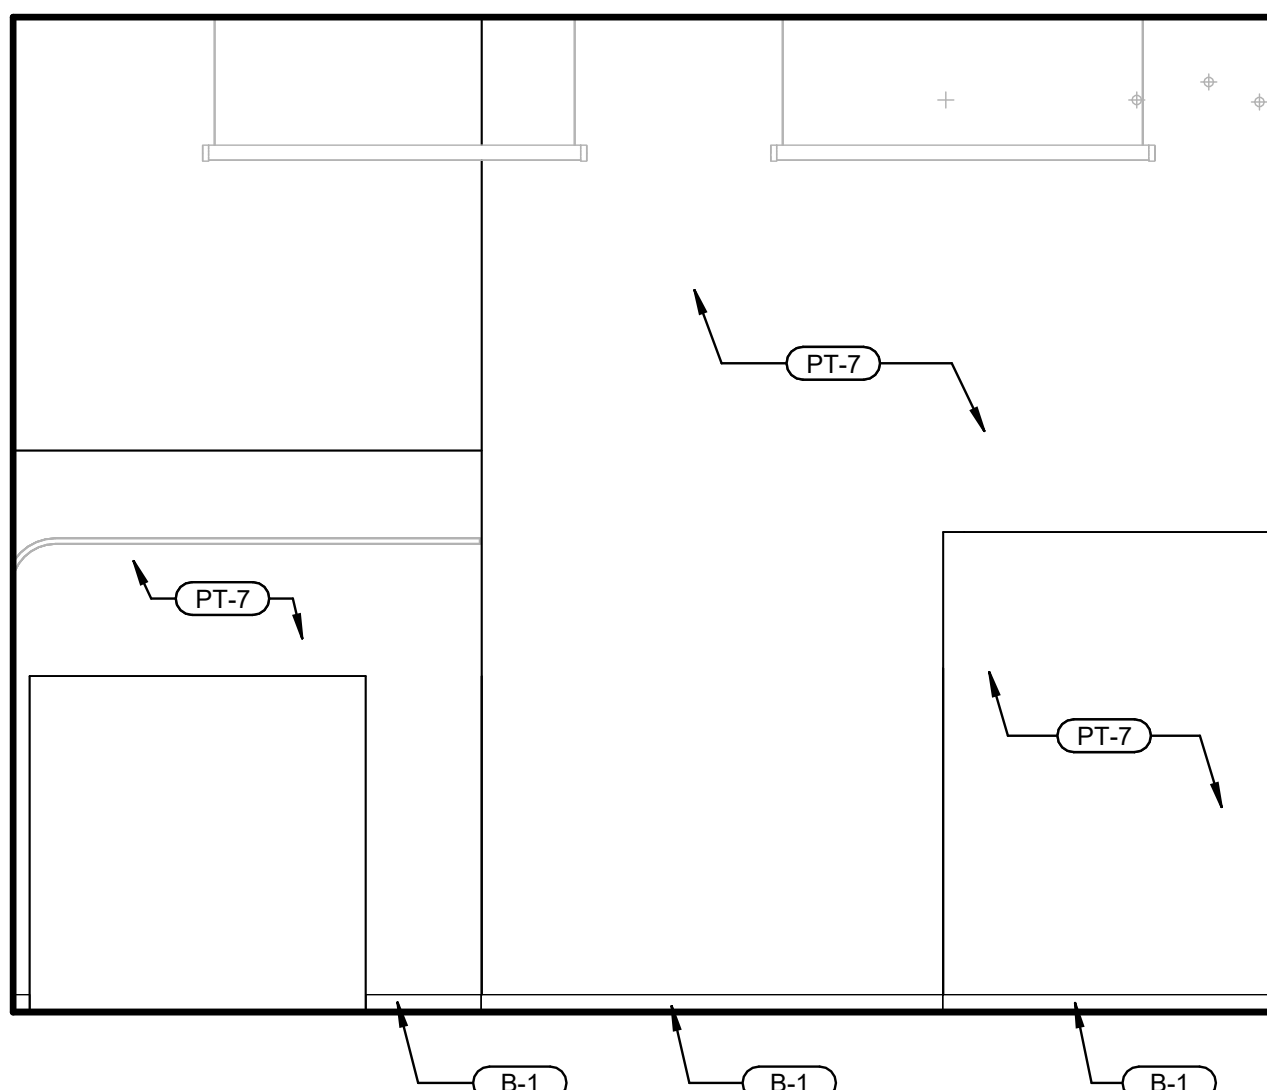


9 STORAGE
SCALE: 1/4" = 1'-0"

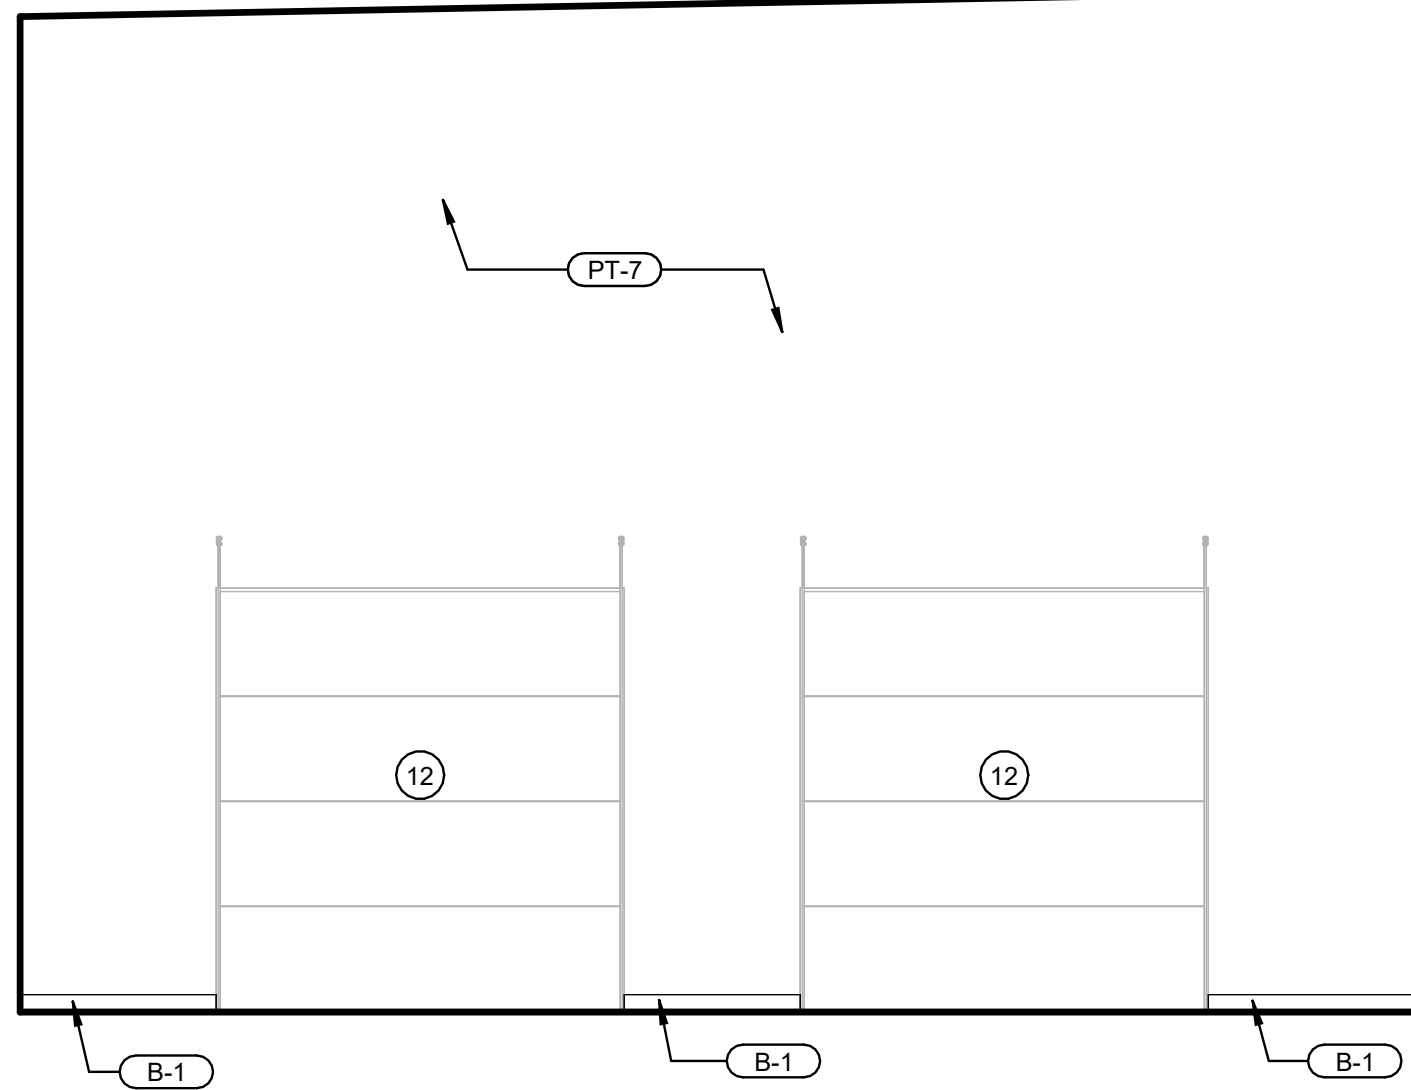

10 STORAGE
SCALE: 1/4" = 1'-0"

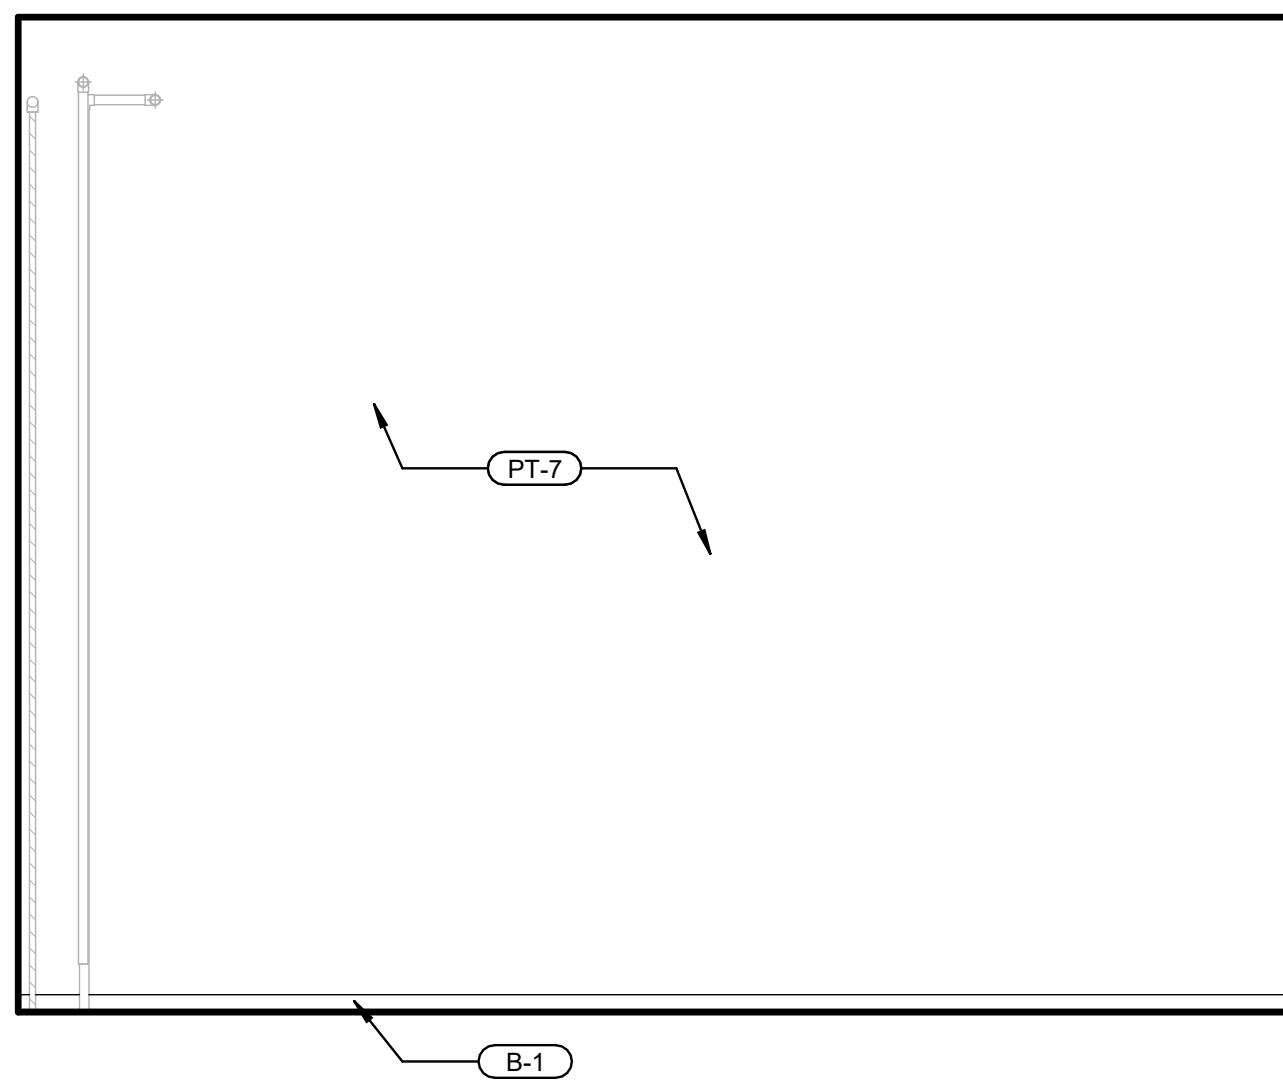

11 STORAGE
SCALE: 1/4" = 1'-0"

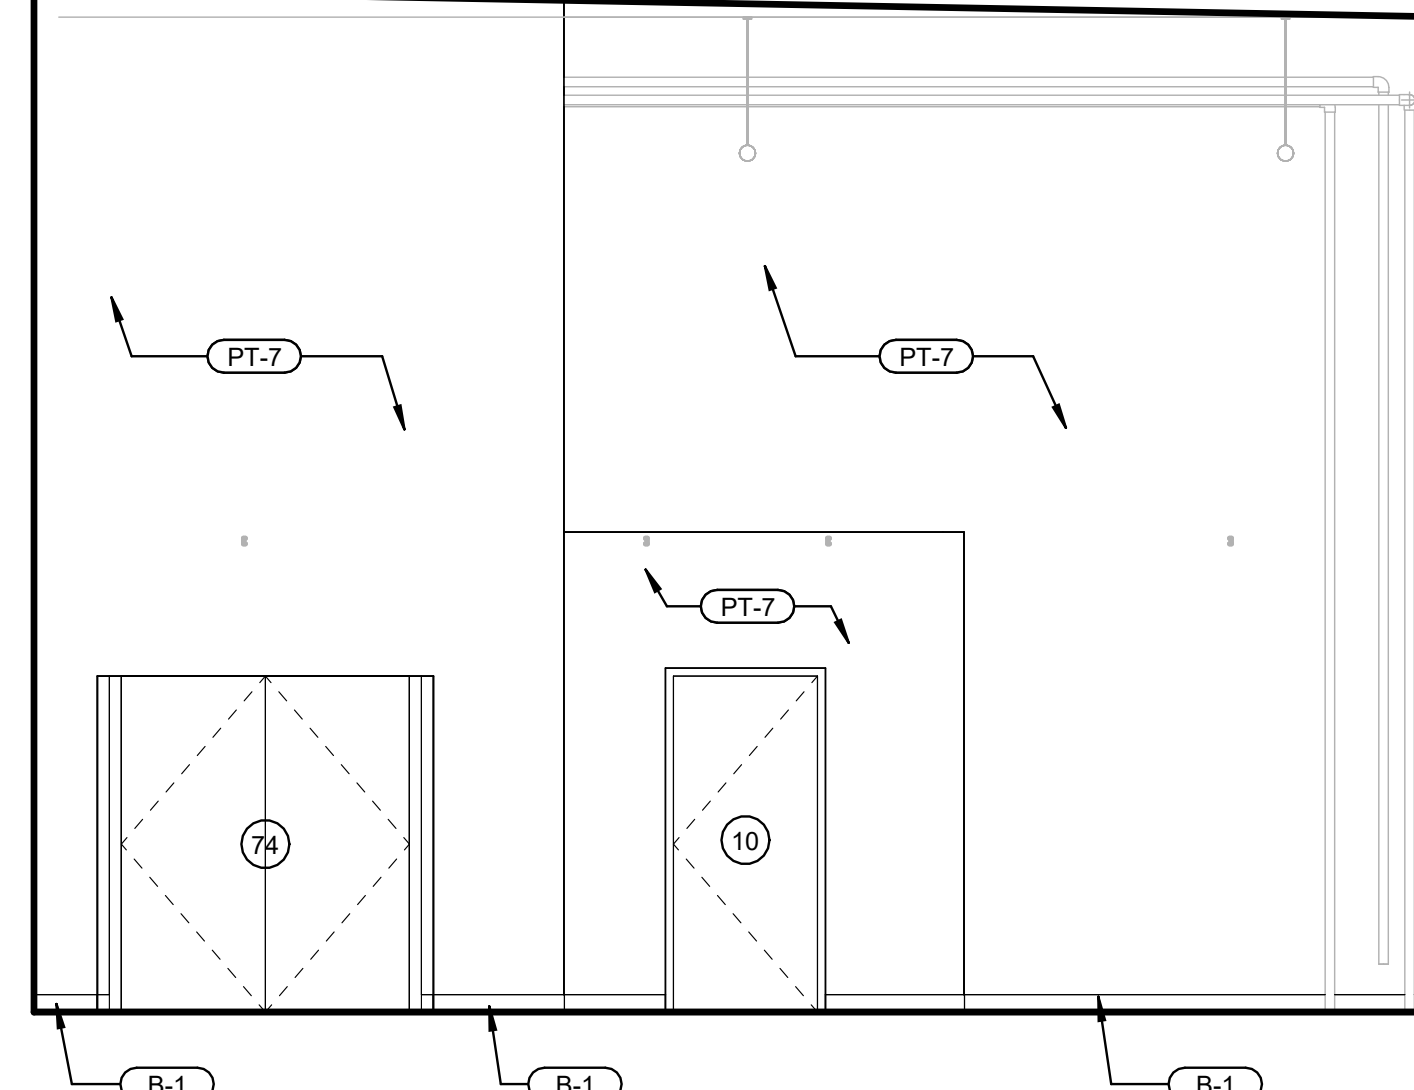

12 STORAGE
SCALE: 1/4" = 1'-0"