




ANS, MAPS, SPECIFICATIONS,
UDIES AND REPORTS NOT
CONTAINING A SEAL IMPRINT
ACCOMPANIED BY AN ORIGINAL
SIGNATURE BY THE LICENSED
PROFESSIONAL MAY HAVE BEEN
FRAUDULENTLY ALTERED AND
SHALL NOT BE CONSIDERED AN
ORIGINAL COPY. ALL
INFORMATION SHOULD BE
REGARDED UNLESS VERIFIED
BY THE PROFESSIONAL WHOSE
SIGNATURE APPEARS BELOW.
COPYRIGHT PROTECTED
2025

[illegible]

REVISION RECORD		
NO	DATE	REVISION

PROFESSIONAL SEAL

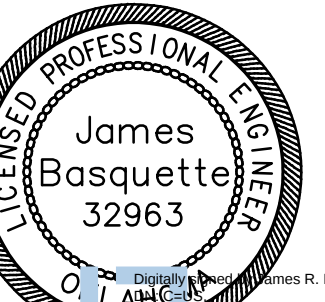

es R. Basque



MODEL

PROJECT NAME

SLICK CITY

ORMAN, OK

PROJECT NUMBER

ORMAN, OK

SHEET TITLE
ELECTRICAL POWER
AND DATA PLAN

SHEET NUMBER


E100

GENERAL CONTRACTOR NOTE

ELECTRICAL CONTRACTOR IS RESPONSIBLE FOR SUPPLYING CONDUIT, EMT CONDUIT, J-BOXES, PULLSTRINGS, RECEPTACLES ETC. FOR ALL LOW-VOLTAGE AND SECURITY DEVICES SHOWN IN THE LOW-VOLTAGE PLANS. DEVICES INCLUDES: P.O.S. LOCATIONS, CAMERAS, CAMERA MONITORS, ETC. REFER TO SHEETS LVL-1, LV-5

- A. VERIFY LOCATION OF ALL EQUIPMENT WITH ARCHITECT AND OTHER TRADES.
- B. ELECTRICAL CONTRACTOR IS RESPONSIBLE FOR FIELD VERIFICATION OF ALL CONDITIONS AND IS ALSO RESPONSIBLE FOR REPORTING ANY CONFLICTS TO THE ENGINEER PRIOR TO THE START OF WORK.
- C. COORDINATE OUTLET ORIENTATION WITH EQUIPMENT PLUGS SO THAT ALL 90 DEGREE PLUGS WILL HANG CORN DOWN.
- D. ALL 120V, 20A RECEPTACLES WITHIN 6 FEET FROM THE OUTSIDE EDGE OF ALL WET SINKS SHALL BE GFCI-PROTECTED.
- E. ALL RECEPTACLES WITHIN THE KITCHEN AREA SHALL BE GFCI TYPE. PROVIDE A GFCI CIRCUIT BREAKER IF RECEPTACLE IS NOT READILY ACCESSIBLE. SEE PANEL SCHEDULES FOR MORE DETAILS.
- F. CONTRACTOR SHALL VERIFY RECEPTACLE NEMA CONFIGURATION FOR EQUIPMENT WITH EQUIPMENT SUPPLIER PRIOR TO INSTALLATION. NOTIFY ARCH. & ENGINEER OF ANY CONFLICT OR DISCREPANCY.
- G. CONTRACTOR SHALL COORDINATE THE EXACT POWER, WIRING & FINAL CONNECTION REQUIREMENTS FOR ALL EQUIPMENT BEFORE ROUGH-IN WITH RESPECTIVE EQUIPMENT PROVIDER AND MAKE ALL REQUIRED FINAL CONNECTIONS.
- H. COORDINATE MOUNTING OF THE RECEPTACLE FOR THE CLOCKS AND TV WITH ARCHITECTURE PLANS PRIOR TO ROUGH-IN.

1. PROVIDE POWER FOR HAND DRYER. INSTALL PER MANUFACTURER REQUIREMENTS AND INSTALLATION GUIDELINES. COORDINATE LOCATION WITH ARCHITECTURE PLANS PRIOR TO POUR.
2. PROVIDE POWER FOR ELECTRICAL BLOWER. INSTALL PER MANUFACTURER REQUIREMENTS AND INSTALLATION GUIDELINES. COORDINATE LOCATION WITH ARCHITECTURE PLANS PRIOR TO POUR-IN.
3. MONITOR SUSPENDED FROM STEEL JOIST ABOVE.
4. RECEPTACLES TO BE ADDED AT +60.0C.
5. CONTRACTOR SHALL PROVIDE ACTION AREA LIGHT CONTROLS AT THIS LOCATION. ALL LIGHTS SHALL BE DIMMABLE DOWN TO 10%. CONTRACTOR SHALL COORDINATE EXACT CONTROL SETTINGS, BUTTON REQUIREMENT FOR PRESETS, ENGRAVING PRIOR TO SUBMITTING EQUIPMENT FOR APPROVAL. COORDINATE WITH OWNER AND ARCHITECT FOR EXACT COLOR AND OTHER REQUIREMENTS.
6. LOOKERS +90". RUN POWER AND DATA FROM ADJACENT COLUMN.
7. EXISTING PLANS TO BE REMOVED.

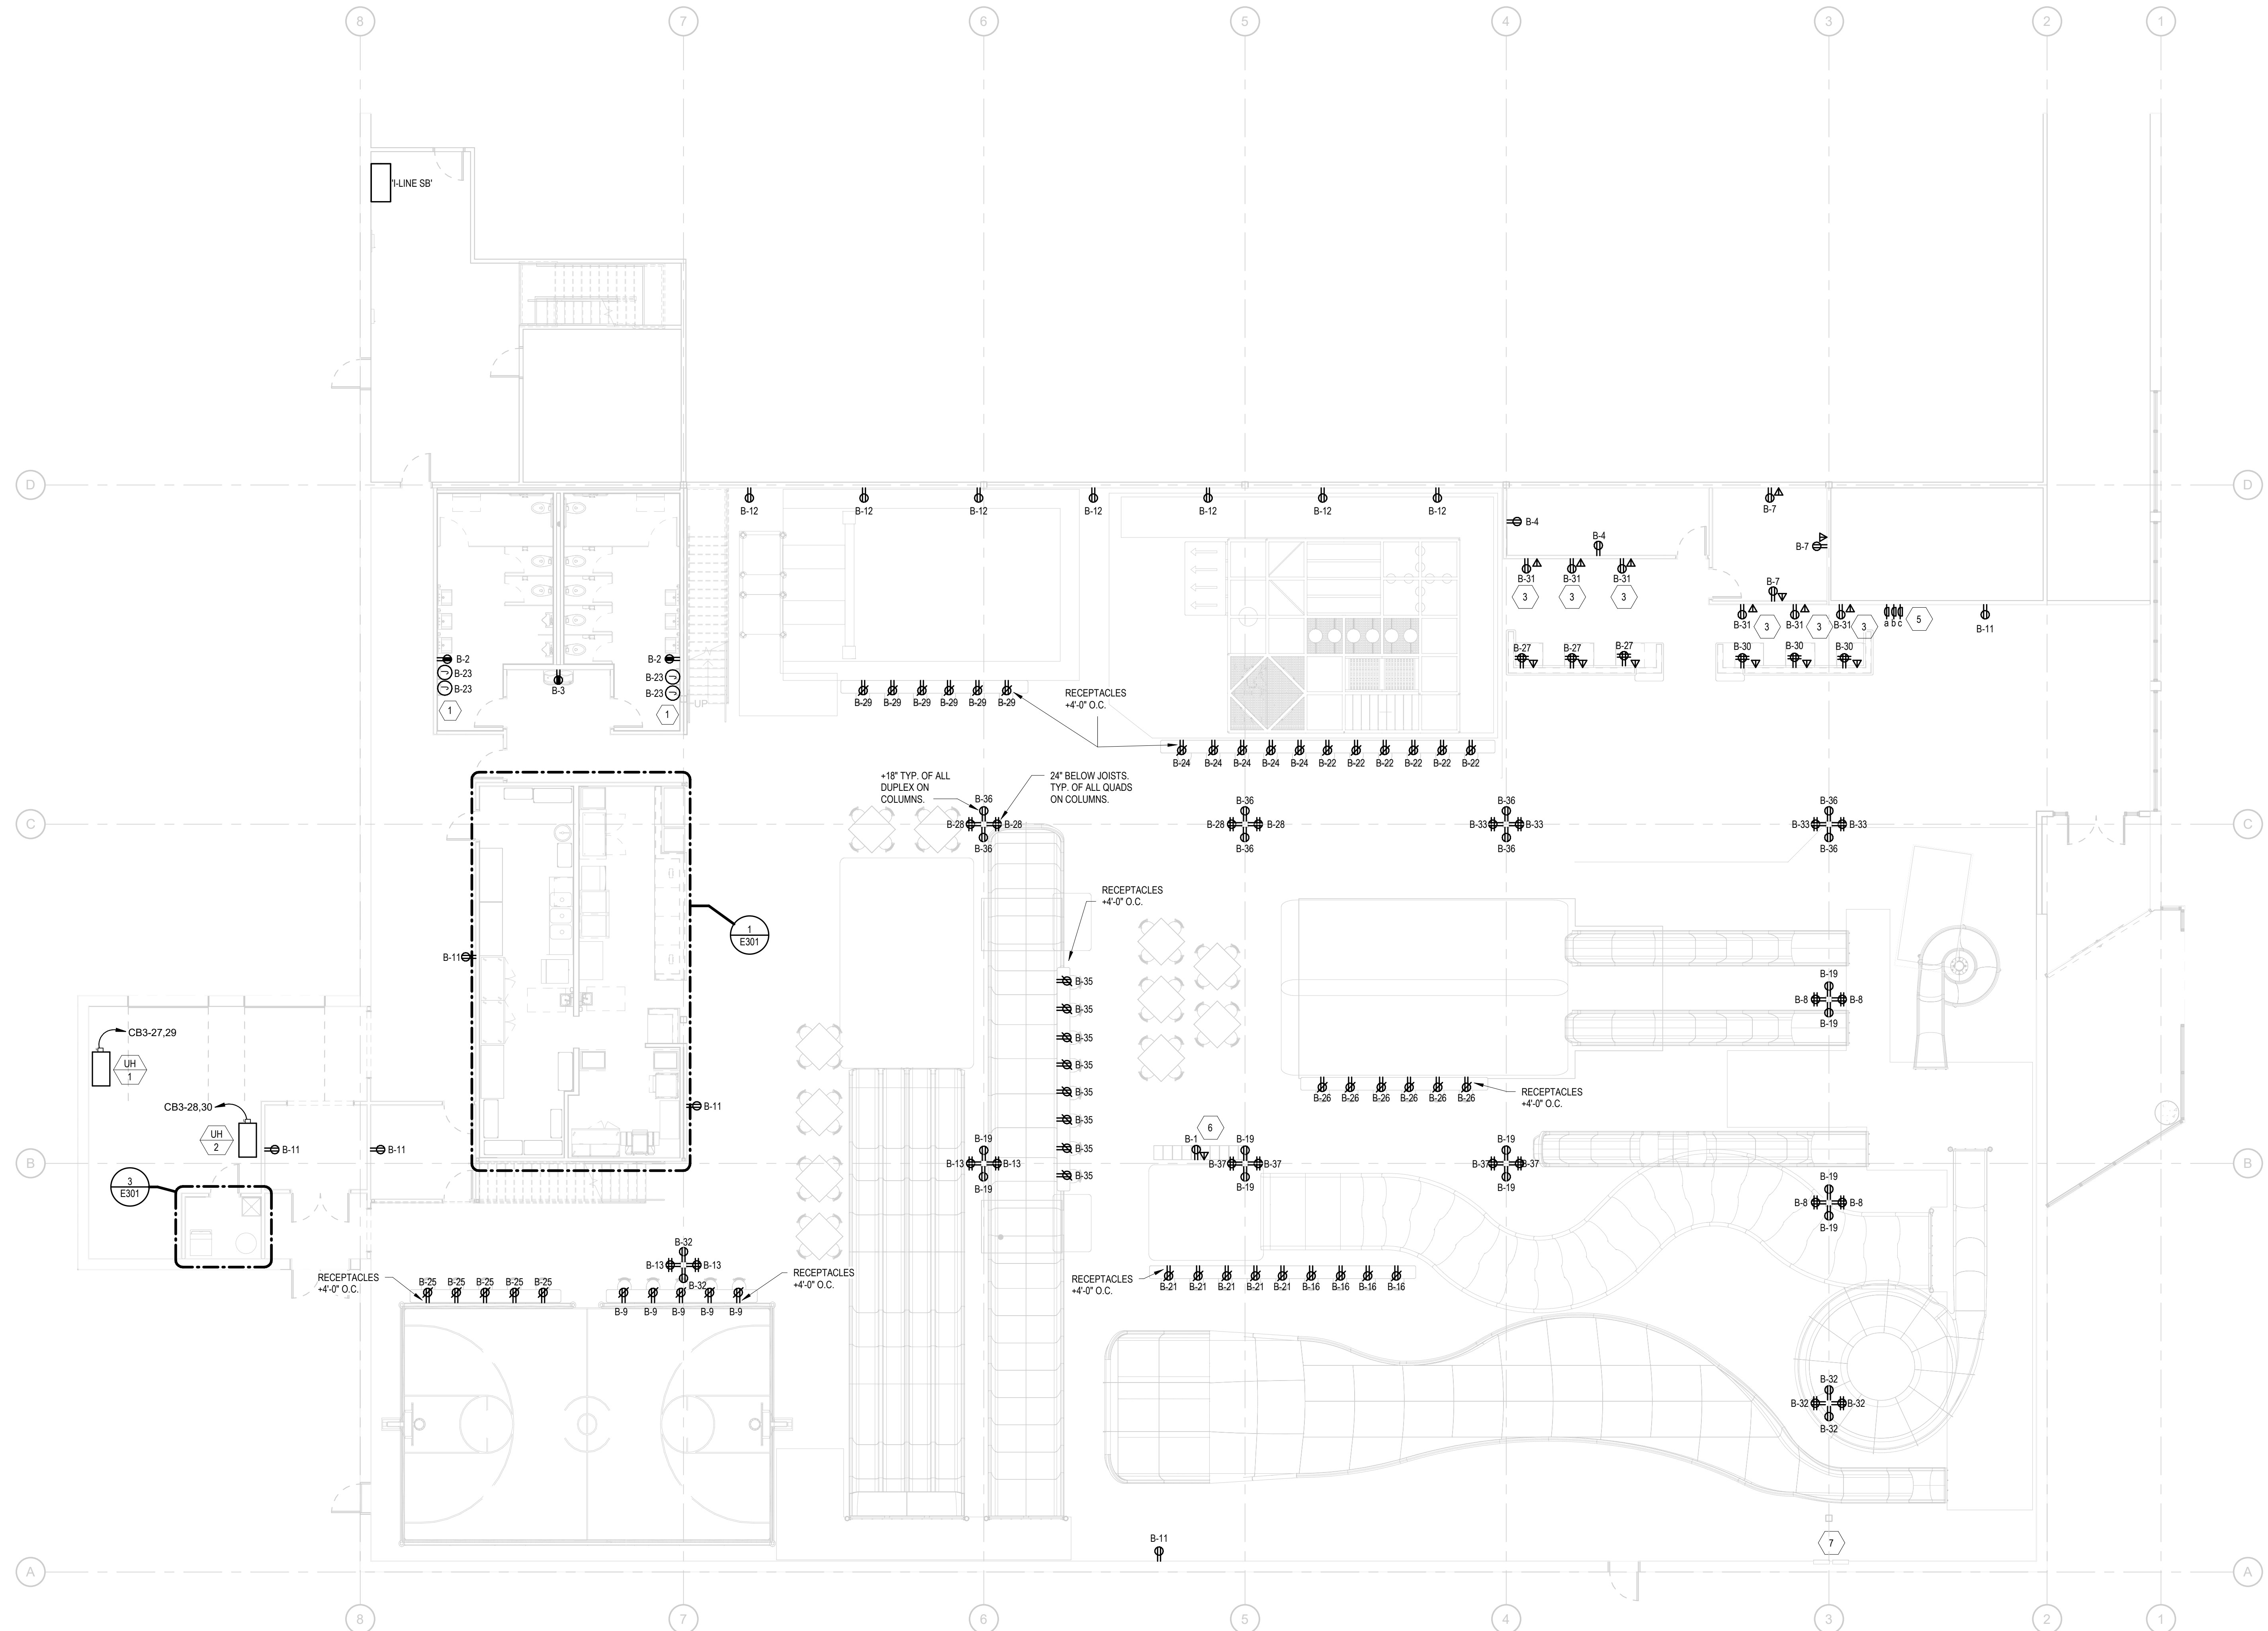

1 ELECTRICAL POWER AND DATA PLAN

E100 $1/8'' = 1'-0''$