


GENERAL NOTES

- A. VERIFY LOCATION OF ALL EQUIPMENT WITH ARCHITECT AND OTHER TRADES.
- B. ELECTRICAL CONTRACTOR IS RESPONSIBLE FOR FIELD VERIFICATION OF ALL CONDITIONS AND IS ALSO RESPONSIBLE FOR REPORTING ANY CONFLICTS TO THE ENGINEER PRIOR TO THE START OF WORK.
- C. COORDINATE OUTLET ORIENTATION WITH EQUIPMENT PLUGS SO THAT ALL 90 DEGREE PLUGS WILL HANG CORD DOWN.
- D. ALL 120V, 20A RECEPTACLES WITHIN 6 FEET FROM THE OUTSIDE EDGE OF ALL WET SINKS SHALL BE GFCI-PROTECTED.
- E. ALL RECEPTACLES WITHIN THE KITCHEN AREA SHALL BE GFCI TYPE. PROVIDE A GFCI CIRCUIT BREAKER IF RECEPTACLE IS NOT READILY ACCESSIBLE. SEE PANEL SCHEDULES FOR MORE DETAILS.
- F. CONTRACTOR SHALL VERIFY RECEPTACLE NEMA CONFIGURATION FOR EQUIPMENT WITH EQUIPMENT SUPPLIER PRIOR TO INSTALLATION. NOTIFY ARCH. & ENGINEER OF ANY CONFLICT OR DISCREPANCY.
- G. CONTRACTOR SHALL COORDINATE THE EXACT POWER, WIRING & FINAL CONNECTION REQUIREMENTS FOR ALL EQUIPMENT BEFORE ROUGH-IN WITH RESPECTIVE EQUIPMENT PROVIDER AND MAKE ALL REQUIRED FINAL CONNECTIONS.
- H. FIXTURES NOTED WITH THE IDENTIFIER 'E' ARE EMERGENCY AND SHALL BE PROVIDED WITH 90 MINUTE EMERGENCY BALLAST.
- I. REFER TO 'E300' FOR FIXTURE SCHEDULE.
- J. COORDINATE LIGHT SWITCHES, DIMMERS AND CONTROLS WITH OWNER PRIOR TO ORDERING. SWITCHES TO BE CONFIGURED AS PREFERRED BY OWNER.
- K. HIGH BAY OCCUPANCY SENSORS REQUIRED OVER PLAY AREA.
- L. EXISTING STAIRWELL LIGHTING TO REMAIN.

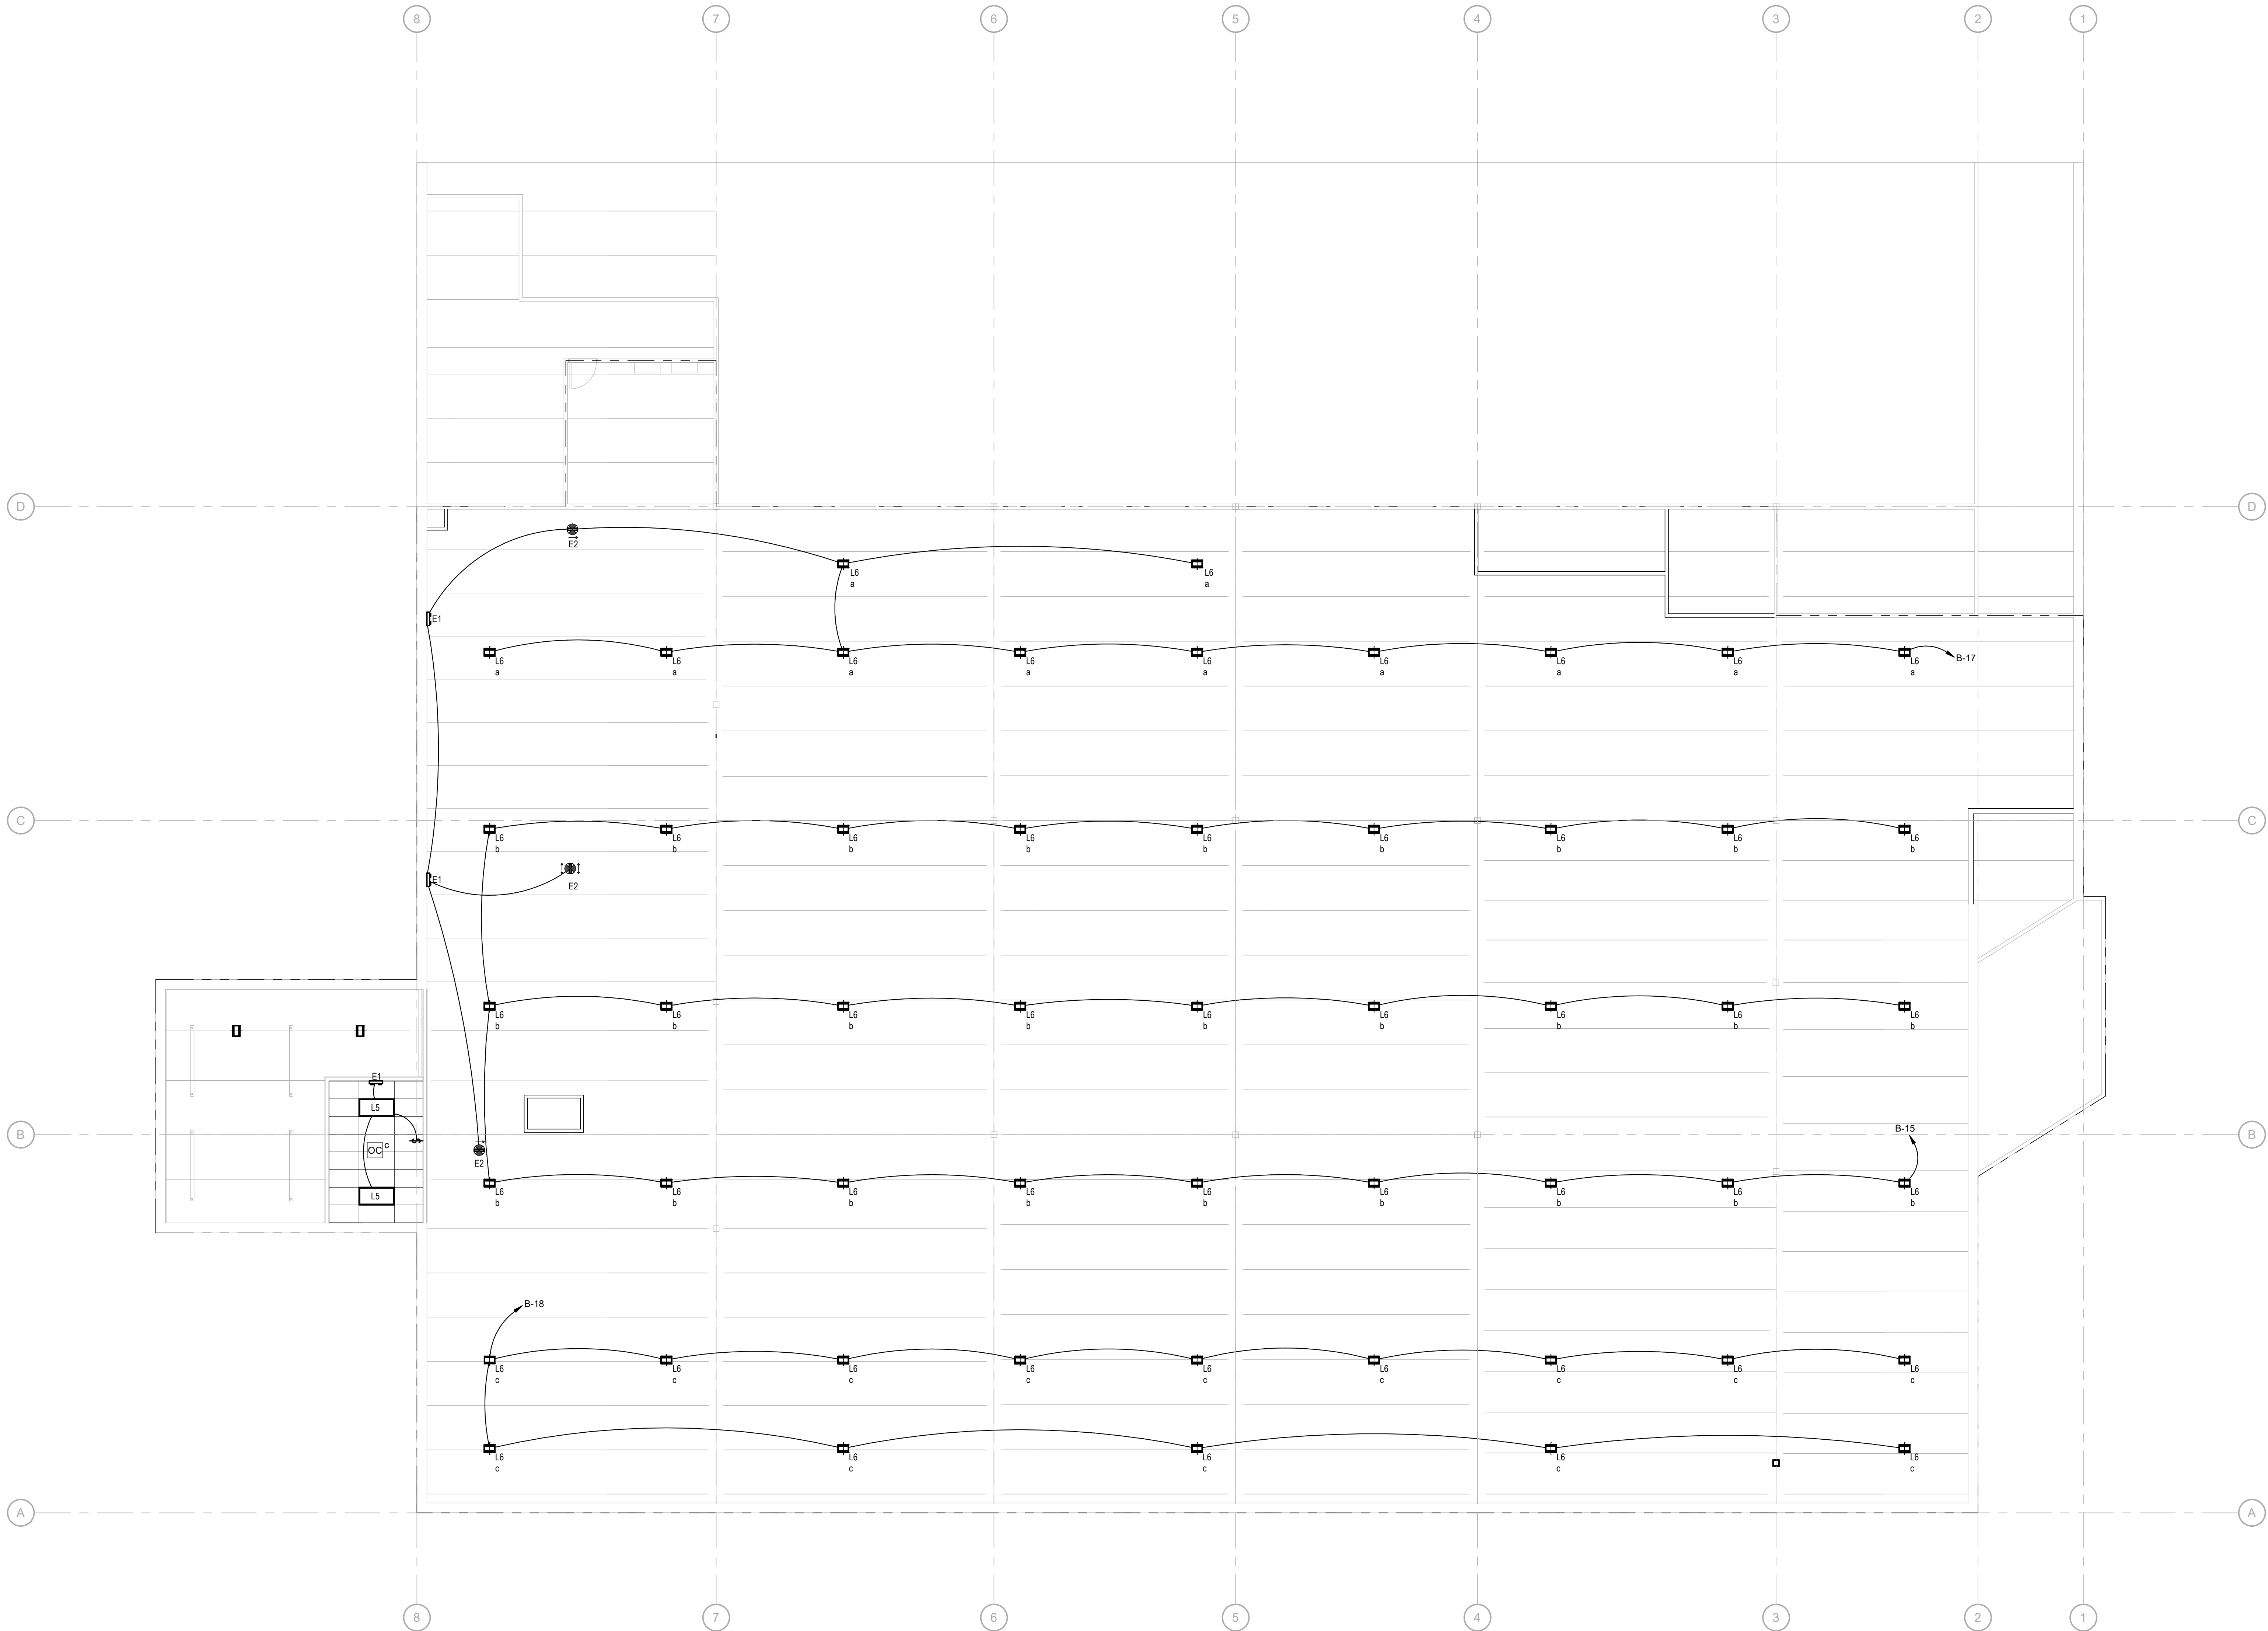

1 ELECTRICAL MEZZANNINE LIGHTING PLAN
E201 1/8" = 1'-0"

16775 ADDISON ROAD, SUITE 500
ADDISON, TX 75001
PH: (469) 960-2322

PLANS, MAPS, SPECIFICATIONS, STUDIES AND REPORTS NOT CONTAINING A SEAL IMPRINT ACCOMPANIED BY AN ORIGINAL SIGNATURE BY THE LICENSED PROFESSIONAL MAY HAVE BEEN FRAUDULENTLY ALTERED AND SHALL NOT BE CONSIDERED AN ORIGINAL COPY. ALL INFORMATION SHOULD BE DISREGARDED UNLESS VERIFIED BY THE PROFESSIONAL WHOSE SIGNATURE APPEARS BELOW. COPYRIGHT PROTECTED © 2025

ISSUE RECORD
DESCRIPTION DATE
ISSUE FOR PERMIT 06/22/2026

REVISION RECORD
NO DATE REVISION

PROFESSIONAL SEAL

James R. Basquette
James R. Basquette@rtimec.com
Chief Electrical Engineer
Date: 06/25/2025 11:17:21 -0500

rtm
engineering consultants
14901 Quorum Dr., #505
Dallas, Texas 75254
rtimec.com | 972.387.3500

REMODEL

PROJECT NAME
SLICK CITY

NORMAN, OK

PROJECT NUMBER
NORMAN, OK

SHEET TITLE
ELECTRICAL LIGHTING
PLAN - MEZZANINE

SHEET NUMBER
E201