


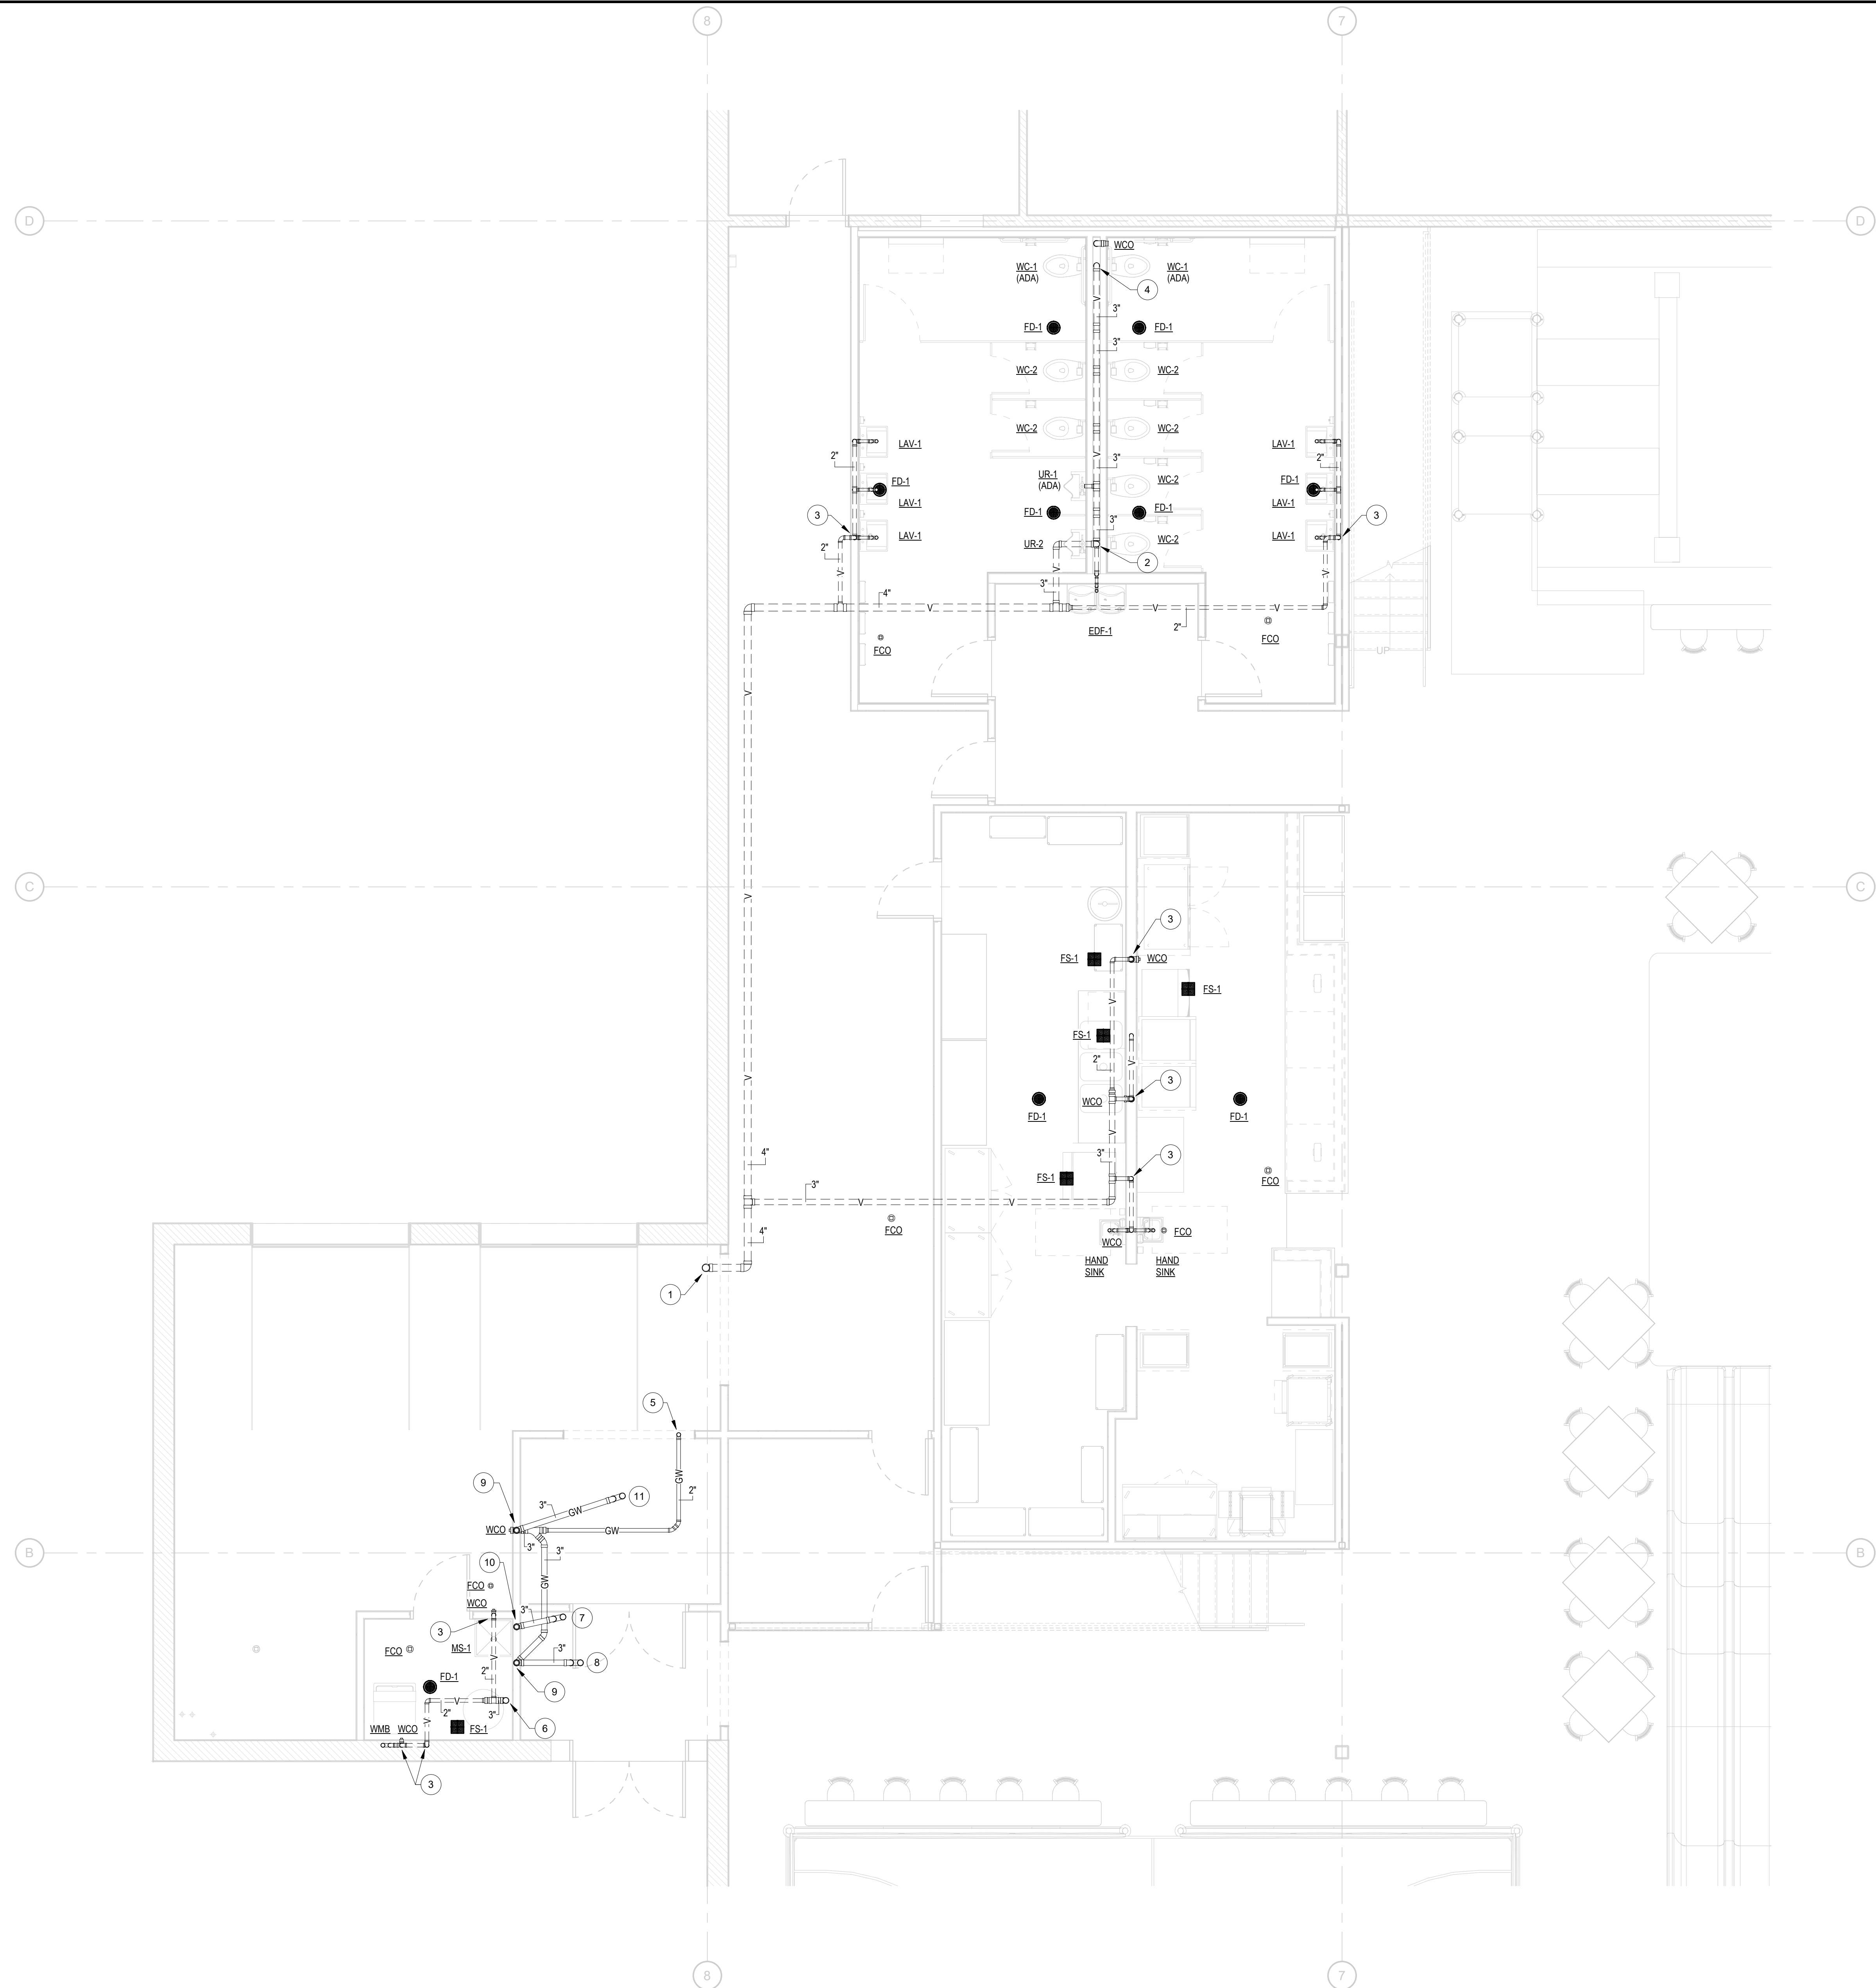

NOTES BY SYMBOL - SHEET P101A	
NUMBER	DESCRIPTION
1	4" VENT UP THROUGH ROOF.
2	3" VENT DOWN TO RESTROOM ASSEMBLY.
3	2" VENT DOWN TO PLUMBING FIXTURE.
4	3" VENT DOWN TO 4" TOILET RISER.
5	2" GREASE WASTE FROM HAND WASHING SINK AT MEZZANINE ABOVE.
6	3" VENT UP TO MEZZANINE.
7	3" SANITARY WASTE P-TRAP FOR MEZZANINE FLOOR SINK SERVING ICE MAKER.
8	3" GREASE WASTE P-TRAP FOR MEZZANINE FLOOR SINK SERVING SODA MACHINE.
9	3" GREASE WASTE DOWN TO UNDERFLOOR.
10	3" SANITARY WASTE DOWN TO UNDERFLOOR.
11	3" GREASE WASTE P-TRAP FOR FLOOR DRAIN SERVING MEZZANINE.

1 PLUMBING FLOOR PLAN - AREA A
P101A 1/4" = 1'-0"

16775 ADDISON ROAD, SUITE 500
ADDISON, TX 75001
PH: (469) 960-2322

PLANS, MAPS, SPECIFICATIONS, STUDIES AND REPORTS NOT CONTAINING A SEAL IMPRINT ACCOMPANIED BY AN ORIGINAL SIGNATURE BY THE LICENSED PROFESSIONAL MAY HAVE BEEN FRAUDULENTLY ALTERED AND SHALL NOT BE CONSIDERED AN ORIGINAL COPY. ALL INFORMATION SHOULD BE DISREGARDED UNLESS VERIFIED BY THE PROFESSIONAL WHOSE SIGNATURE APPEARS BELOW. COPYRIGHT PROTECTED © 2025

ISSUE RECORD	
DESCRIPTION	DATE
ISSUE FOR PERMIT 06/22/2026	

REVISION RECORD		
NO	DATE	REVISION

PROFESSIONAL SEAL

rtm
engineering consultants
14901 Quorum Dr. #505
Dallas, Texas 75254
rtmcc.com | 972.387.3500

REMODEL

PROJECT NAME
SLICK CITY

NORMAN, OK

PROJECT NUMBER
NORMAN, OK

SHEET TITLE
PLUMBING FLOOR PLAN - AREA A

SHEET NUMBER
P101A