


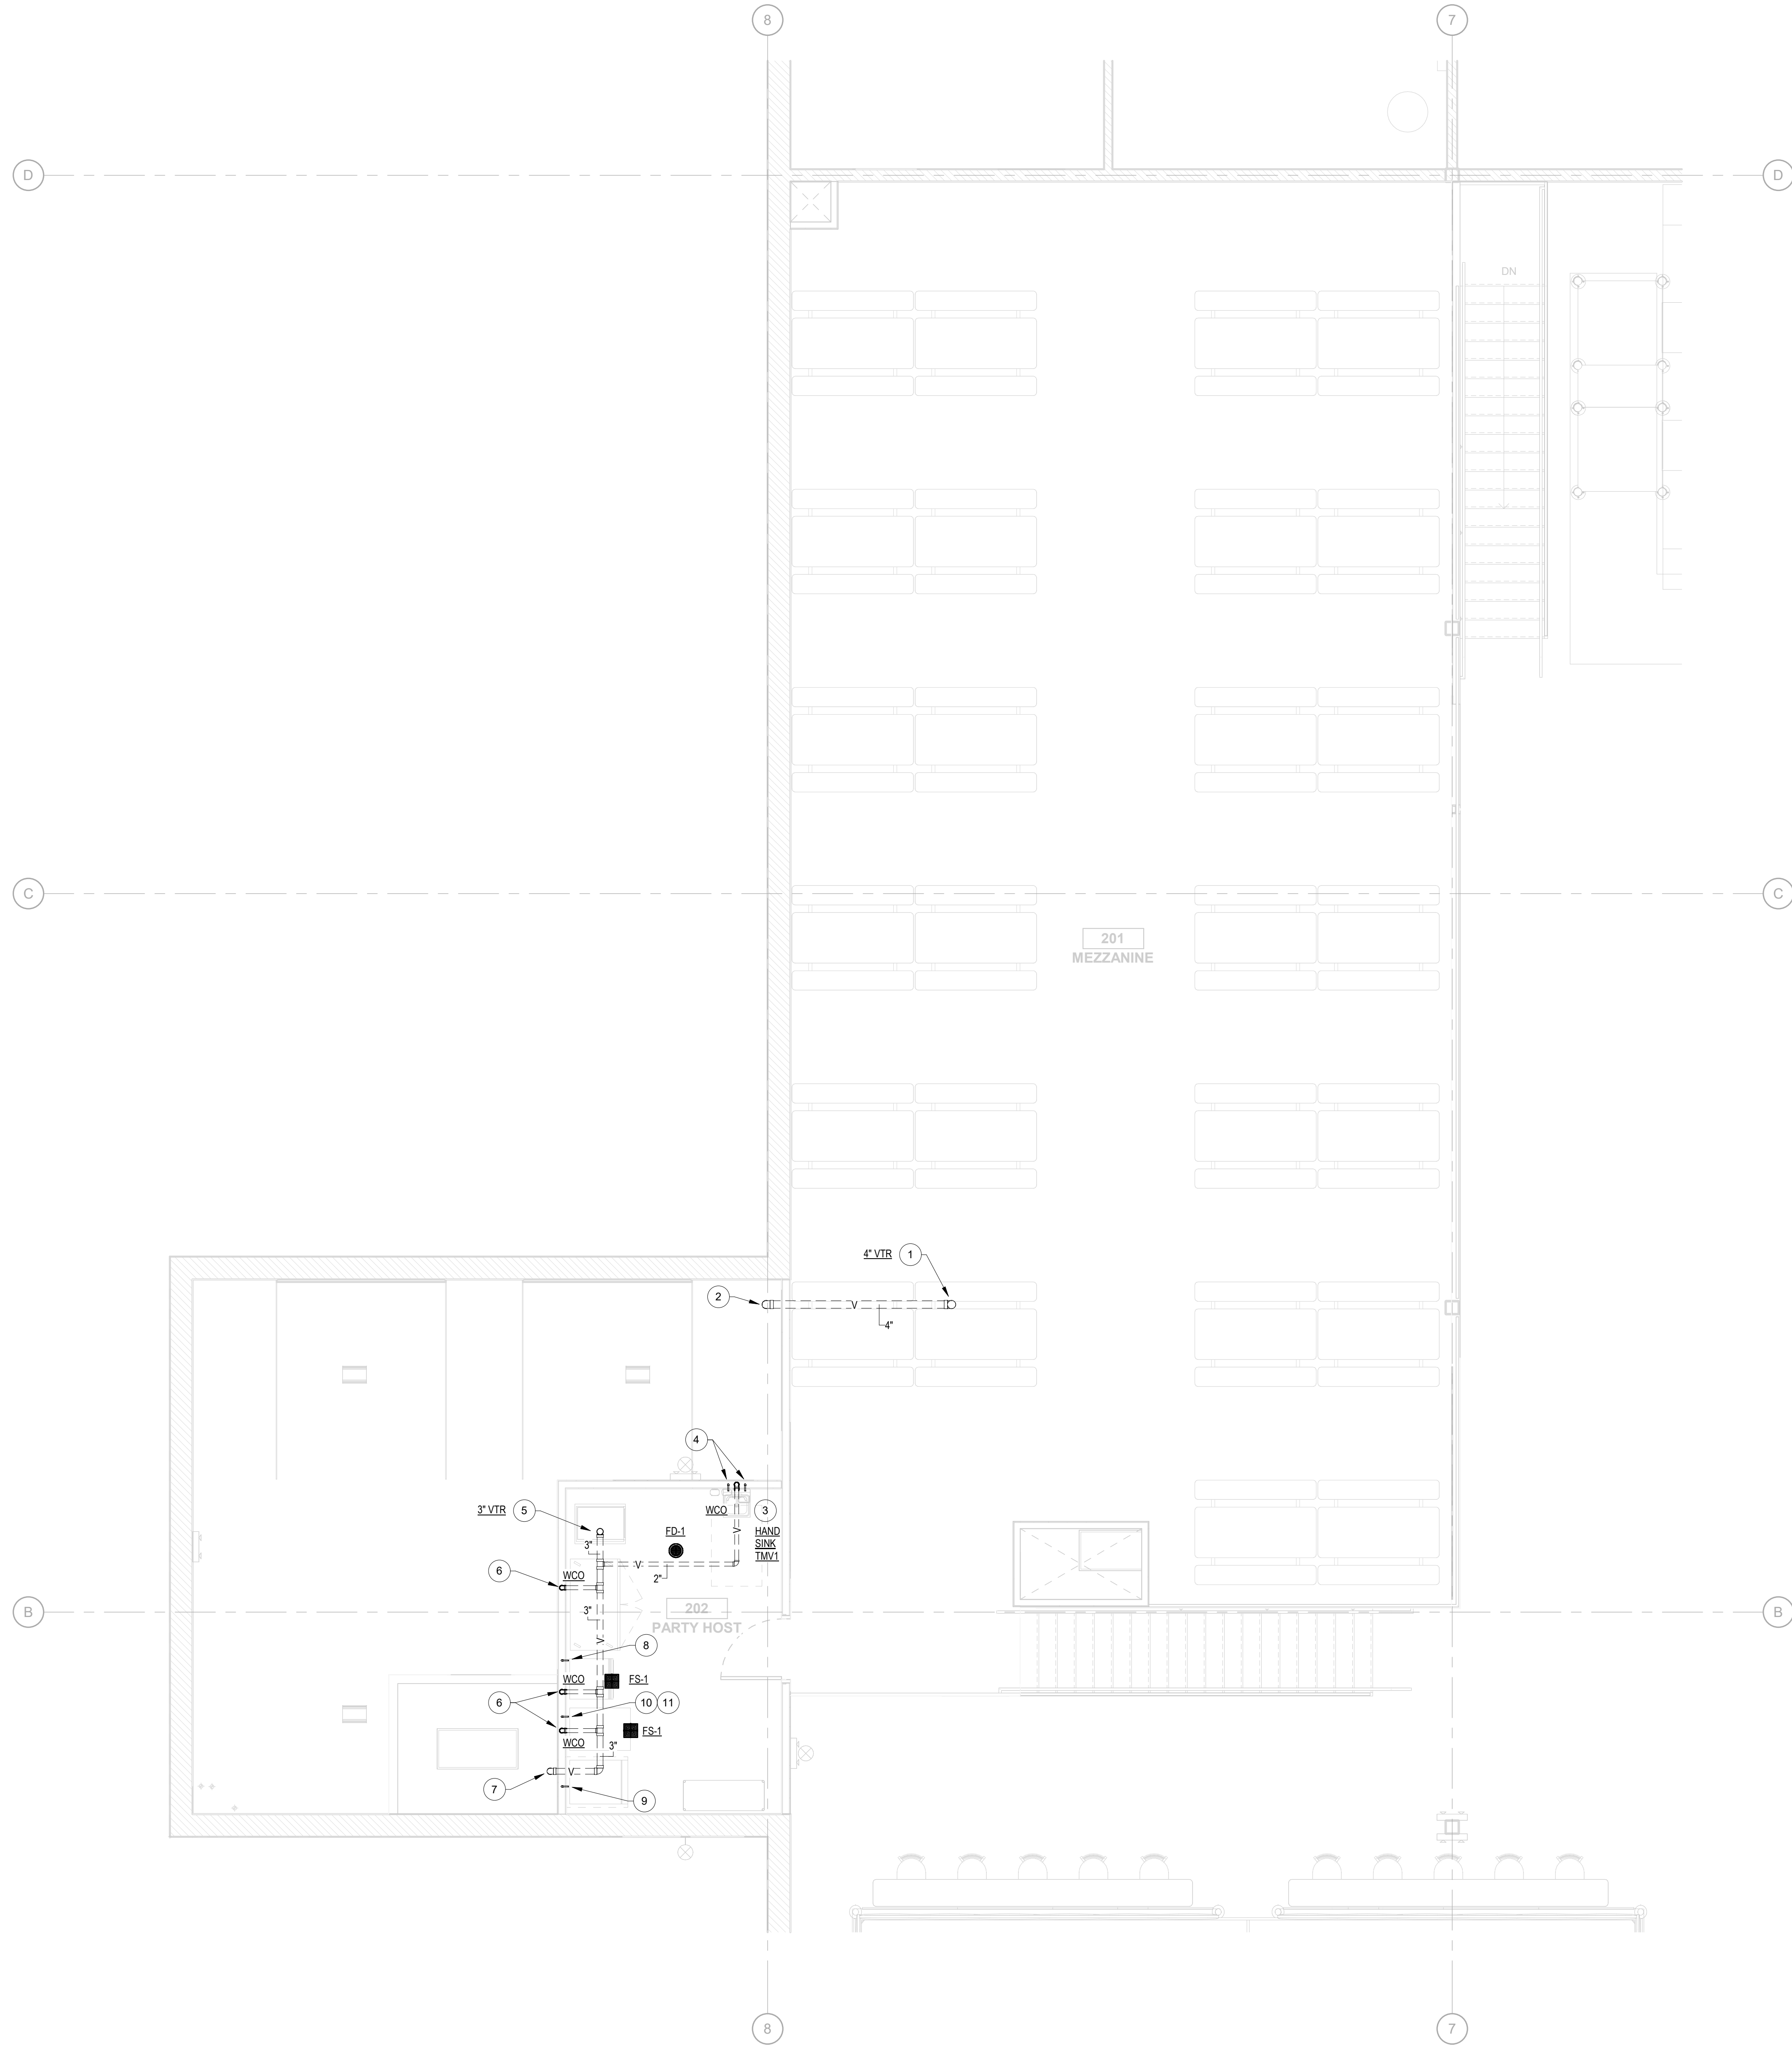

NOTES BY SYMBOL - SHEET P103	
NUMBER	DESCRIPTION
1	4" VENT UP THROUGH ROOF.
2	4" VENT FROM BELOW.
3	PROVIDE ASSE 1070 CERTIFIED THERMOSTATIC MIXING VALVE.
4	1/2" HW AND 1/2" CW FROM BELOW TO HAND WASHING SINK. PROVIDE WITH ASSE 1070 CERTIFIED THERMOSTATIC MIXING VALVE.
5	3" VENT UP THROUGH ROOF.
6	2" VENT DOWN TO PLUMBING FIXTURE.
7	3" VENT FROM BELOW.
8	1/2" CW TO ICE MAKER.
9	1/2" CW TO ICE FROZEN DRINK MACHINE. PROVIDE WITH WATTS' SD-3 LEAD FREE DUAL CHECK BACKFLOW PREVENTER, (ANSISF 18 AND ASSE 1022).
10	1/2" CW TO SODA DISPENSER. PROVIDE WITH WATTS' SD-3 LEAD FREE DUAL CHECK BACKFLOW PREVENTER, (ANSISF 18 AND ASSE 1022).
11	LINE SET TO BE EXTENDED FROM SYRUP RACK IN CAFE AREA TO SODA DISPENSER AT MEZZANINE.

16775 ADDISON ROAD, SUITE 500
ADDISON, TX 75001
PH: (469) 960-2322

PLANS, MAPS, SPECIFICATIONS, STUDIES AND REPORTS NOT CONTAINING A SEAL IMPRINT ACCOMPANIED BY AN ORIGINAL SIGNATURE BY THE LICENSED PROFESSIONAL MAY HAVE BEEN FRAUDULENTLY ALTERED AND SHALL NOT BE CONSIDERED AN ORIGINAL COPY. ALL INFORMATION SHOULD BE DISREGARDED UNLESS VERIFIED BY THE PROFESSIONAL WHOSE SIGNATURE APPEARS BELOW. COPYRIGHT PROTECTED © 2025

ISSUE RECORD
DESCRIPTION DATE
ISSUE FOR PERMIT 06/22/2026

REVISION RECORD		
NO	DATE	REVISION

PROFESSIONAL SEAL

rtm
engineering consultants
14901 Quorum Dr. #505
Dallas, Texas 75254
rtmcc.com | 972.387.3500

REMODEL

PROJECT NAME
SLICK CITY

NORMAN, OK

PROJECT NUMBER
NORMAN, OK

SHEET TITLE
PLUMBING MEZZANINE PLAN

SHEET NUMBER
P103

1 PLUMBING MEZZANINE PLAN
P103 1/4" = 1'-0"