

SITE GENERAL NOTES

1. THE PURPOSE OF THIS SHEET IS TO REFERENCE THE EXISTING ELECTRICAL EQUIPMENT. REFER TO OTHER ELECTRICAL SHEETS FOR SCOPE OF WORK.

AGP

the Abila Griffin
Partnership L.L.C.

313 S. E. 5th Street
MOORE, OK. 73160
405.735.3477
AGP@theAGP.net
www.theAGP.net

CEDAR CREEK
CIVIL

KFC ENGINEERING
STRUCTURAL

SALAS O'BRIEN
MECHANICAL / ELECTRICAL



JM/JS
drawn by

TVO
checked by

APRIL 2026
date

REVISIONS		
Δ	DESCRIPTION	DATE



SOUTHGATE
ELEMENTARY
KITCHEN UPGRADES
and ADDITION

sheet no:


E001

OWNERSHIP USE OF DOCUMENTS:

AGP EXPRESSLY RESERVES ITS COPYRIGHT AND OTHER PROPERTY RIGHTS OF ALL PLANS AND DRAWINGS DESIGNED AND/OR PRODUCED. PLANS AND DRAWINGS ARE NOT TO BE REPRODUCED IN ANY FORM OR MANNER WITHOUT THE EXPRESSED WRITTEN CONSENT OF AGP.

**Salas O'Brien**

Salas O'Brien, Inc. - Oklahoma City
2900 S. Telephone Road, Suite 120
Moore, OK 73160
CA#: 9820 Expiration Date: 06/30/2027
Salas O'Brien Project Number: 2650-00226-00

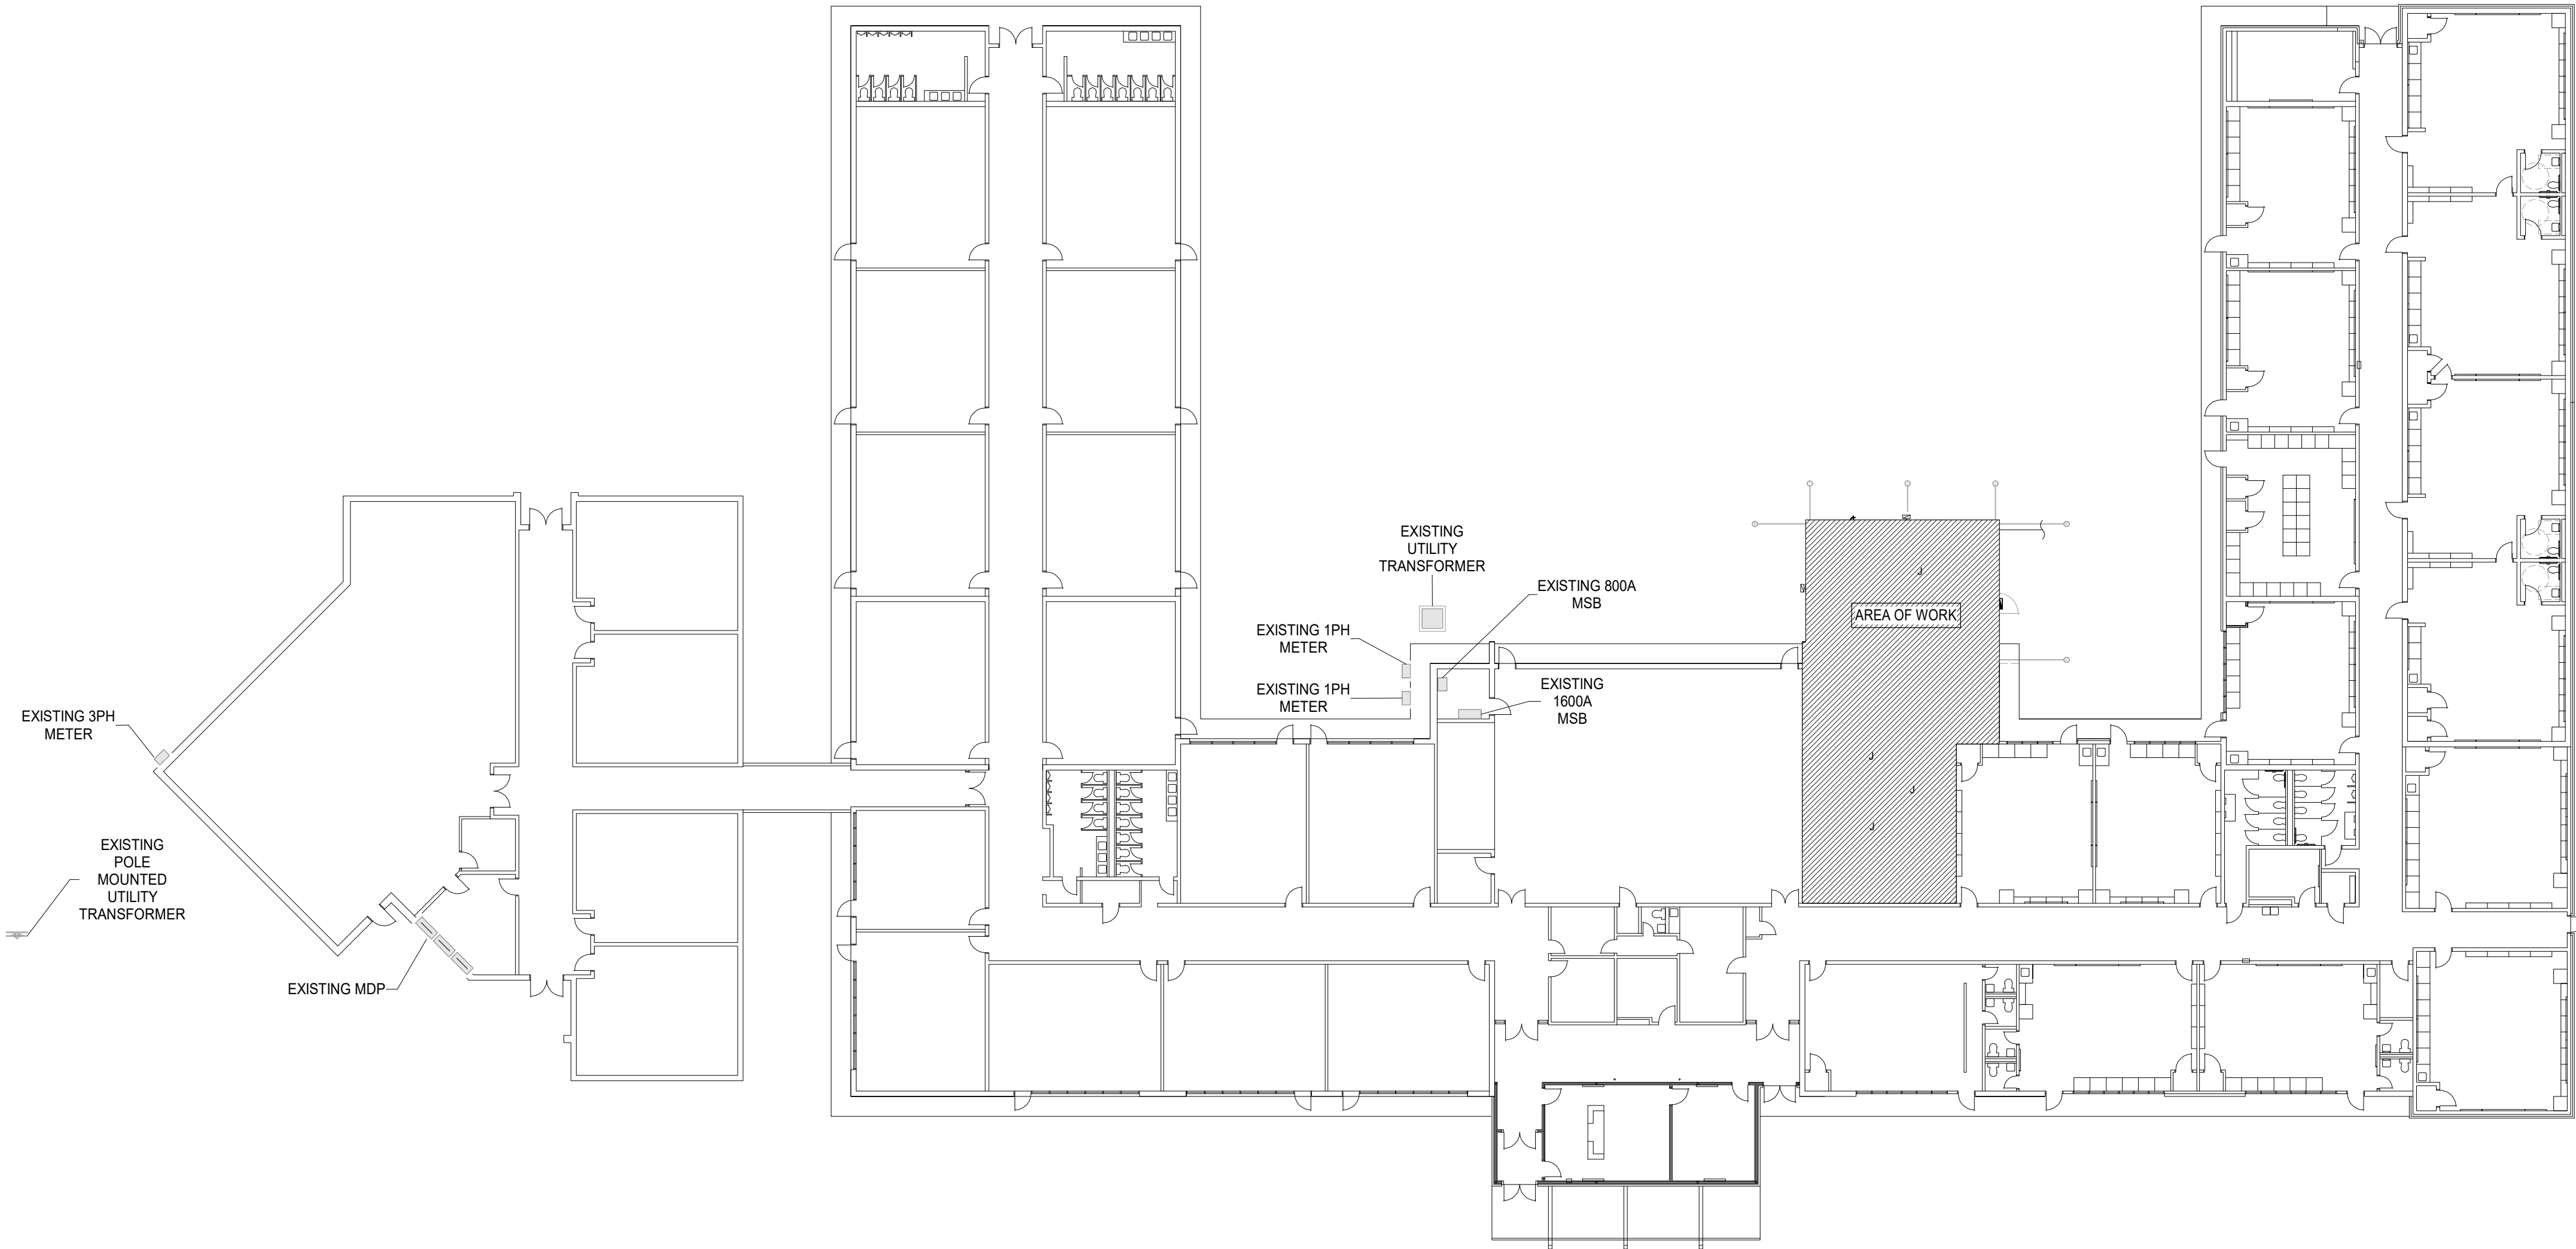

**1 ELECTRICAL SITE PLAN**

Scale: 3/64" = 1'-0"

**Salas O'Brien**

Salas O'Brien, Inc. - Oklahoma City
2900 S. Telephone Road, Suite 120
Moore, OK 73160
CA#: 9820 Expiration Date: 06/30/2027
Salas O'Brien Project Number: 2650-00226-00