


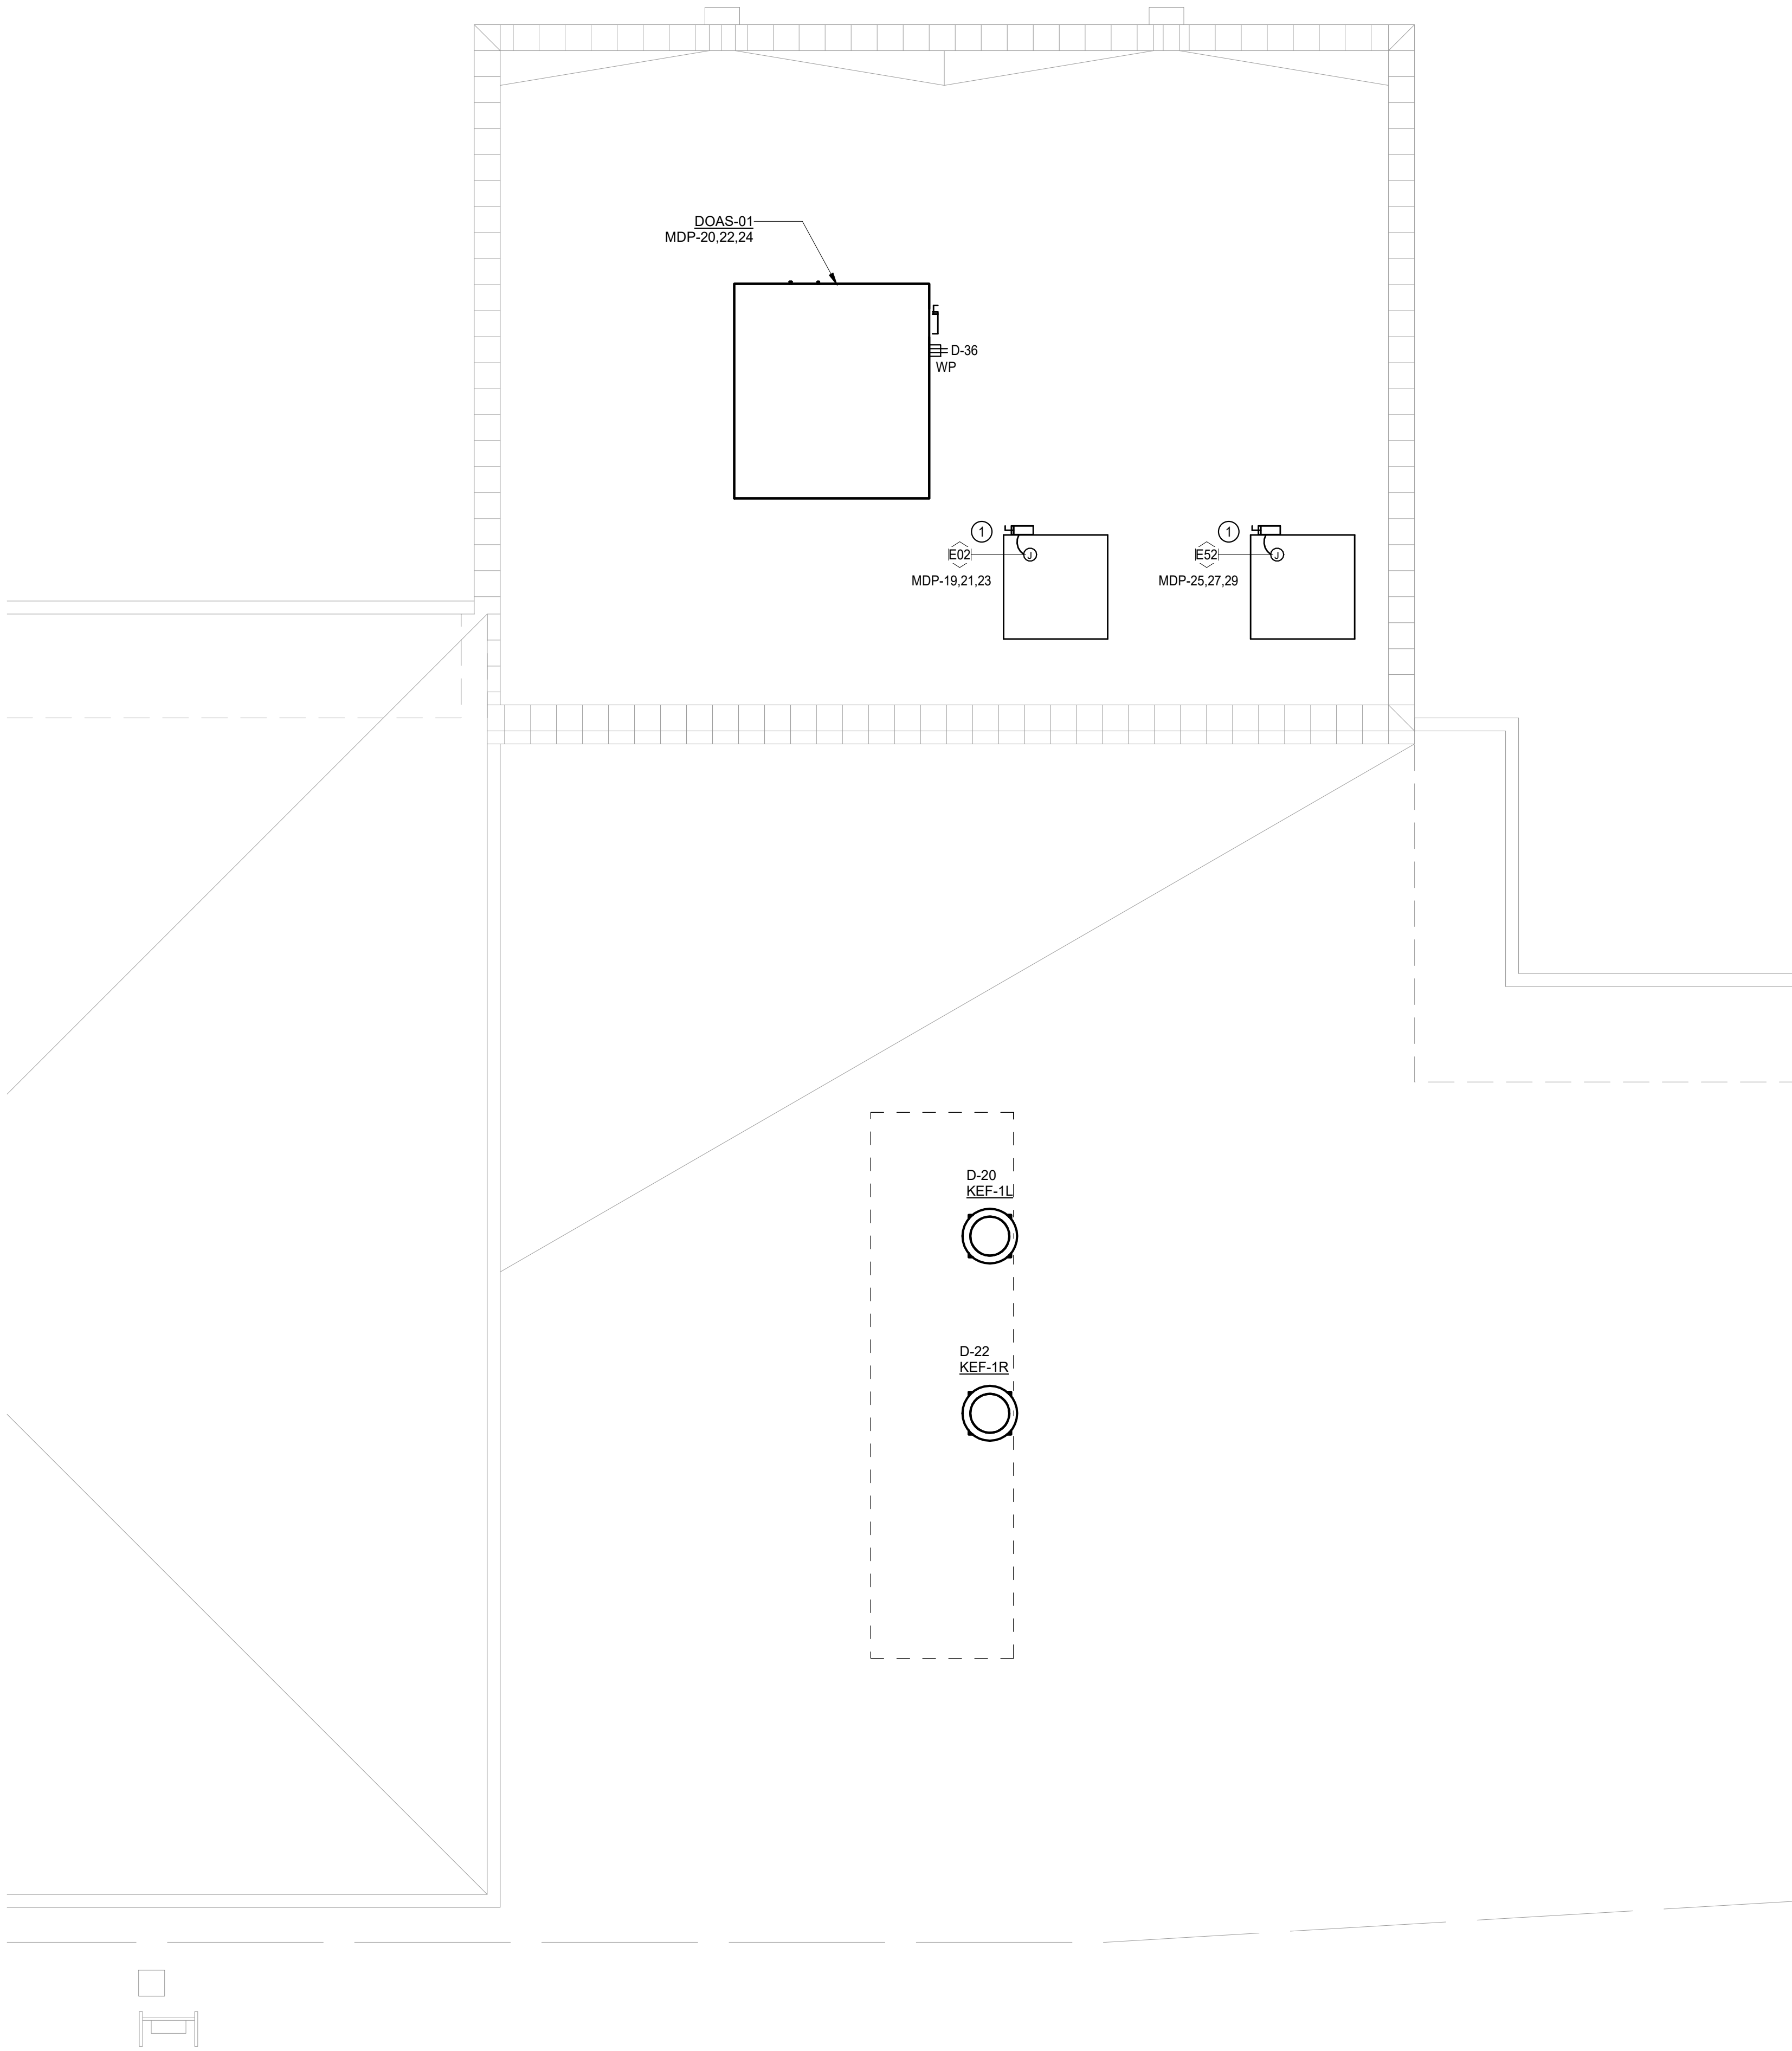

 **1 ELECTRICAL ROOF PLAN**
Scale: 1/4" = 1'-0"

- | GENERAL NOTES | |
|---------------|--|
| 1. | COORDINATE EXACT LOCATIONS OF MECHANICAL EQUIPMENT WITH MECHANICAL CONTRACTOR. |
| 2. | COORDINATE WITH MECHANICAL CONTRACTOR AND PROVIDE ALL RELAYS, CONNECTIONS, AND ALL DEVICES NECESSARY TO INTERLOCK EXHAUST FANS, DAMPERS, ETC WITH PROPER DEVICES. |
| 3. | FIRMLY MOUNT WEATHERPROOF 120V CONVENIENCE OUTLET ON UNISTRUT/KINDORF. COORDINATE WITH OTHER TRADES PRIOR TO ROUGH-IN. REDUNDANT RECEPTACLES WHETHER STAND-ALONE OR INTEGRAL TO A UNIT, MAY BE OMITTED SO LONG AS ALL OF THE REQUIREMENTS OF NEC 210.63 ARE SATISFIED. |
| 4. | REFER TO SHEET E601 FOR MECHANICAL EQUIPMENT SCHEDULE. |

ELECTRICAL KEYED NOTES	
1	WALK-IN CONDENSING UNIT. COORDINATE WITH ARCHITECT FOR EXACT LOCATION. REFER TO SHEET E601 FOR KITCHEN EQUIPMENT SCHEDULE.

AGP
the Abila Griffin
Partnership L.L.C.

313 S. E. 5th Street
MOORE, OK. 73160
405.735.3477
AGP@theAGP.net
www.theAGP.net

CEDAR CREEK
CIVIL

KFC ENGINEERING
STRUCTURAL

SALAS O'BRIEN
MECHANICAL / ELECTRICAL



JM/UB
drawn by

TVO
checked by

APRIL 2026
date

REVISIONS		
Δ	DESCRIPTION	DATE



SOUTHGATE
ELEMENTARY
KITCHEN UPGRADES
and ADDITION

sheet no:

E202

OWNERSHIP USE OF DOCUMENTS:

 Salas O'Brien
Salas O'Brien, Inc. - Oklahoma City 2900 S. Telephone Road, Suite 120 Moore, OK 73160 CA# 9820 Expiration Date: 06/30/2027 Salas O'Brien Project Number: 2650-00226-00

AGP EXPRESSLY RESERVES ITS
COPYRIGHT AND OTHER PROPERTY
RIGHTS OF ALL PLANS AND DRAWINGS
DESIGNED AND/OR PRODUCED. PLANS
AND DRAWINGS ARE NOT TO BE
REPRODUCED IN ANY FORM OR MANNER
WITHOUT THE EXPRESSED WRITTEN
CONSENT OF AGP.