


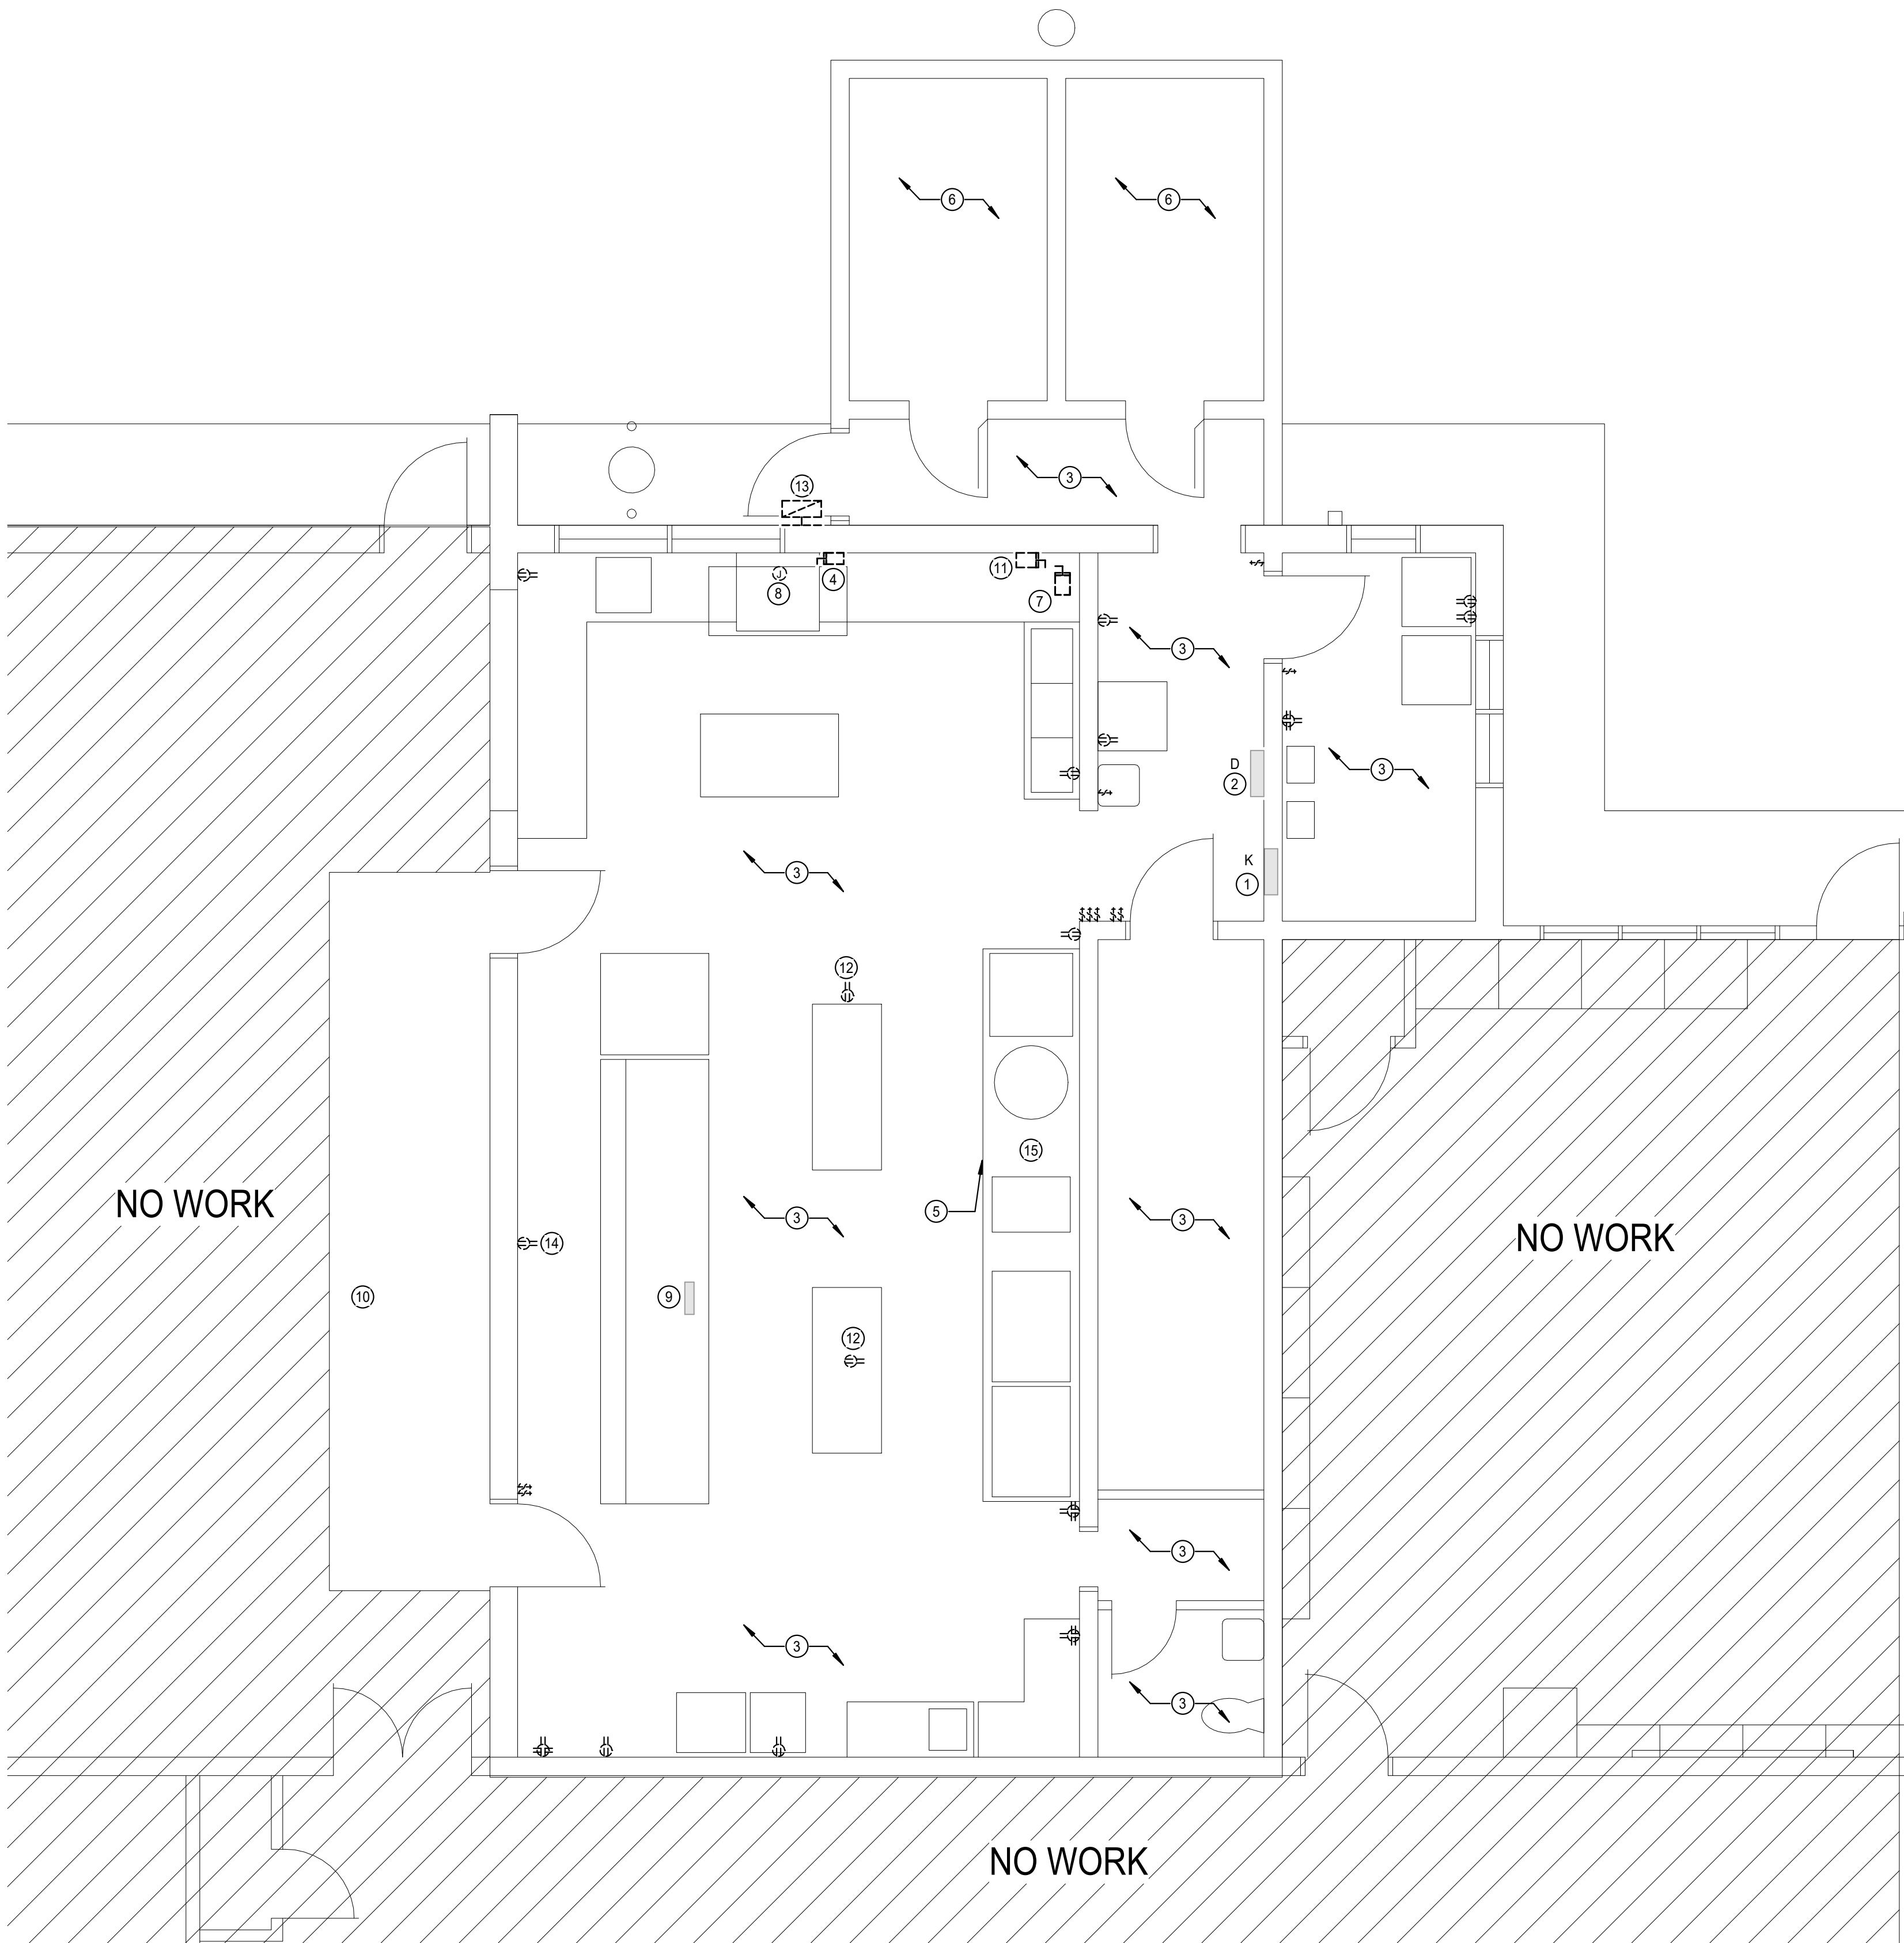

1 ELECTRICAL DEMOLITION PLAN
Scale: 1/4" = 1'-0"

- DEMOLITION GENERAL NOTES
1. THESE DEMOLITION PLANS HAVE BEEN PREPARED TO ASSIST THE CONTRACTOR IN DETERMINING THE SCOPE OF DEMOLITION WORK TO BE INCLUDED IN THIS PROJECT. THE CONTRACTOR SHOULD REVIEW ALL DRAWINGS AND SPECIFICATIONS, INCLUDING DEMOLITION SHOWN FOR OTHER TRADES, AND BECOME FAMILIAR WITH THE EXISTING CONDITIONS, IN ORDER TO DETERMINE THE SCOPE OF DEMOLITION WORK.

2. ALL EXISTING LIGHT FIXTURES, SWITCHES, AND LIGHTING DEVICES SHALL BE REMOVED AND REPLACED WITH NEW FIXTURES AS INDICATED ON NEW ELECTRICAL PLANS.

3. ALL EXISTING RECEPTACLES AND OTHER DEVICES FEEDING EXISTING KITCHEN EQUIPMENT SHALL BE REMOVED AND REPLACED WITH NEW GFCI PROTECTED DEVICES AS INDICATED ON SHEET E201.

4. DEMOLITION PLAN INFORMATION SHOWN AT TIME OF DESIGN. EC SHALL FIELD VERIFY EXISTING CONDITIONS AND MAKE ANY NECESSARY CHANGES TO COMPLETE THE WORK.

5. REMOVE ALL UNUSED WIRING AND CONDUIT BACK TO SOURCE AS PART OF THE DEMOLITION PROCESS.

6. MAINTAIN EXISTING CIRCUIT CONTINUITY FOR ALL CIRCUITS LOCATED OUTSIDE THE AREA OF WORK.

KEYED NOTES	
1	APPROXIMATE LOCATION OF EXISTING PANEL 'K' SHOWN FOR REFERENCE.
2	APPROXIMATE LOCATION OF EXISTING PANEL 'D'. REMOVE EXISTING UPSTREAM CIRCUIT BREAKER, FEEDER WIRES, AND CONDUIT BACK TO SOURCE PANEL.
3	EXISTING LIGHT FIXTURES AND ASSOCIATED CONTROLS IN AREA SHALL BE REMOVED AND REPLACED WITH NEW. REMOVE WIRE AND CONDUIT BACK TO NEAREST JBOX WHERE NOTED FOR REUSE. REFER TO SHEET E101 FOR MORE INFORMATION.
4	APPROXIMATE LOCATION OF EXISTING DISHWASHER TO BE DEMOLISHED ALONG WITH ASSOCIATED DISCONNECT. PULL WIRE AND CONDUIT BACK TO SOURCE PANEL.
5	DEMOLISH EXISTING FIRE SUPPRESSION HOOD IN PREPARATION FOR NEW. PULL FEEDERS BACK TO SOURCE PANEL.
6	DEMOLISH EXISTING FREEZER AND COOLER ELECTRICAL CONNECTIONS. REMOVE WIRE AND CONDUIT BACK TO SOURCE PANEL.
7	APPROXIMATE LOCATION OF EXISTING DISHWASHER BOOSTER HEATER TO BE DEMOLISHED ALONG WITH ASSOCIATED DISCONNECT. PULL WIRE AND CONDUIT BACK TO SOURCE PANEL.
8	APPROXIMATE LOCATION OF EXISTING DISHWASHER HOOD TO BE DEMOLISHED. PULL WIRE AND CONDUIT BACK TO SOURCE PANEL.
9	EXISTING SERVING LINE TO BE TEMPORARILY RELOCATED DURING CONSTRUCTION OF THIS PROJECT. PROVIDE (2) 120V 20A CIRCUITS AS TEMPORARY POWER FOR SERVING LINE POS AND MILK COOLER TO TEMPORARY LOCATION. TERMINATE EXISTING LOAD CENTER CONNECTION IN JBOX FOR LATER RECONNECTION.
10	APPROXIMATE TEMPORARY LOCATION OF SERVING LINE DURING TIME OF CONSTRUCTION.
11	APPROXIMATE LOCATION OF EXISTING WALK-IN DISCONNECT TO BE DEMOLISHED. PULL WIRE AND CONDUIT BACK TO SOURCE PANEL.
12	FLOOR RECEPTACLE TO BE REPLACED WITH CORD REEL. REMOVE WIRE AND CONDUIT BACK TO NEAREST JBOX WHERE NOTED FOR REUSE.
13	DEMOLISH EXISTING WALLPACK. REMOVE WIRE AND CONDUIT BACK TO NEAREST JBOX.
14	REMOVE WALL MOUNTED FAN PLUGGED INTO RECEPTACLE AND RETURN TO OWNER AS PART OF THE DEMOLITION PROCESS.
15	EXISTING GAS RANGE TO BE REPLACED WITH ELECTRIC RANGE IN SAME LOCATION.

AGP
the Abila Griffin
Partnership L.L.C.

313 S. E. 5th Street
MOORE, OK. 73160
405.735.3477
AGP@theAGP.net
www.theAGP.net

CEDAR CREEK
CIVIL

KFC ENGINEERING
STRUCTURAL

SALAS O'BRIEN
MECHANICAL / ELECTRICAL



JM/JB
drawn by

TVO
checked by

APRIL 2026
date

REVISIONS		
Δ	DESCRIPTION	DATE



SOUTHGATE
ELEMENTARY
KITCHEN UPGRADES
and ADDITION

sheet no:

ED101

OWNERSHIP USE OF DOCUMENTS:

AGP EXPRESSLY RESERVES ITS COPYRIGHT AND OTHER PROPERTY RIGHTS OF ALL PLANS AND DRAWINGS DESIGNED AND/OR PRODUCED. PLANS AND DRAWINGS ARE NOT TO BE REPRODUCED IN ANY FORM OR MANNER WITHOUT THE EXPRESSED WRITTEN CONSENT OF AGP.

**Salas O'Brien**

Salas O'Brien, Inc. - Oklahoma City
2900 S. Telephone Road, Suite 120
Moore, OK 73160
CA# 9820 Expiration Date: 06/30/2027
Salas O'Brien Project Number: 2650-00226-00