


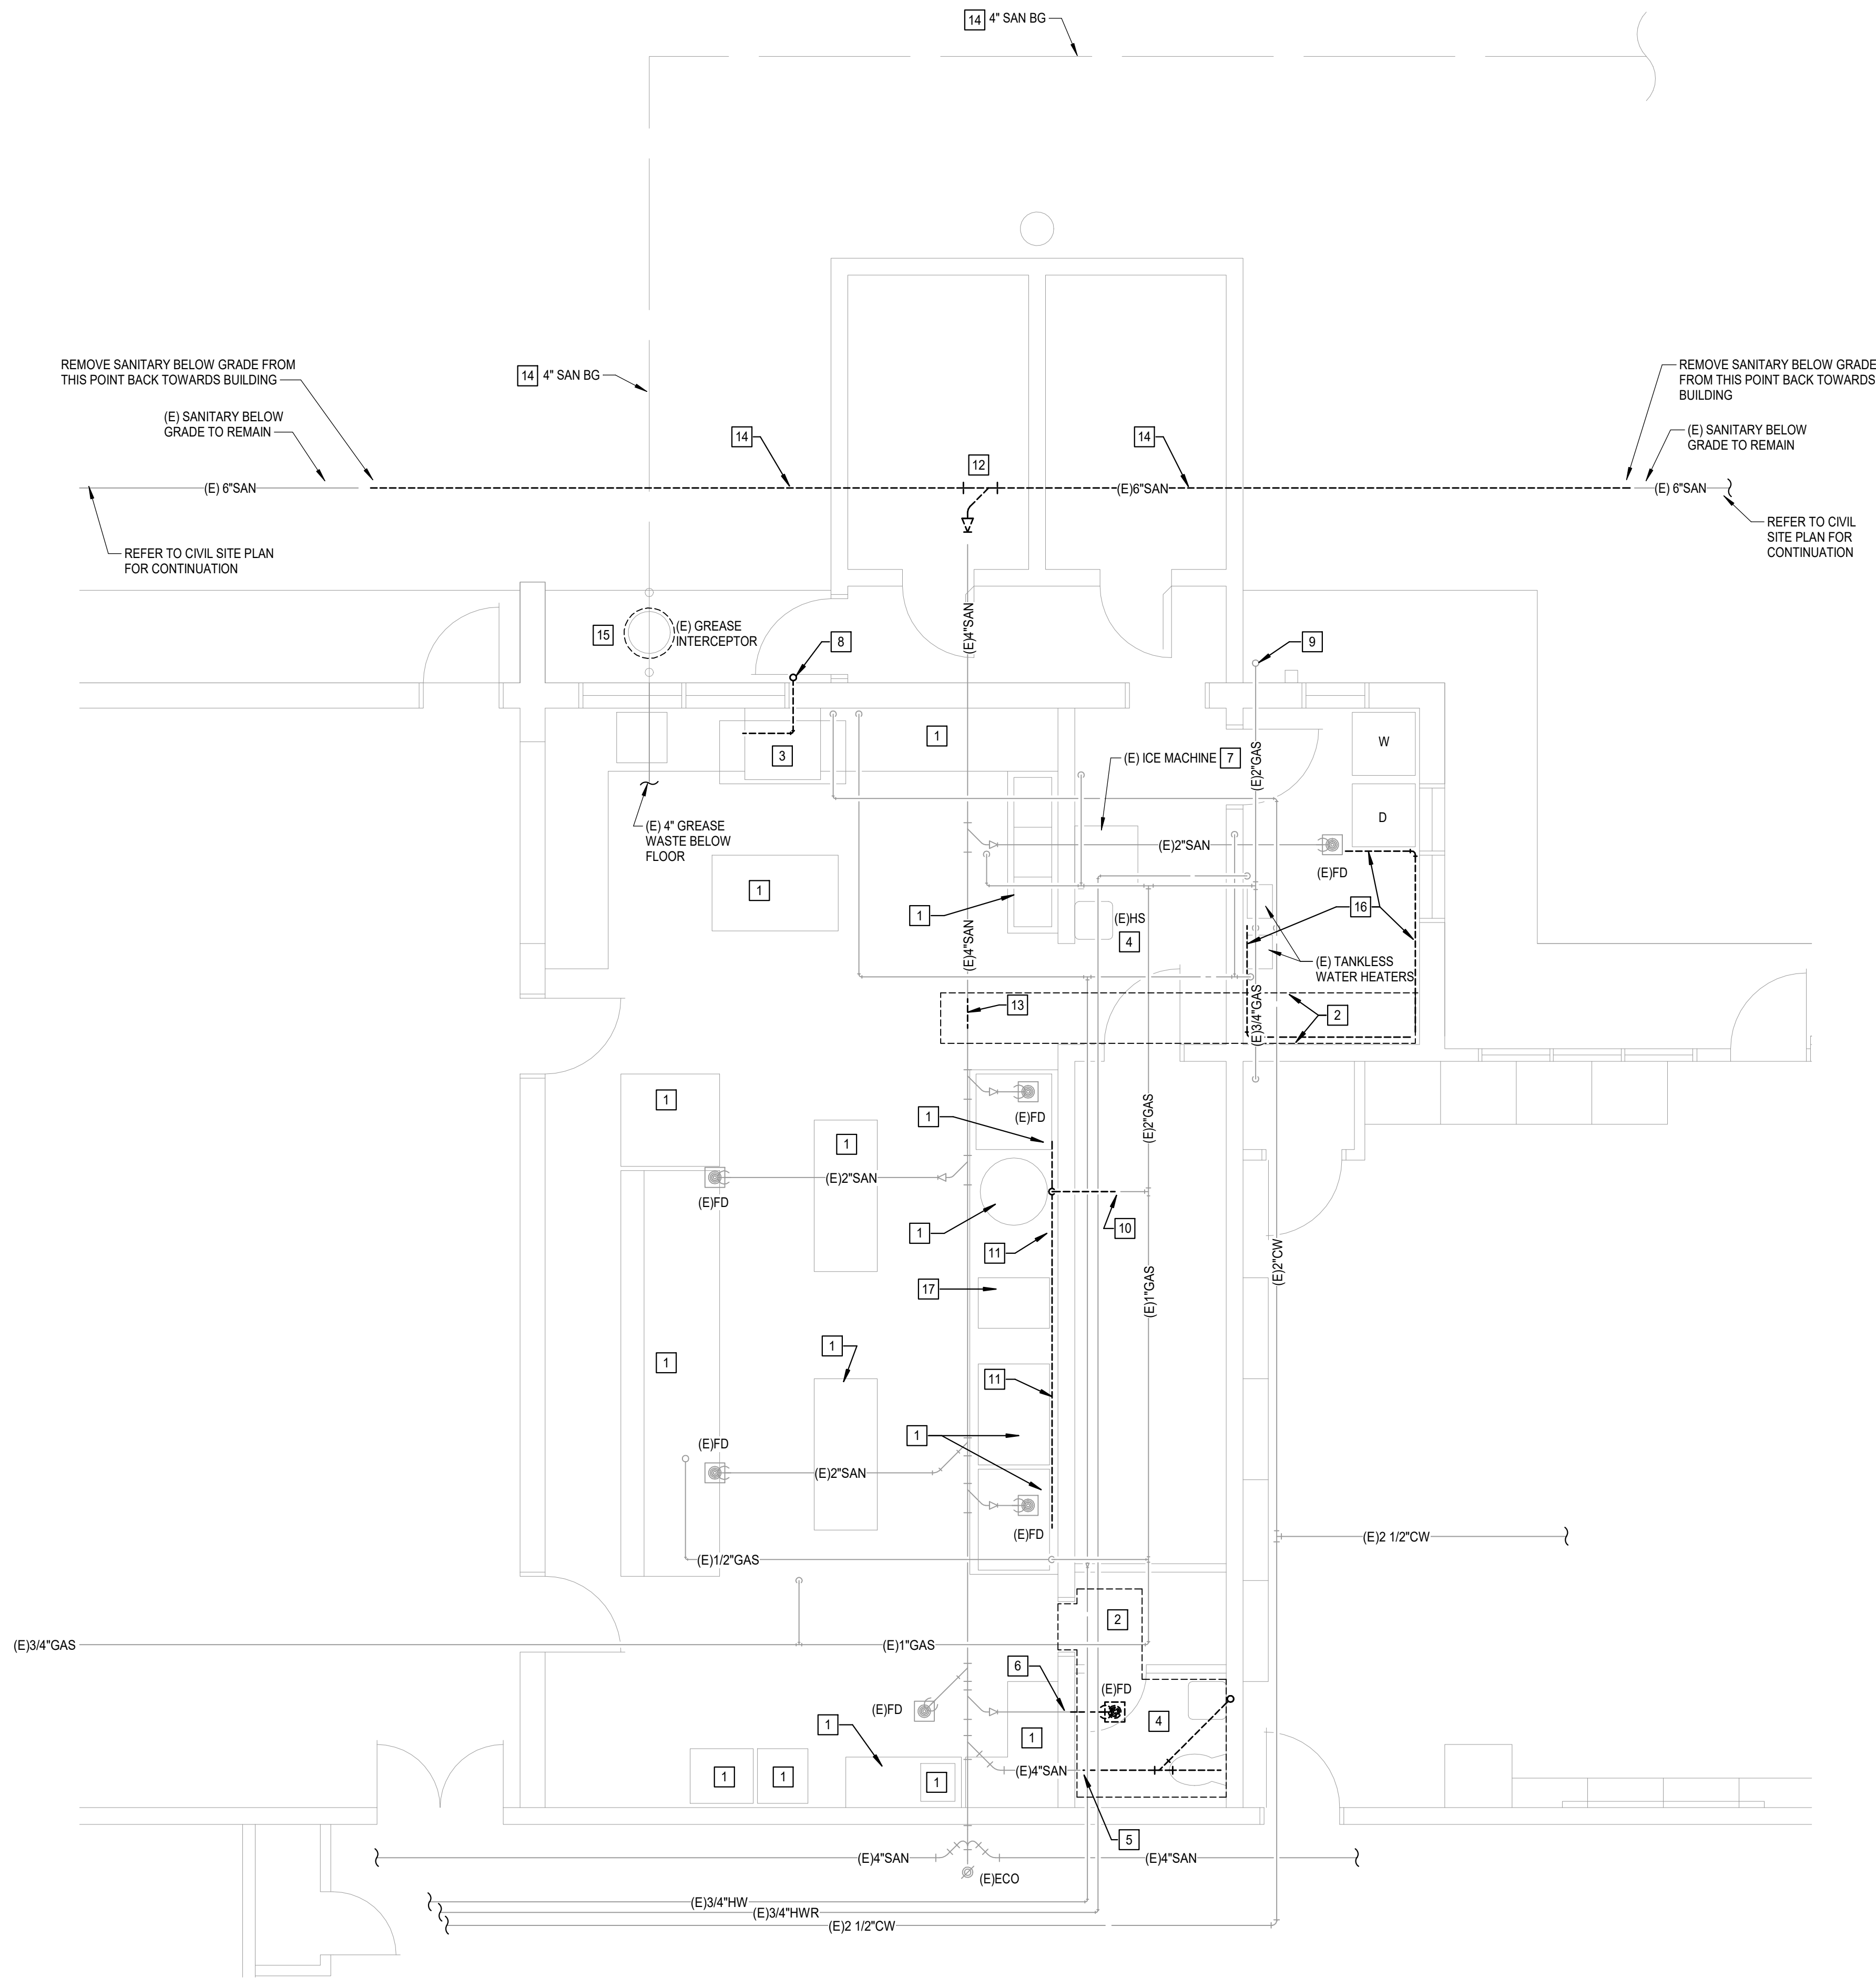

1 PLUMBING DEMOLITION PLAN
Scale: 1/4" = 1'-0"

GENERAL NOTES

- COORDINATE WORK WITH ALL OTHER TRADES ON SITE.
- FIELD VERIFY EXISTING CONDITIONS PRIOR TO COMMENCING WORK.
- REFER TO PLUMBING RENOVATION NOTES ON SHEET P000.
- COORDINATE WITH GENERAL CONTRACTOR FOR ALL REQUIRED FLOOR, WALL AND CEILING CUTTING FOR DEMOLITION AND NEW WORK.
- SANITARY VENT PIPING CONCEALED IN WALLS TO REMAIN UNLESS CONDITION OF PIPING REQUIRES REPLACEMENT.
- WATER PIPING CONCEALED IN WALL GOING UP TO CEILING TO REMAIN OR ABANDON IN PLACE AND CAPPED IF NOT REUSED.

KEYED NOTES

- REMOVE PLUMBING CONNECTIONS TO EXISTING KITCHEN EQUIPMENT. CAP ALL ASSOCIATED PIPING FOR REINSTALLATION OF KITCHEN EQUIPMENT IN SAME LOCATION. GAS PIPING TO BE REMOVED.
- COORDINATE WITH GC FOR FLOOR CUTTING AND WALL CUTTING IN THIS AREA FOR INSTALLATION OF NEW SANITARY PIPE.
- REMOVE ALL ASSOCIATED PIPING TO DISHWASHER AND DISHTABLE FOR INSTALLATION OF NEW FIXTURE IN SAME LOCATION. REMOVE GAS PIPING THRU WALL AND CAP.
- REMOVE EXISTING PLUMBING FIXTURES AND ALL ASSOCIATED PIPING BACK TO MAINS AND CAP.
- REMOVE SANITARY PIPING BELOW FLOOR BACK TO NEAR WALL AND CAP.
- REMOVE EXISTING 2" SANITARY SERVING FLOOR DRAIN BACK TO WALL AND CAP FOR REUSE OF NEW PLUMBING FIXTURE.
- REMOVE EXISTING ICE MACHINE AND TURN OVER TO OWNER FOR REUSE. REMOVE ALL ASSOCIATED PIPING BACK TO MAINS AND CAP.
- REMOVE 3/4" GAS PIPE ON EXTERIOR WALL UP TO ROOF AND PIPE ON ROOF TO MAIN. CAP BRANCH PIPE AT MAIN.
- COORDINATE WITH GC FOR REQUIRED REROUTING OF 2" GAS UP TO ROOF FOR NEW ADDITION CONSTRUCTION.
- REMOVE 1 1/2" GAS PIPE INTO WALL AND DOWN TO NEAR FLOOR. 1 1/2" GAS BRANCH PIPE TO BE REUSED AT MAIN.
- REMOVE GAS PIPING AND VALVES SERVING KITCHEN EQUIPMENT UNDER HOOD.
- REMOVE 4" SANITARY CONNECTION TO 6" SANITARY. CAP 4" SANITARY FOR CONNECTION TO NEW SANITARY PIPE.
- REMOVE SECTION OF BELOW GRADE 4" SANITARY FOR NEW BRANCH SANITARY CONNECTION.
- REMOVE EXISTING BELOW GRADE SANITARY PIPE.
- REMOVE AND RELOCATE GREASE INTERCEPTOR. REMOVE CLEANOUTS AND ASSOCIATED PIPING BELOW GRADE OUTSIDE OF BUILDING.
- REMOVE ABOVE FLOOR WATER HEATER CONDENSATE DRAIN LINE FROM HEATERS TO TERMINATION POINT AT FLOOR DRAIN.
- REMOVE GAS CONNECTION TO KITCHEN RANGE AND BRANCH GAS PIPE BACK TO MAIN.

AGP
the Abla Griffin
Partnership L.L.C.

313 S. E. 5th Street
MOORE, OK. 73160
405.735.3477
AGP@theAGP.net
www.theAGP.net

CEDAR CREEK

CIVIL

KFC ENGINEERING

STRUCTURAL

SALAS O'BRIEN

MECHANICAL / ELECTRICAL



KS

drawn by

KP

checked by

APRIL 2026

date

REVISIONS

Δ	DESCRIPTION	DATE



SOUTHGATE
ELEMENTARY
KITCHEN UPGRADES
and ADDITION

sheet no:

PD101

OWNERSHIP USE OF DOCUMENTS:



Salas O'Brien, Inc. - Oklahoma City
2900 S. Telephone Road, Suite 120
Moore, OK. 73160
CA# 9820 Expiration Date: 06/30/2027
Salas O'Brien Project Number: 2650-00226-00

AGP EXPRESSLY RESERVES ITS
COPYRIGHT AND OTHER PROPERTY
RIGHTS OF ALL PLANS AND DRAWINGS
DESIGNED AND/OR PRODUCED. PLANS
AND DRAWINGS ARE NOT TO BE
REPRODUCED IN ANY FORM OR MANNER
WITHOUT THE EXPRESSED WRITTEN
CONSENT OF AGP.