



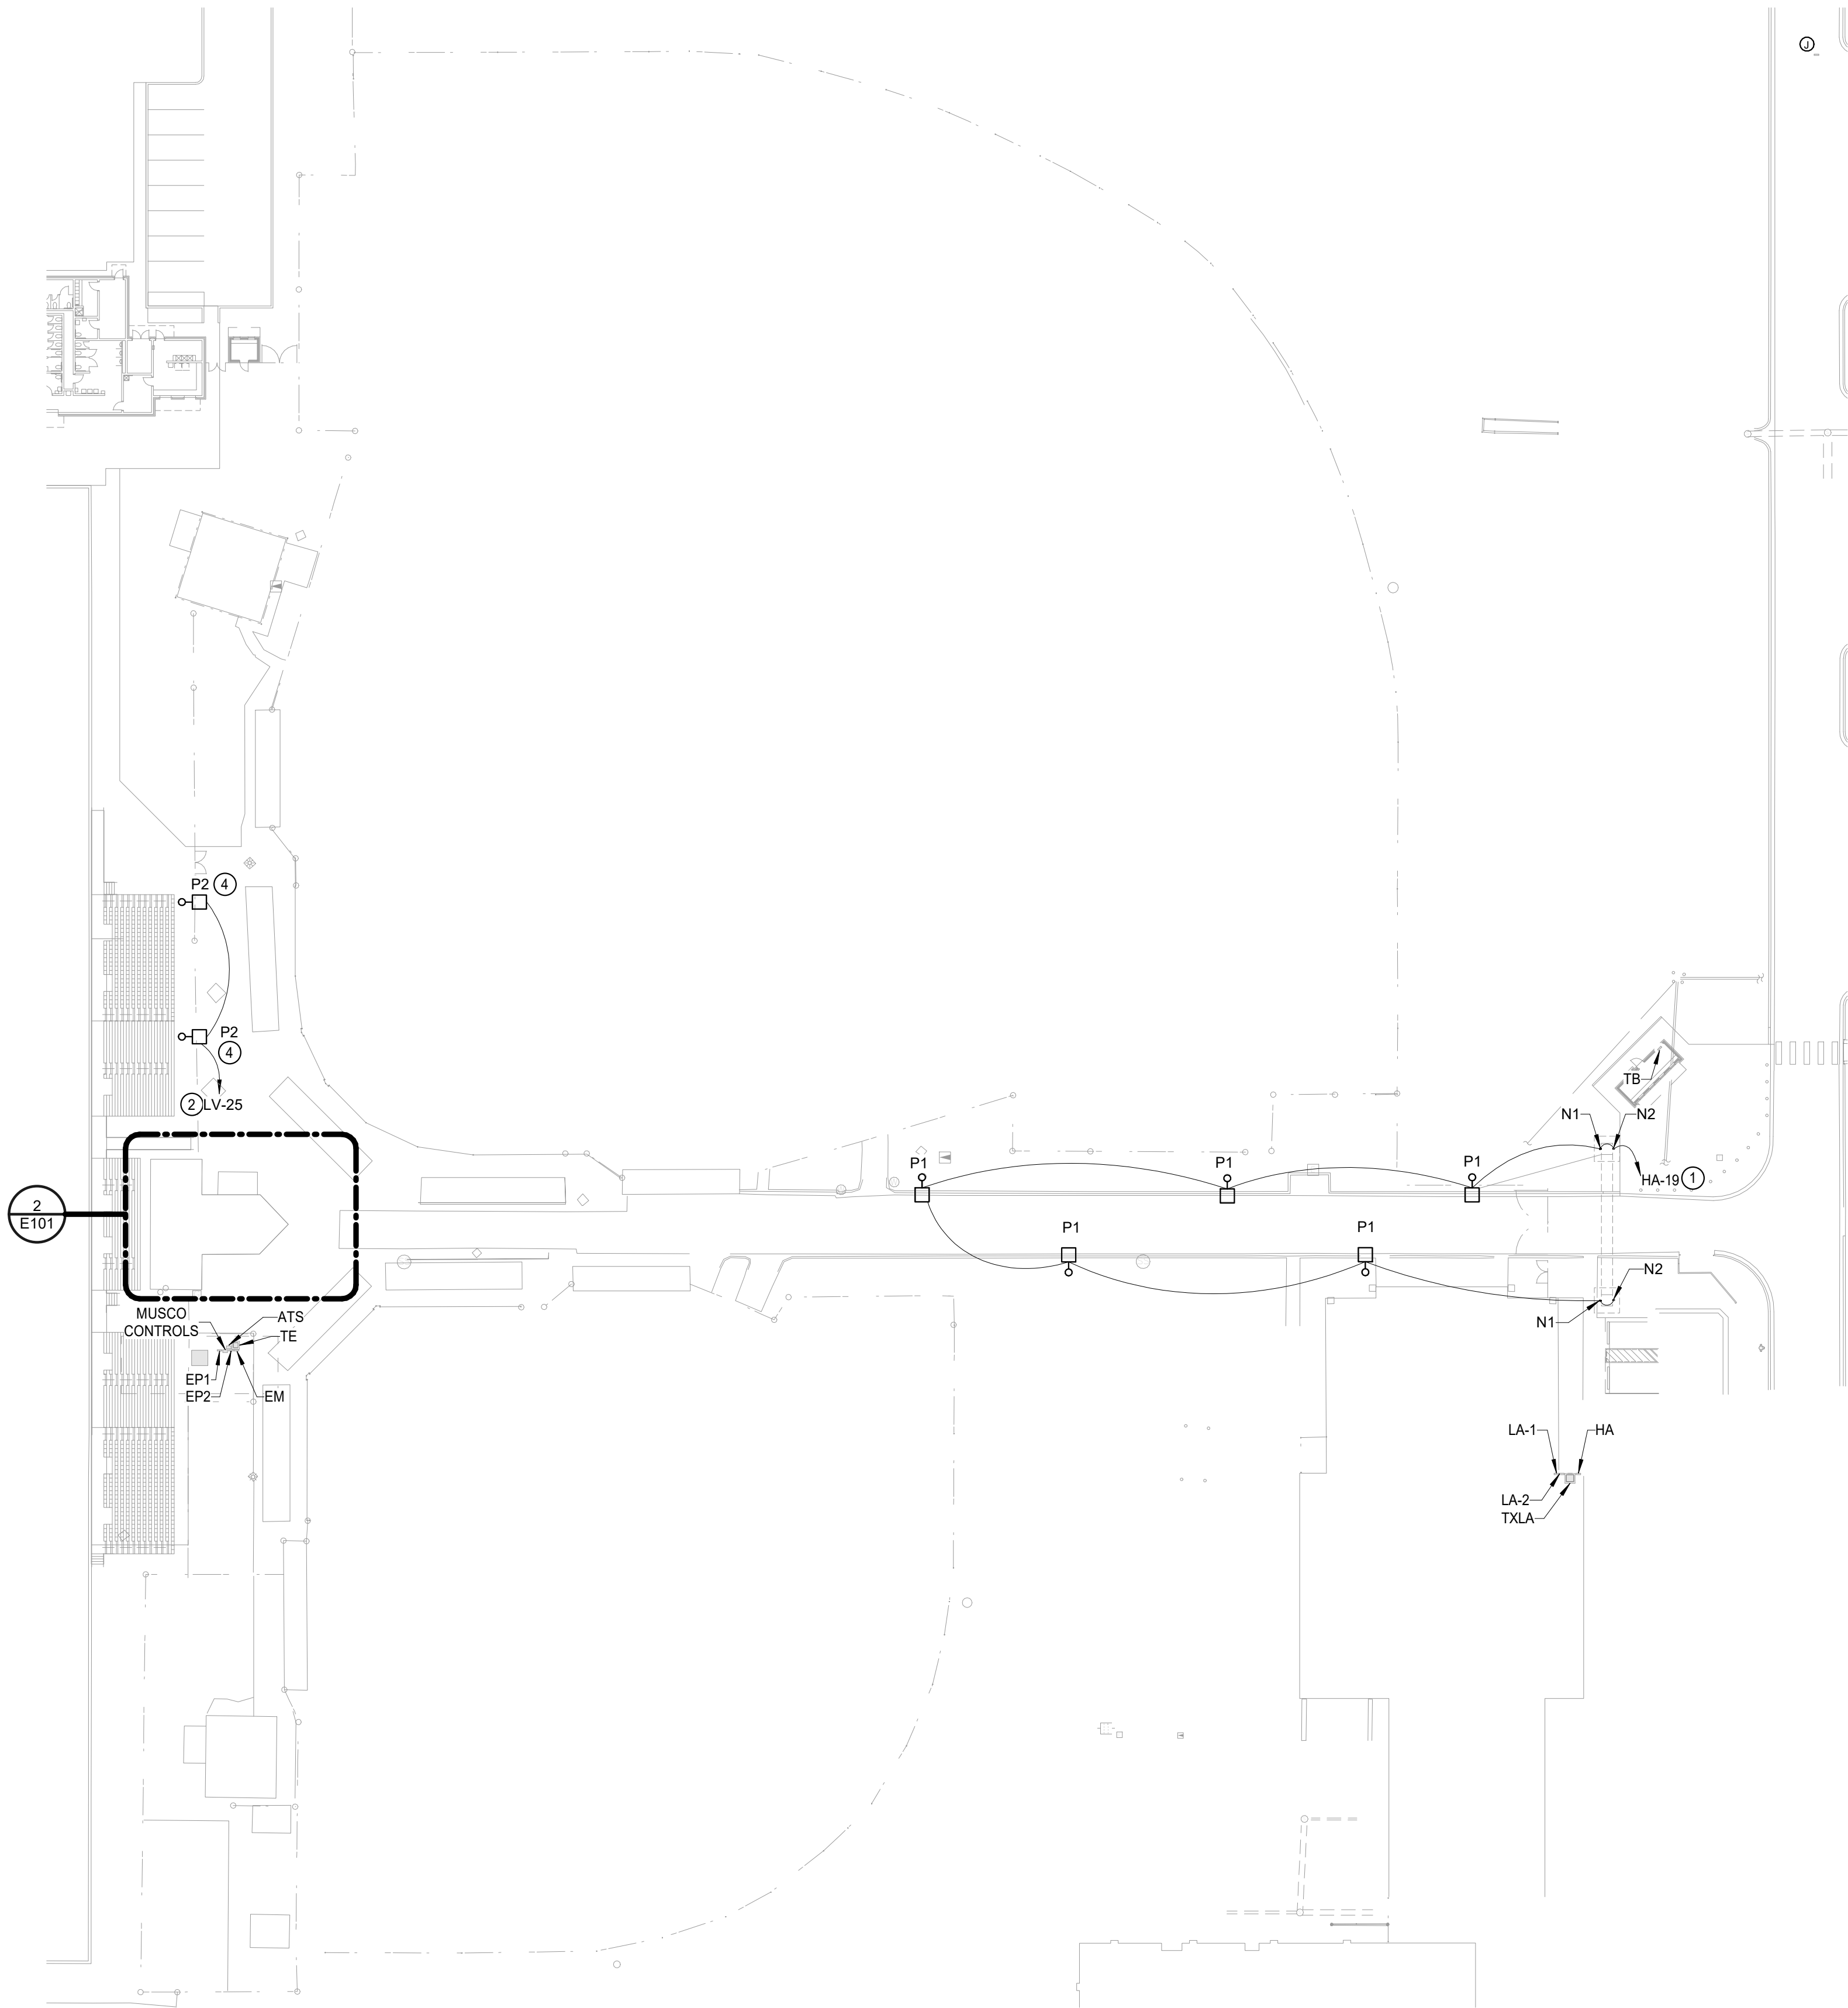

1 ELECTRICAL SITE PLAN
Scale: 1" = 40'-0"

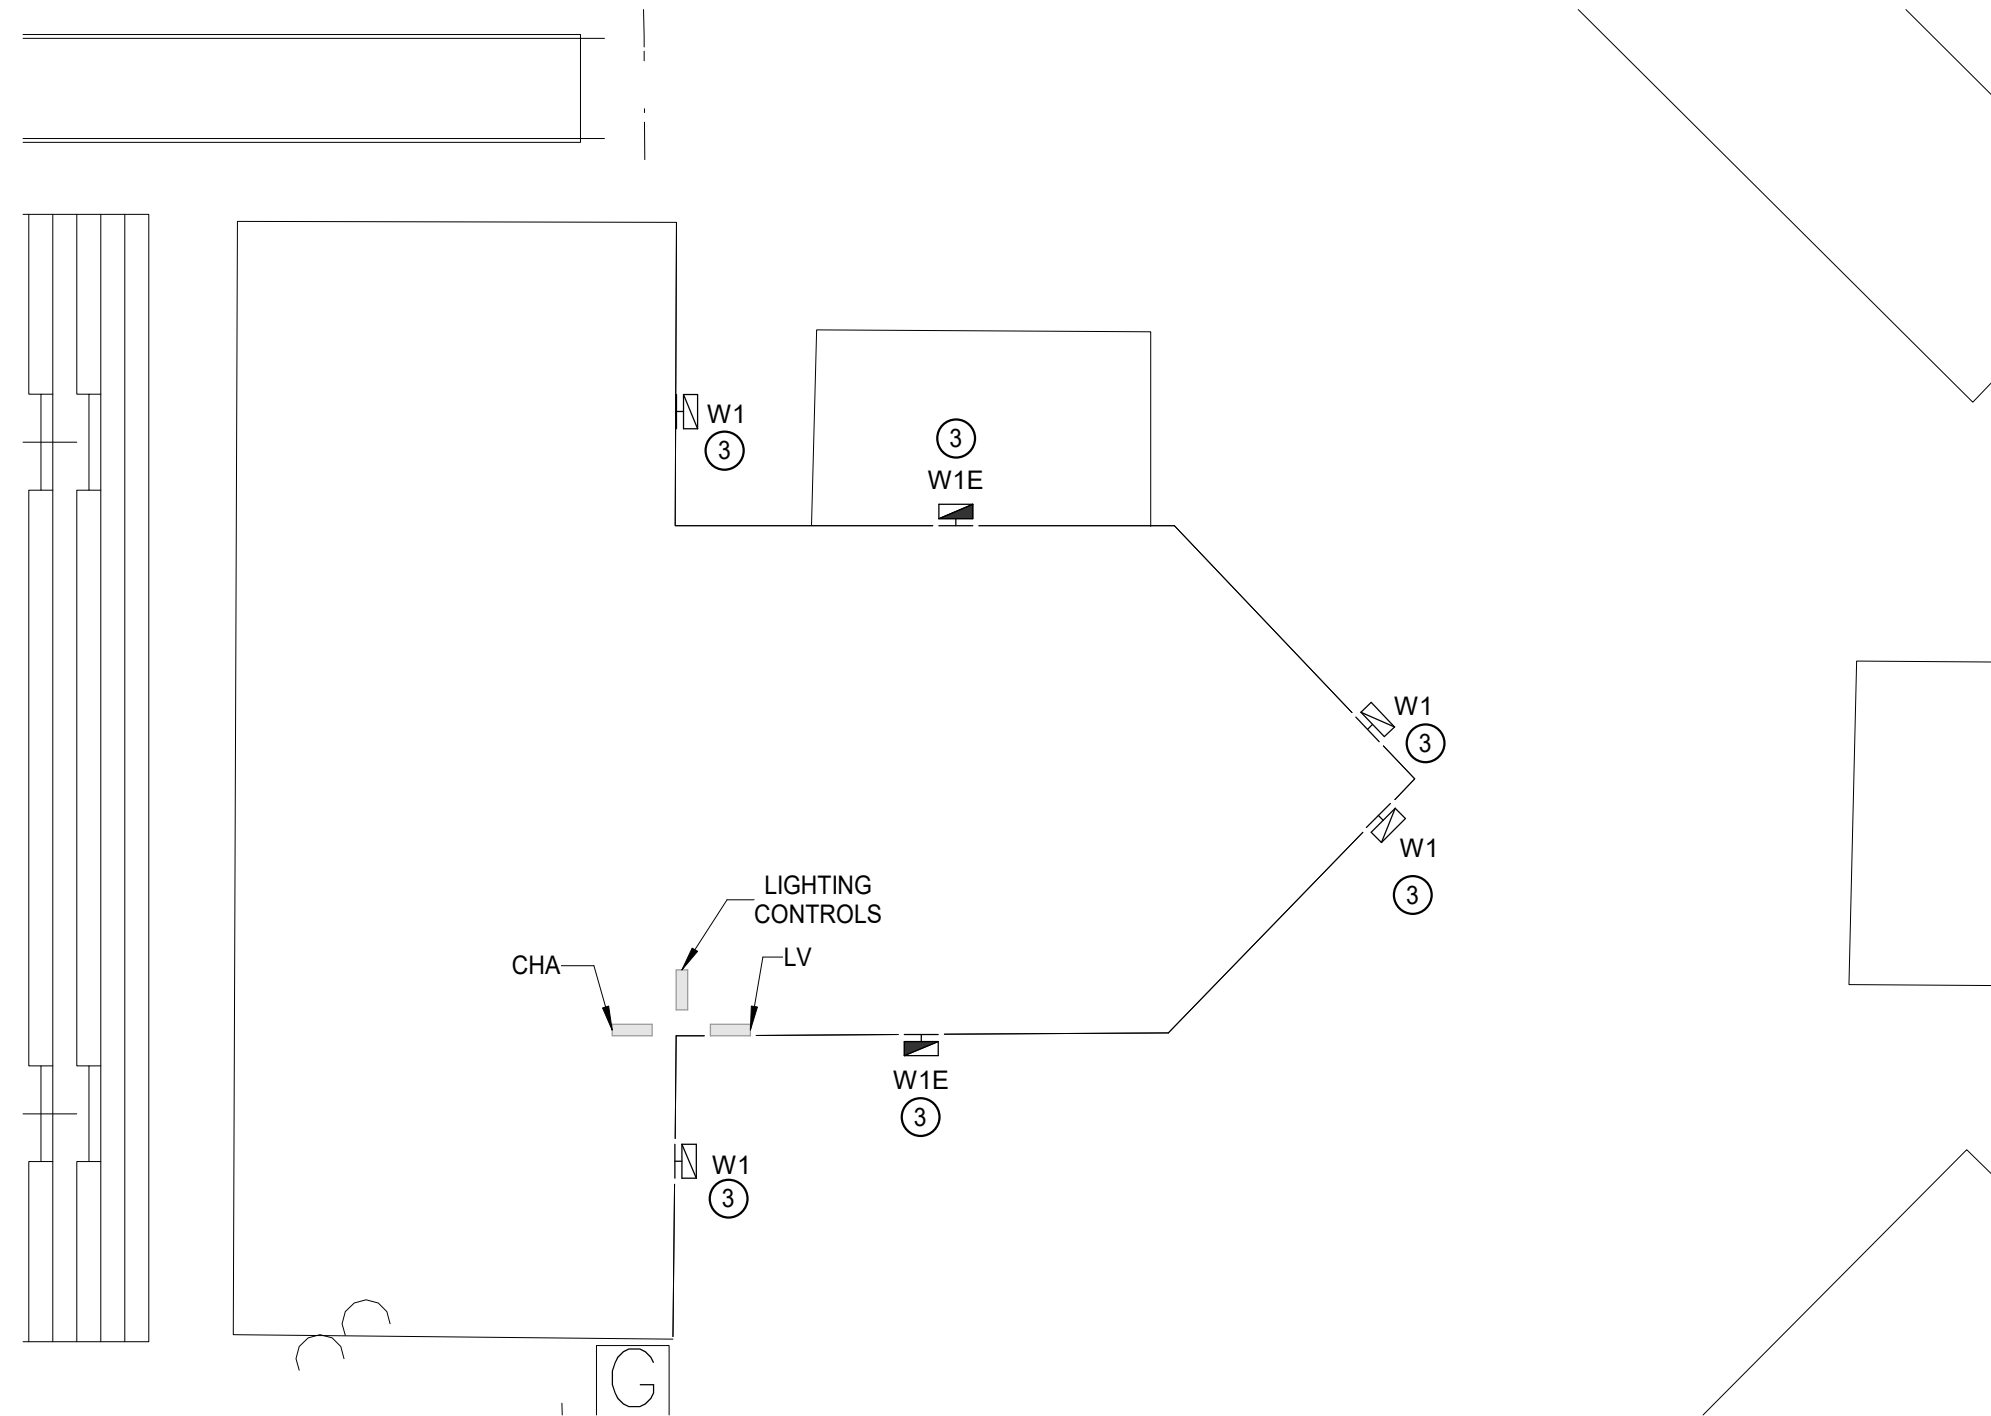

2 ELECTRICAL PLAN - PRESS BOX
Scale: 1/8" = 1'-0"

GENERAL NOTES

- PANELS AND TRANSFORMERS SHOWN ON PLANS ARE EXISTING AND SHOWN FOR REFERENCE ONLY UNLESS OTHERWISE INDICATED.
- PROVIDE (1) ELECTRONIC TIMER WITH INTEGRAL ASTRONOMICAL TIMECLOCK. TIMER SHALL CONTROL ARCH WAY LIGHTING AND NEW SITE POLE FIXTURES. FED FROM PANEL 'HA'.
- EXISTING TIMECLOCK TIMER SHALL BE REUSED TO CONTROL NEW WALLPACKS AND NEW SITE POLE FIXTURES IN THE PRESS BOX.
- THESE DRAWINGS ARE INTENDED TO BE DIAGRAMMATIC ONLY. CONSULT WITH GENERAL CONTRACTOR FOR DETAILS ON BIDDING; PROVIDE ALL PARTS AND LABOR FOR A COMPLETE AND CODE COMPLIANT FACILITY.

KEYED NOTES

- PROVIDE DEDICATED 20A BREAKER CONNECTION FROM SPACE IN PANEL 'HA'. REFER TO SHEET 'E601' FOR ADDITIONAL INFORMATION.
- CIRCUIT NEW POLE FIXTURES TO EXISTING WALL PACK CIRCUIT IN PANEL 'LV' AS INDICATED. PROVIDE NEW CONDUIT AND WIRE AS REQUIRED TO EXTEND EXISTING CIRCUIT.
- CIRCUIT NEW FIXTURES TO EXISTING LIGHTING CIRCUITS. PROVIDE NEW WIRE AND CONDUIT AS REQUIRED. EXISTING WIRE AND CONDUIT MAY BE REUSED WHERE IN SERVICABLE CONDITION AND SIZED APPROPRIATELY. EC SHALL WARRANTY ANY REUSED MATERIALS AS NEW.
- RUN CONDUIT ON - GRADE TO NEW POLE FIXTURE LOCATIONS. COORDINATE EXACT REQUIREMENTS WITH OWNER AND ARCHITECT PRIOR TO BEGINNING WORK.

AGP
the Abila Griffin
Partnership L.L.C.

313 S. E. 5th Street
MOORE, OK. 73160
405.735.3477
AGP@theAGP.net
www.theAGP.net

KFC ENGINEERING

STRUCTURAL

SALAS O'BRIEN

PLUMBING / MECHANICAL / ELECTRICAL



JM

drawn by

TVO

checked by

MAY 2026

date

REVISIONS

Δ	DESCRIPTION	DATE



**SOUTHMOORE
HIGH SCHOOL
2026 ATHLETIC PLAZA
UPGRADES**

sheet no:

E101

OWNERSHIP USE OF DOCUMENTS:

AGP EXPRESSLY RESERVES ITS
COPYRIGHT AND OTHER PROPERTY
RIGHTS OF ALL PLANS AND DRAWINGS
DESIGNED AND/OR PRODUCED. PLANS
AND DRAWINGS ARE NOT TO BE
REPRODUCED IN ANY FORM OR MANNER
WITHOUT THE EXPRESSED WRITTEN
CONSENT OF AGP.

