





CG	drawn by
MA	checked by
AUGUST 2025	date
	revisions

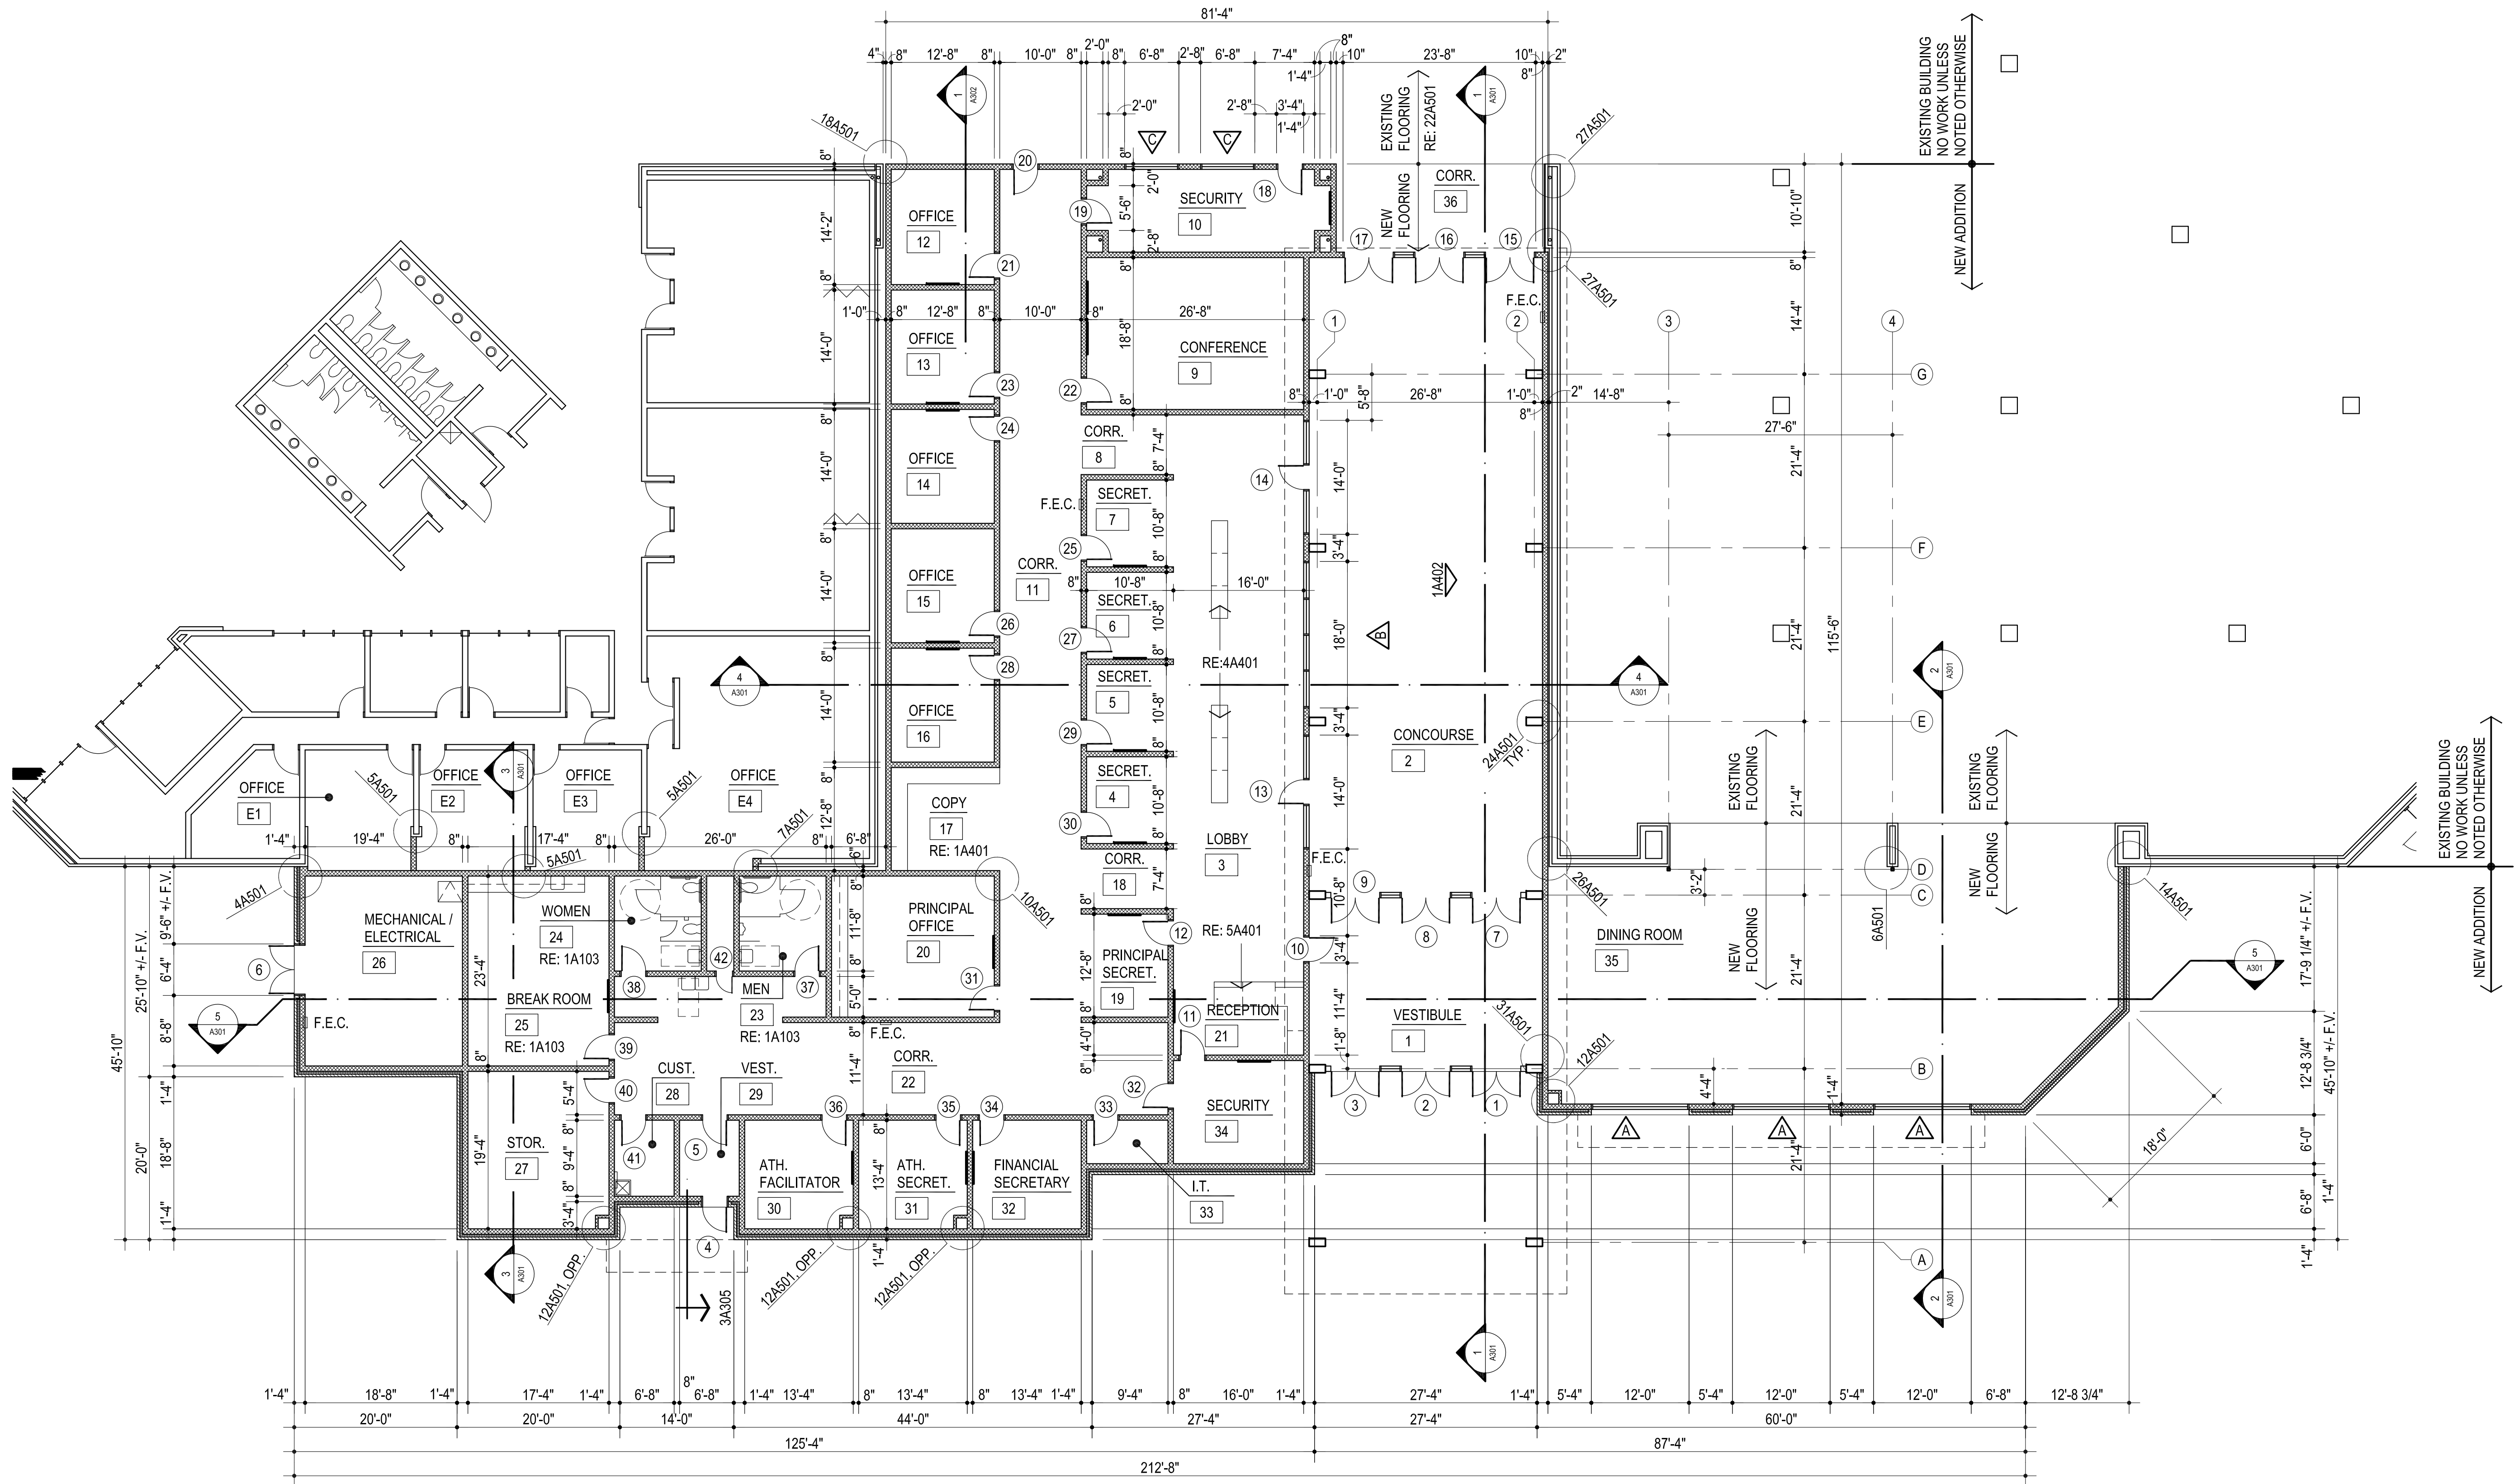

MISCELLANEOUS NOTES:

1. F.E.C. - FIRE EXTINGUISHER AND CABINET
2. REFER SHEET A108 FOR FLOORING FINISH LAYOUT
3. DO NOT SCALE DRAWINGS TO OBTAIN MATERIAL QUANTITIES. USE DRAWINGS WHICH ARE DIMENSIONED OR COORDINATE W/ EXISTING CONDITIONS &/OR ARCHITECT & ENGINEERS.
4. PROVIDE BULLNOSE @ ALL EXPOSED CMU CORNERS & ENDS

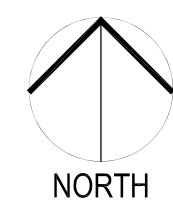

1

FLOOR PLAN

3/32" = 1'-0" 14,600 SQ. FT.

