



CG  
drawn by  
MA  
checked by  
AUGUST 2025  
date  
revisions



WESTMOORE HIGH  
SCHOOL ENTRY  
UPGRADES



sheet no:

**A107**

EQUIPMENT PLAN

OWNERSHIP USE OF DOCUMENTS:

AGP EXPRESSLY RESERVES ITS  
COPYRIGHT AND OTHER PROPERTY  
RIGHTS OF ALL PLANS AND DRAWINGS  
DESIGNED AND/OR PRODUCED. PLANS  
AND DRAWINGS ARE NOT TO BE  
REPRODUCED IN ANY FORM OR MANNER  
WITHOUT THE EXPRESSED WRITTEN  
CONSENT OF AGP.

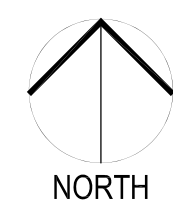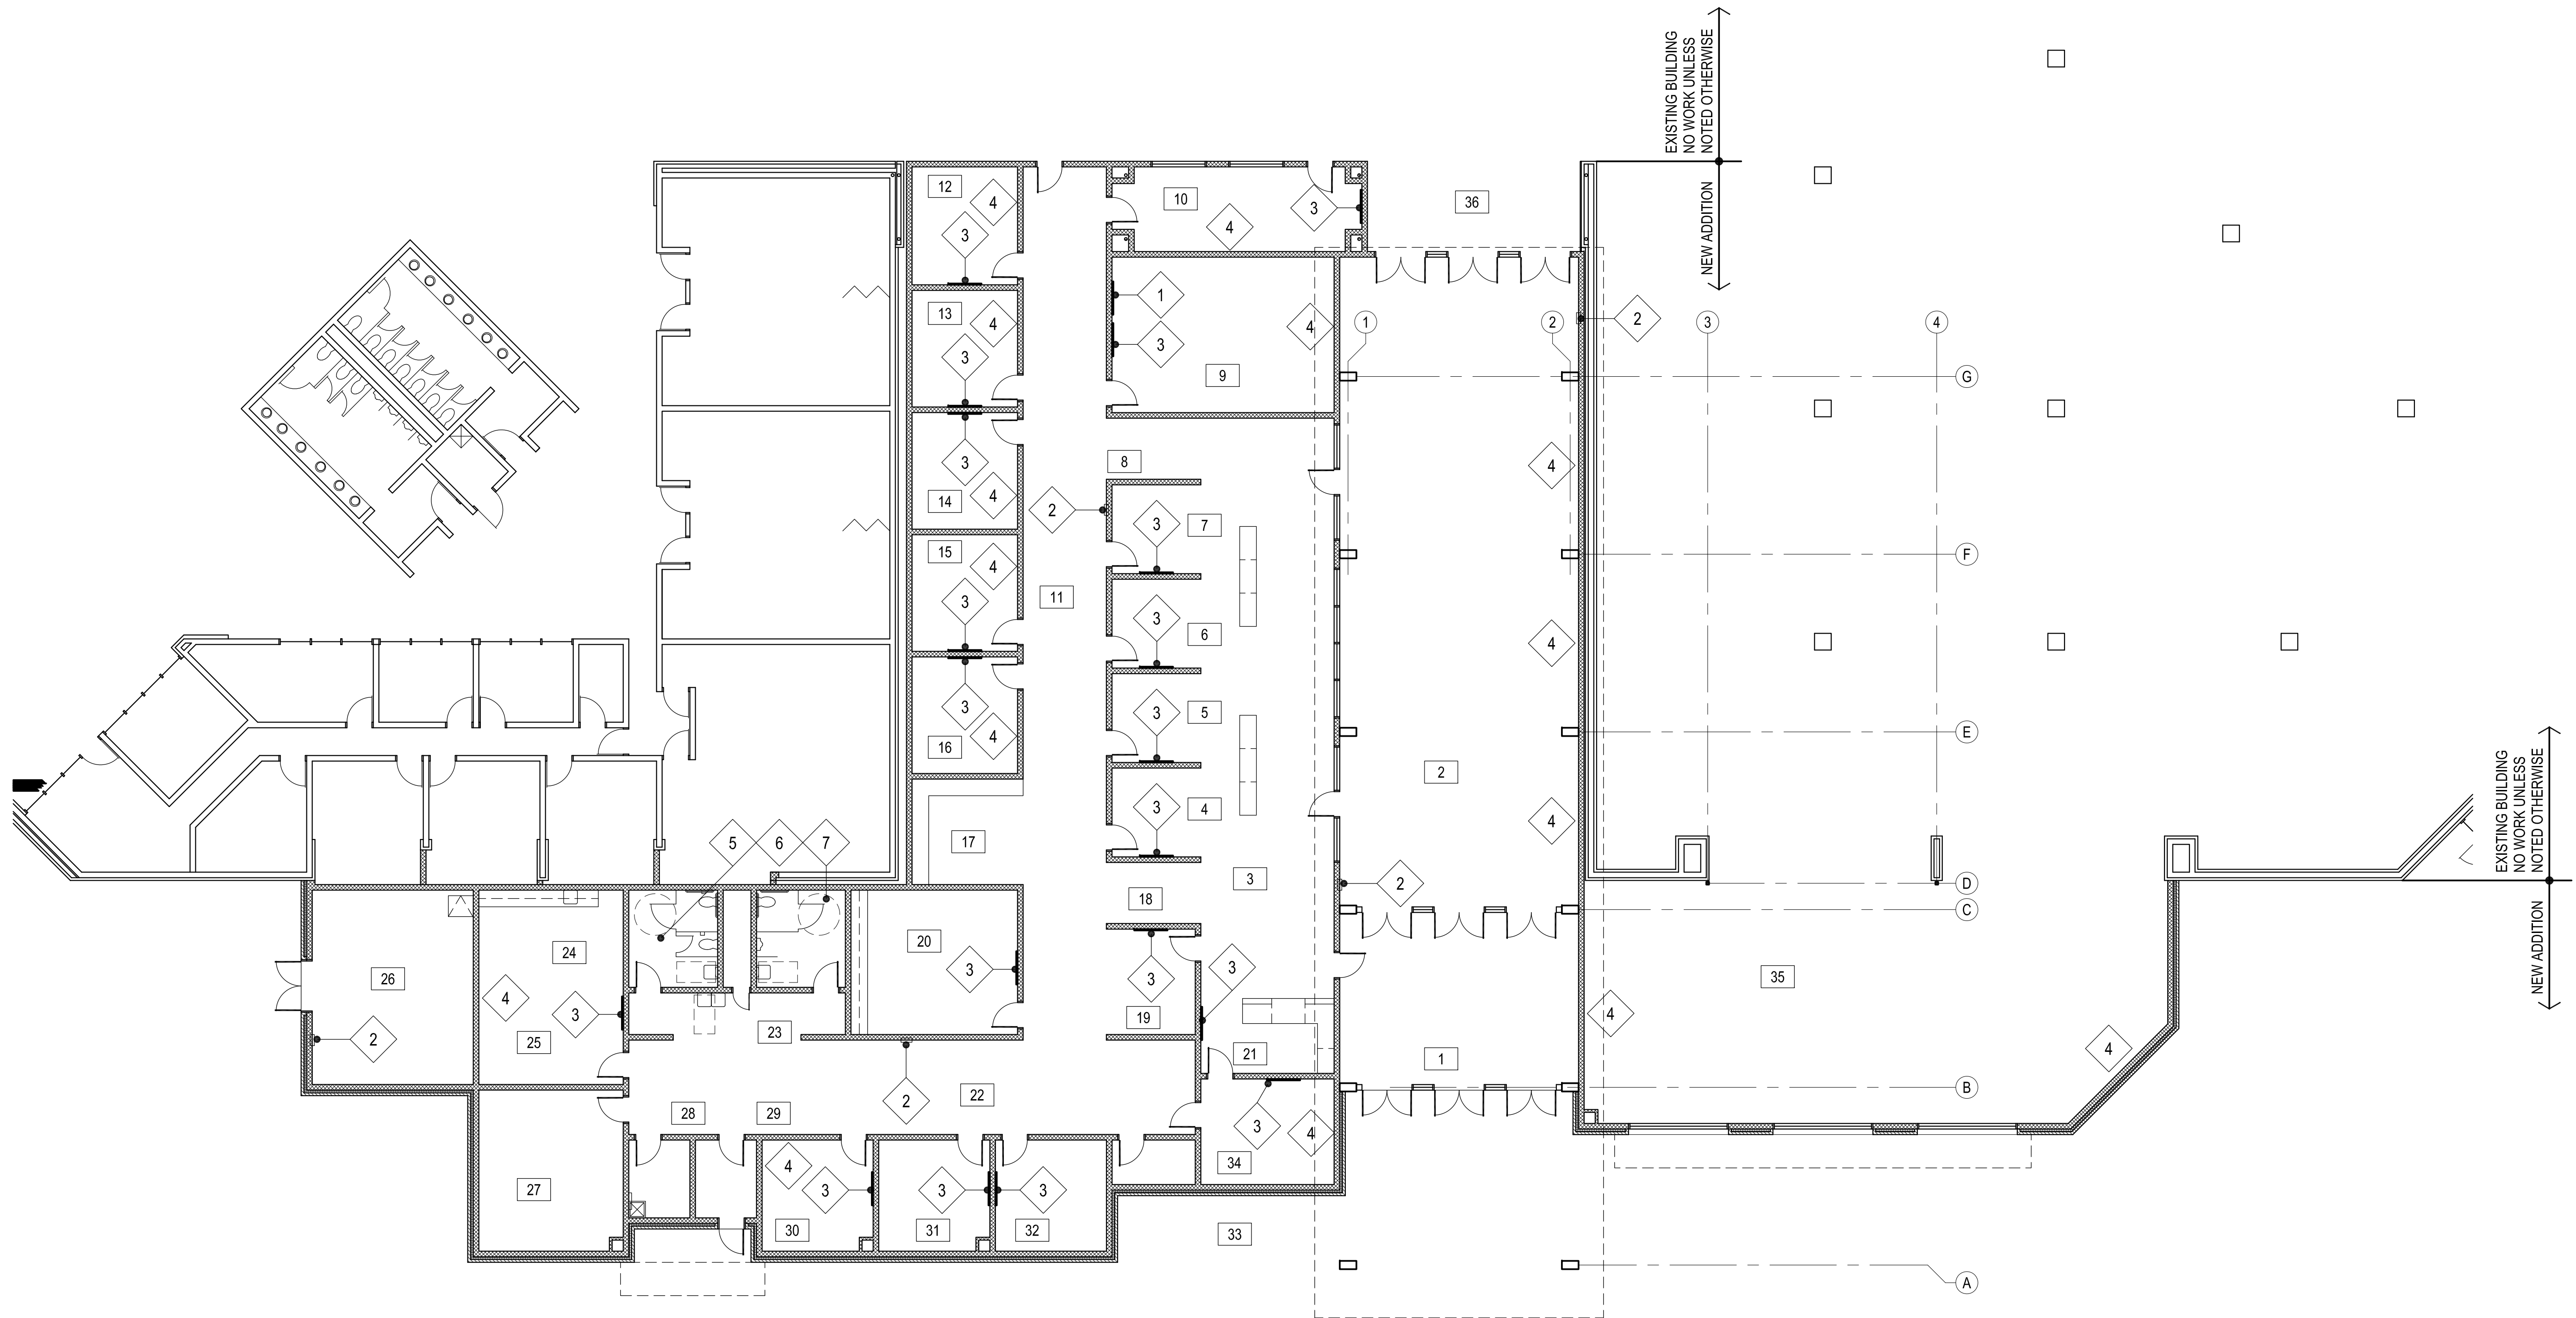

1

**EQUIPMENT FLOOR PLAN**  
3/32" = 1'-0"

ITEM NO.	CFI / OF / OI	DESCRIPTION	MANUFACTURER		REMARKS
			NAME	MODEL NO.	
1	●	MARKERBOARD - 4'-0"	BEST-RITE CHALKBOARD CO.	RE: SPECS	W/ CHALK RAIL
2	●	FIRE EXTINGUISHER & CABINET	JL INDUSTRIES	RE: SPECS	
3	●	TACKBOARD - 4'-0"	BEST-RITE CHALKBOARD CO.	RE: SPECS	
4	●	WALL MOUNTED DISPLAY - SERVICE RECEPTACLES - DEVIES TO BE OF / OI			RE: TECHNOLOGY PLANS
5	●	TOILET PAPER HOLDER			
6	●	PAPER TOWEL DISPENSER			
7	●	SOAP DISPENSER			

2

**EQUIPMENT / FURNITURE SCHEDULE**  
1/8" = 1'-0"

**LEGEND :**

- CONTRACTOR FURNISHED AND INSTALLED (CFI)
- OWNER FURNISHED AND CONTRACTOR INSTALLED (OF / CI)
- OWNER FURNISHED AND OWNER INSTALLED (OF / OI)